
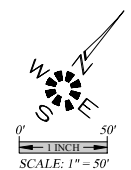


J:\7314\SDR6\SDR6.dwg 2/4/2023 10:32:13 AM CGR

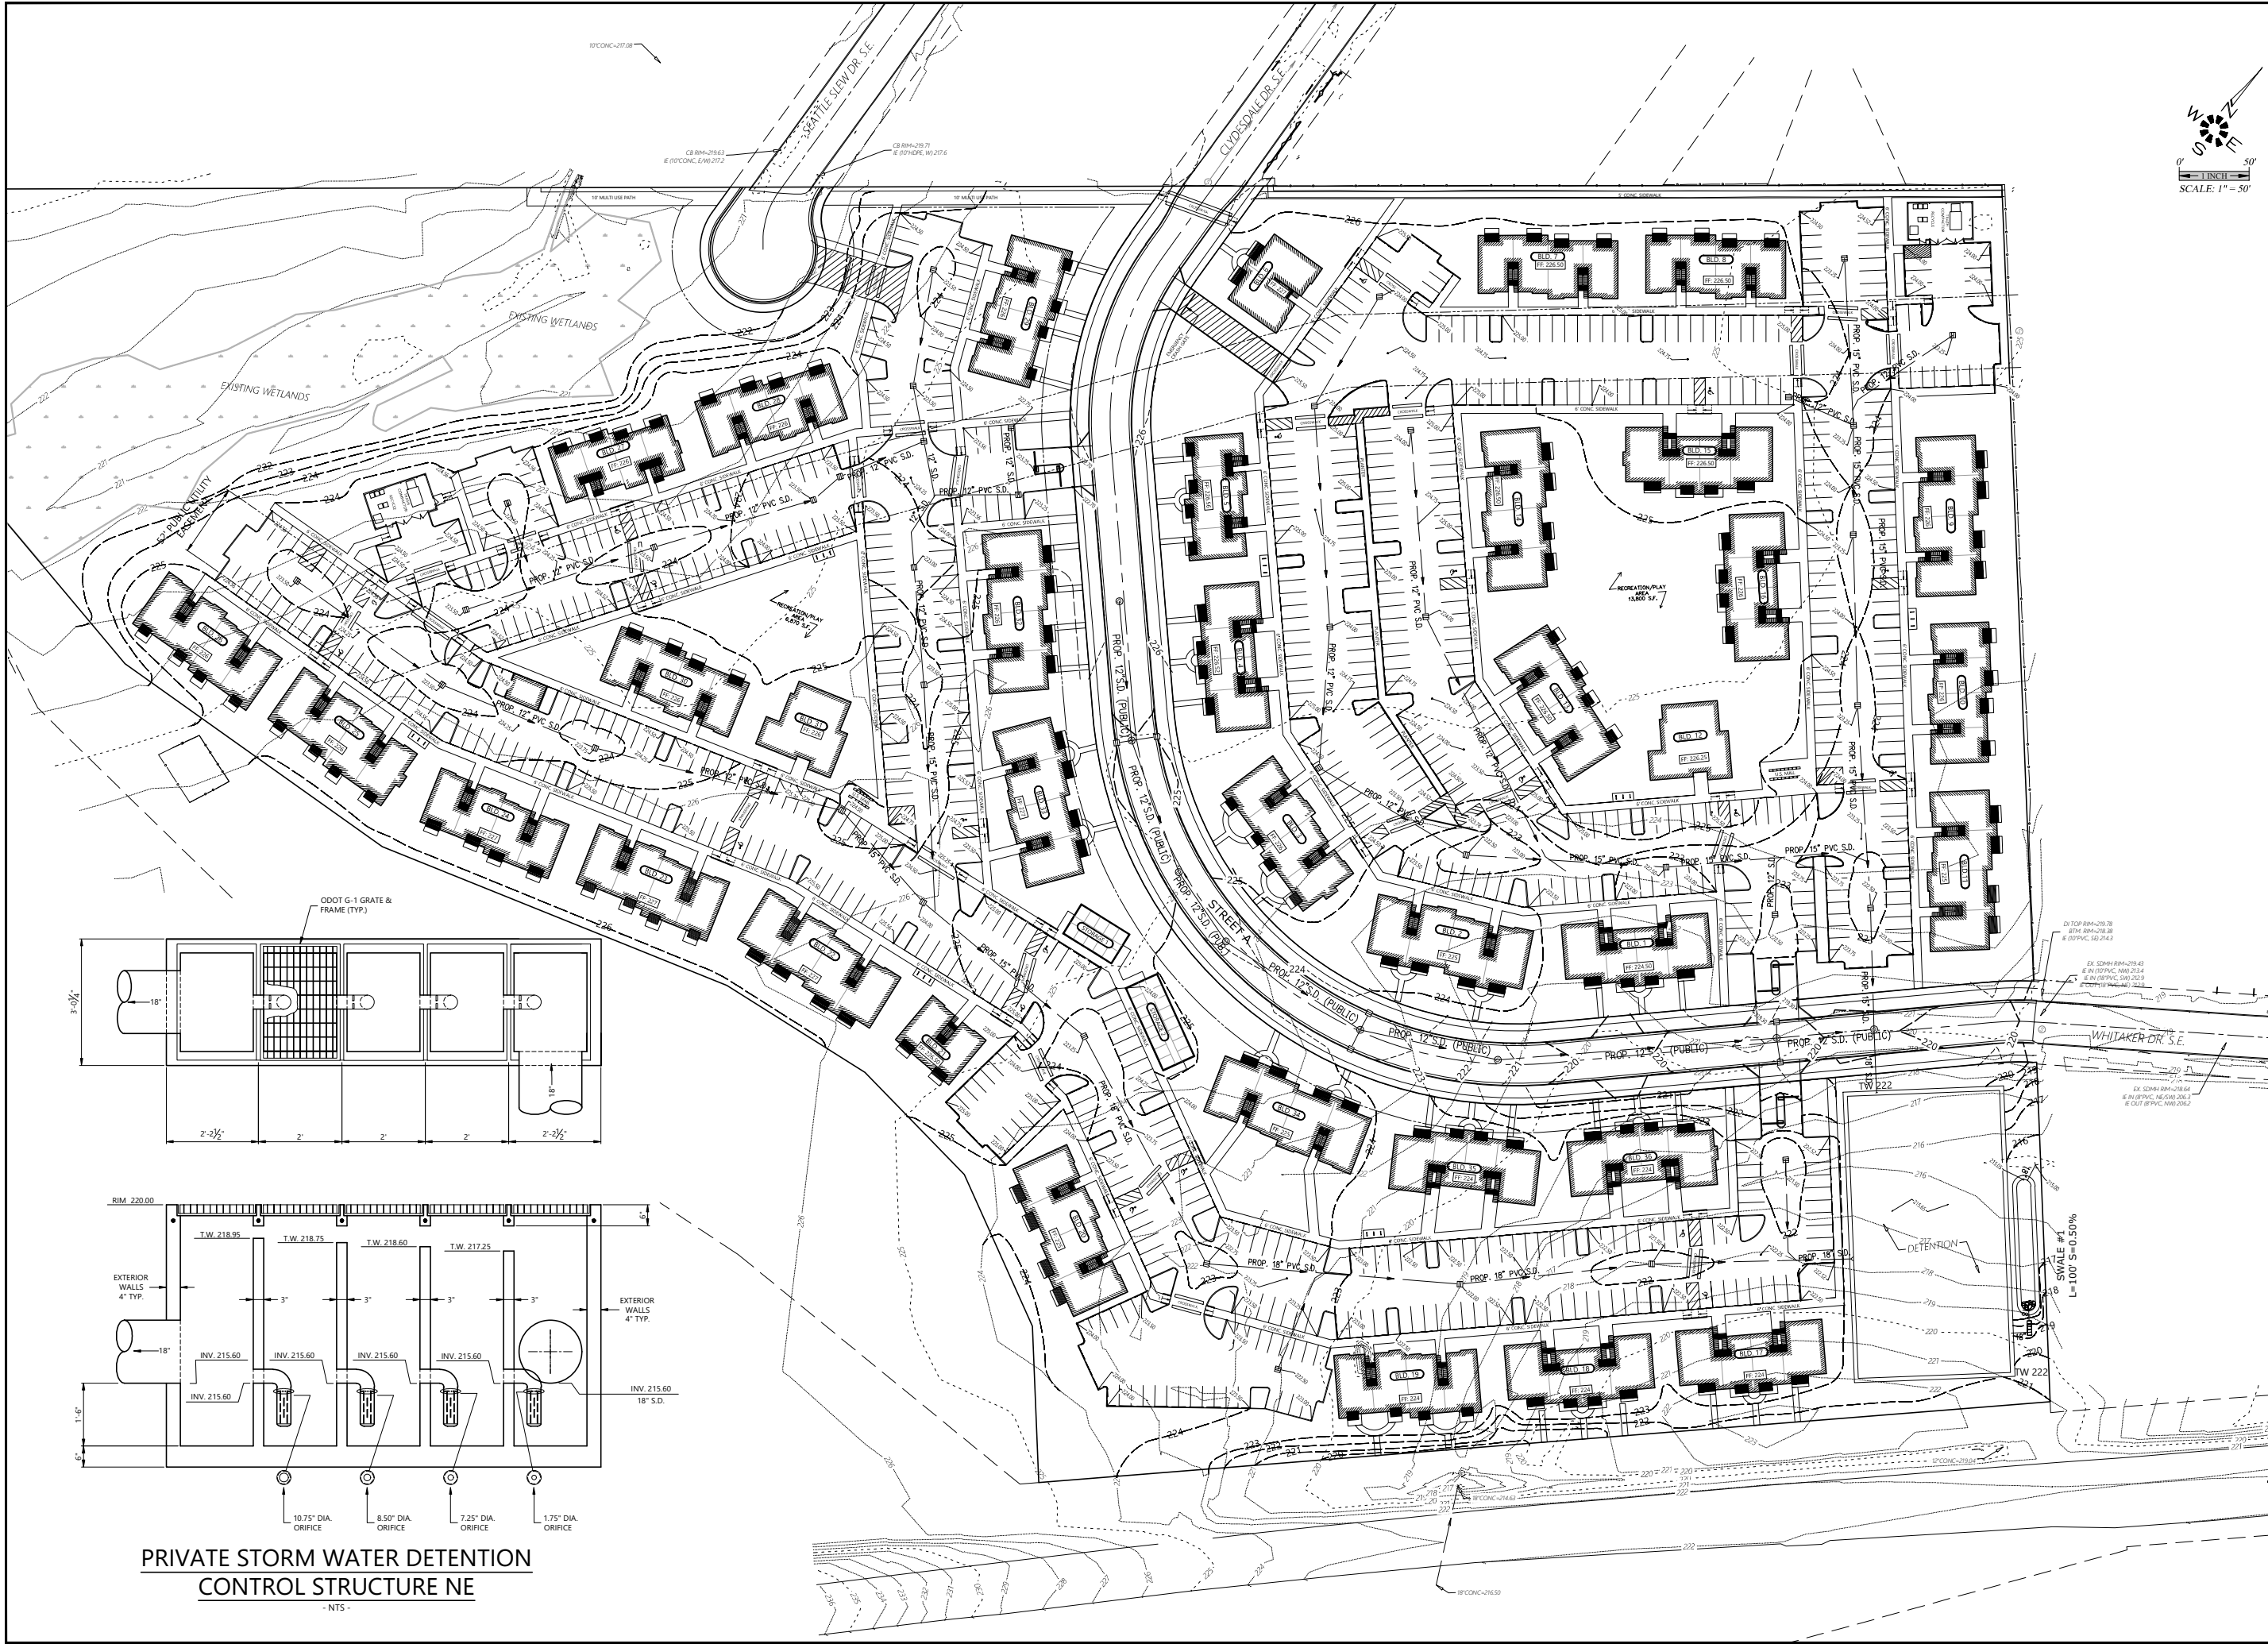

MULTI/TECH

ENGINEERING SERVICES, INC.  
1155 1ST AVE. SE, SUITE 200, SEASIDE, OR 97138  
PH. (503) 363-9227 FAX (503) 364-1260  
www.mteengineering.net office@mteengineering.net

DRAINAGE PLAN

HAWK'S RIDGE APARTMENTS  
PH. 3

NO CHANGES, MODIFICATIONS  
OR REPRODUCTIONS TO BE  
MADE TO THESE DRAWINGS  
WITHOUT THE WRITTEN  
AUTHORIZATION FROM THE  
DESIGN ENGINEER.  
DIMENSIONS & NOTES TAKE  
PRECEDENCE OVER  
GRAPHICAL REPRESENTATION.


7314 SDR6

|          |            |
|----------|------------|
| Design:  | M.D.G.     |
| Drawn:   | A.R.T.     |
| Checked: | B.M.G.     |
| Date:    | SEPT. 2021 |
| Scale:   | AS SHOWN   |

EXPIRES: 06-30-2023

JOB # 7314

SDR6

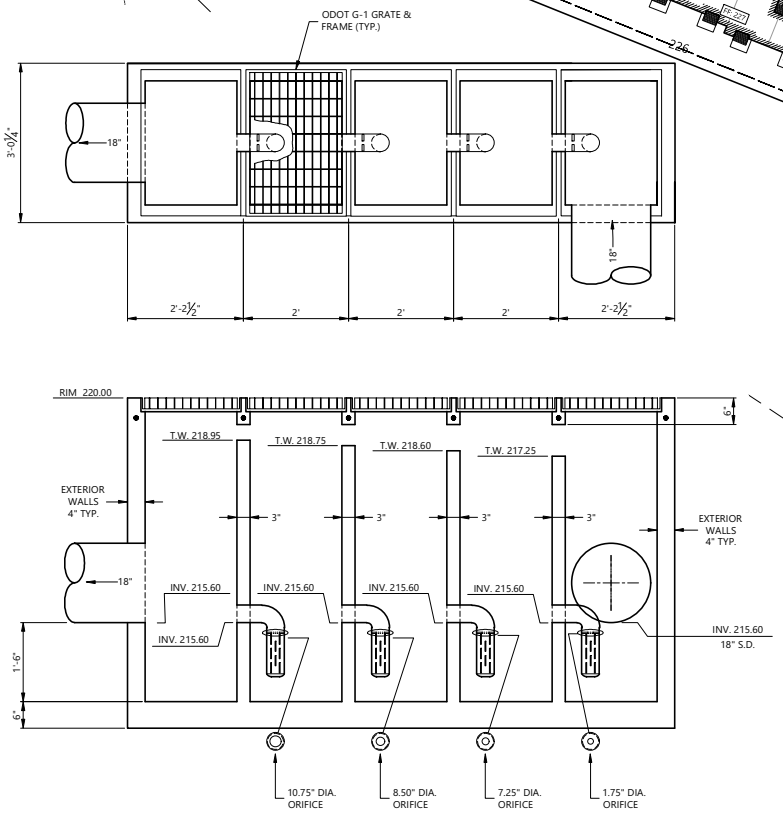

PRIVATE STORM WATER DETENTION  
CONTROL STRUCTURE NE

NTS