


LAST SAVED: Mon, 22 Apr 2024 - 10:45 am LOCATION: C:\Users\trevo\appdata\local\temp\AcPublish_21776\SPR-3_04_19_24.dwg SPR-10-LIGHTING PLAN-DR
PRINTED: Mon, 22 Apr 2024 - 11:46 am PRINTED BY: trevo

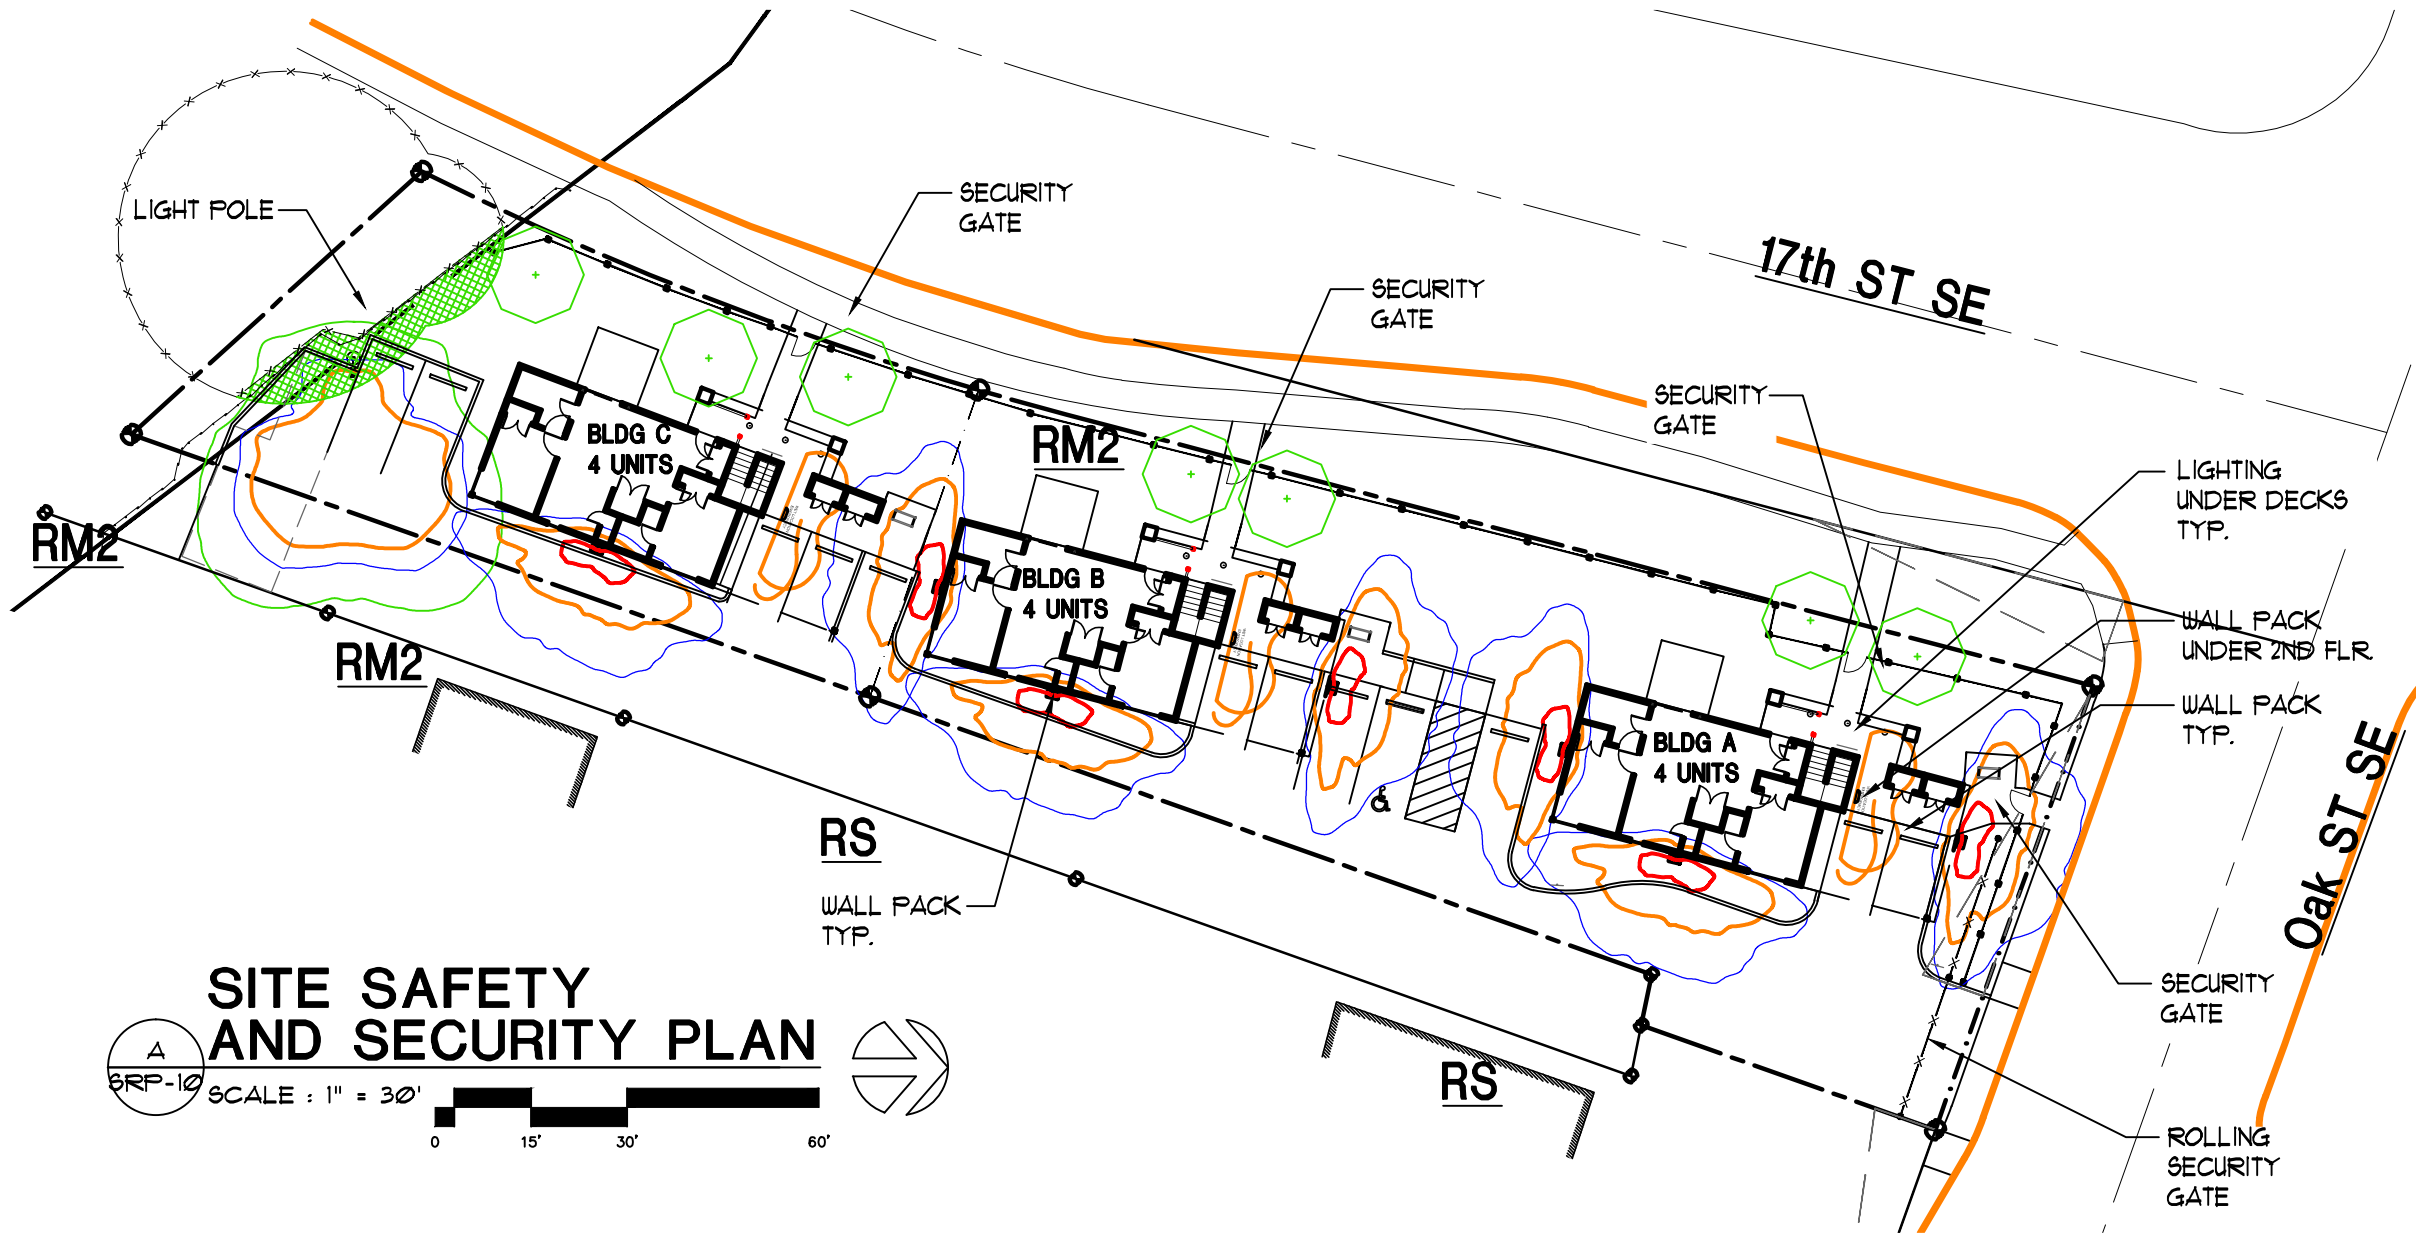

A

SRP-10

SITE SAFETY AND SECURITY PLAN



SCALE : 1" = 30'

0

15'

30'

60'

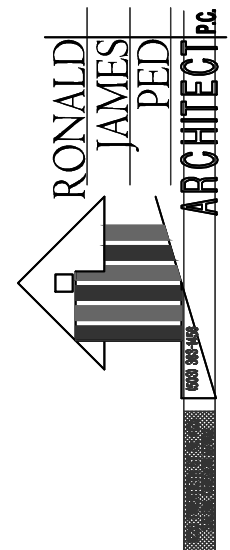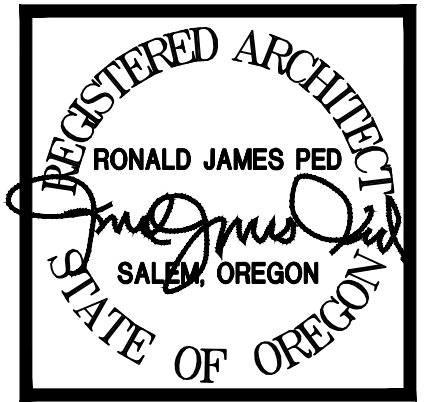

NEW APARTMENTS FOR:
SERVANDO GARCIA
17th and OAK, SALEM OR 97301

DATE: 02-07-2024
DRAWN: TB
JOB NO.: 2159
SPR-10