



LAST SAVED: Thu, 23 May 2024 - 12:17 pm LOCATION: C:\Users\trevo\appdata\local\temp\AcTemp\AcPublish_8708\SPR-3_05.20.24.dwg SPR-10-LIGHTING PLAN-DR
PRINTED: Thu, 23 May 2024 - 12:19 pm PRINTED BY: trevo

REV 1 - 04.09.24
REV 2 - 05.24.24

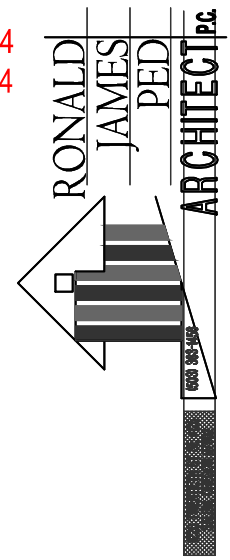

NEW APARTMENTS FOR:
SERVANDO GARCIA
17th and OAK, SALEM OR 97301

DATE: 02-07-2024
DRAWN: TB
JOB NO.: 2159
SPR-10

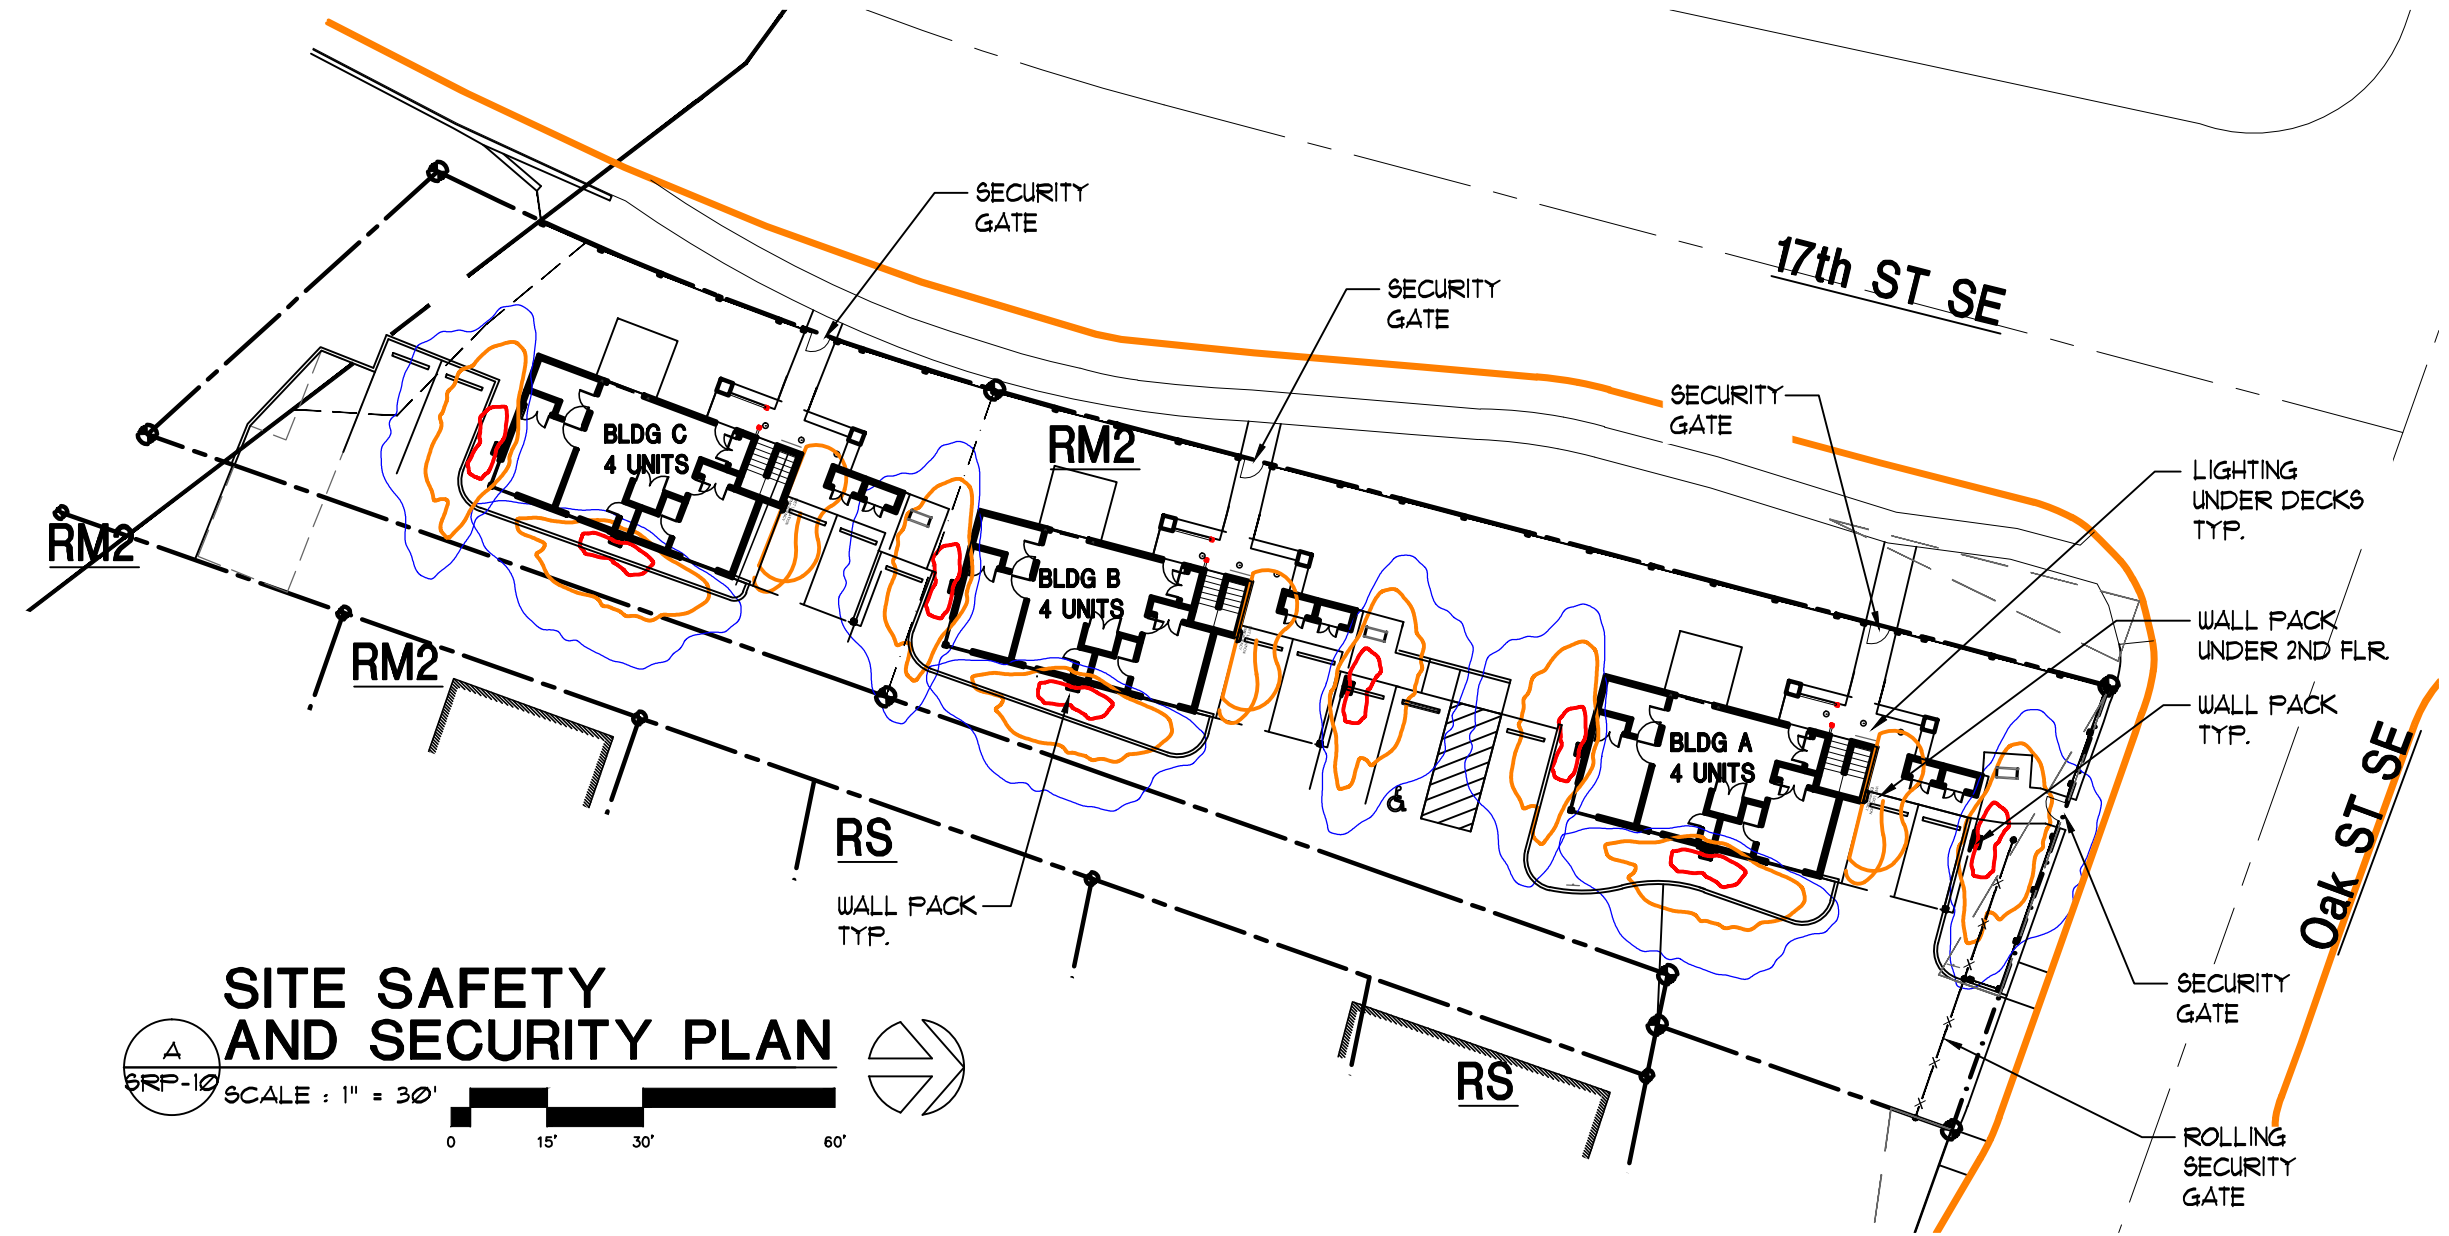

SITE SAFETY AND SECURITY PLAN
SCALE : 1" = 30'
0 15' 30' 60'