



LAST SAVED: Tue, 09 Jul 2024 - 04:20 pm
PRINTED: Tue, 09 Jul 2024 - 04:37 pm
LOCATION: C:\Users\trevo\appdata\local\temp\AcPublish_17820\SPR-3_07.09.24.dwg
PRINTED BY: trevo
SPR-10-LIGHTING PLAN-DR

REV 1 - 04.09.24
REV 2 - 05.24.24
REV 3 - 07.09.24

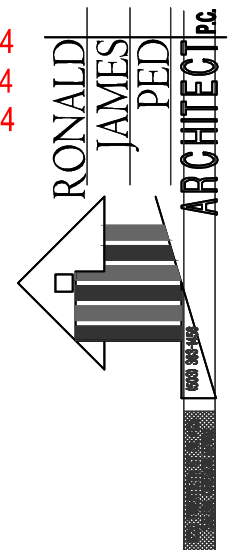

NEW APARTMENTS FOR:
SERVANDO GARCIA
17th and OAK, SALEM OR 97301

DATE: 02-07-2024
DRAWN: TB
JOB NO.: 2159
SPR-10

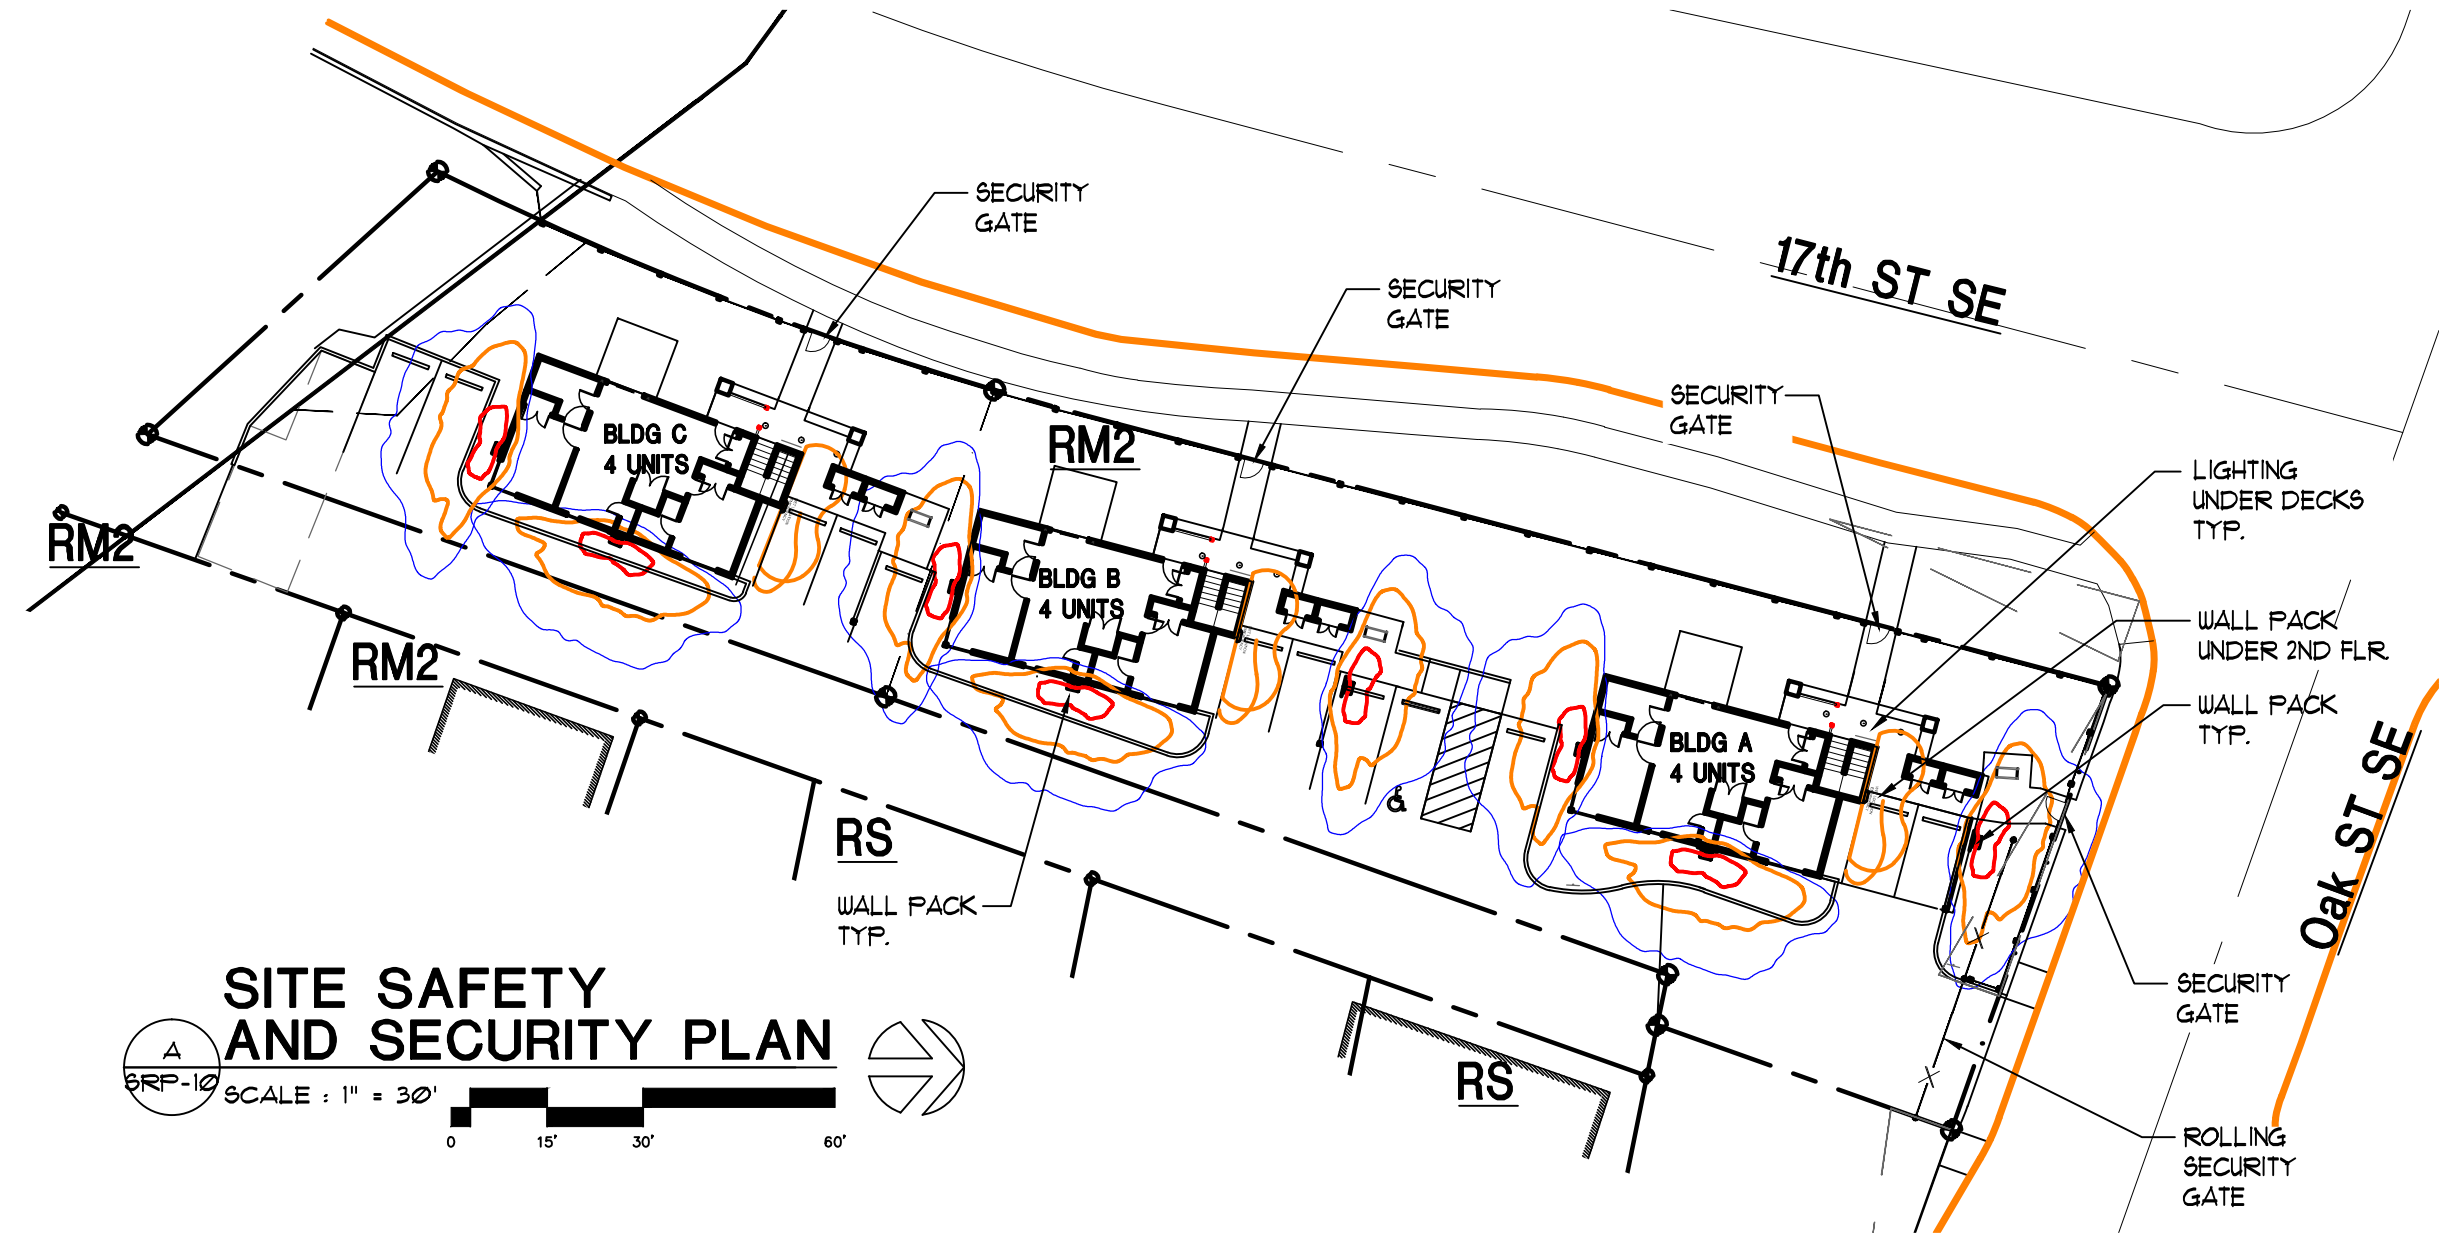

A

GRP-10

SITE SAFETY AND SECURITY PLAN

SCALE : 1" = 30'

0

15'

30'

60'