
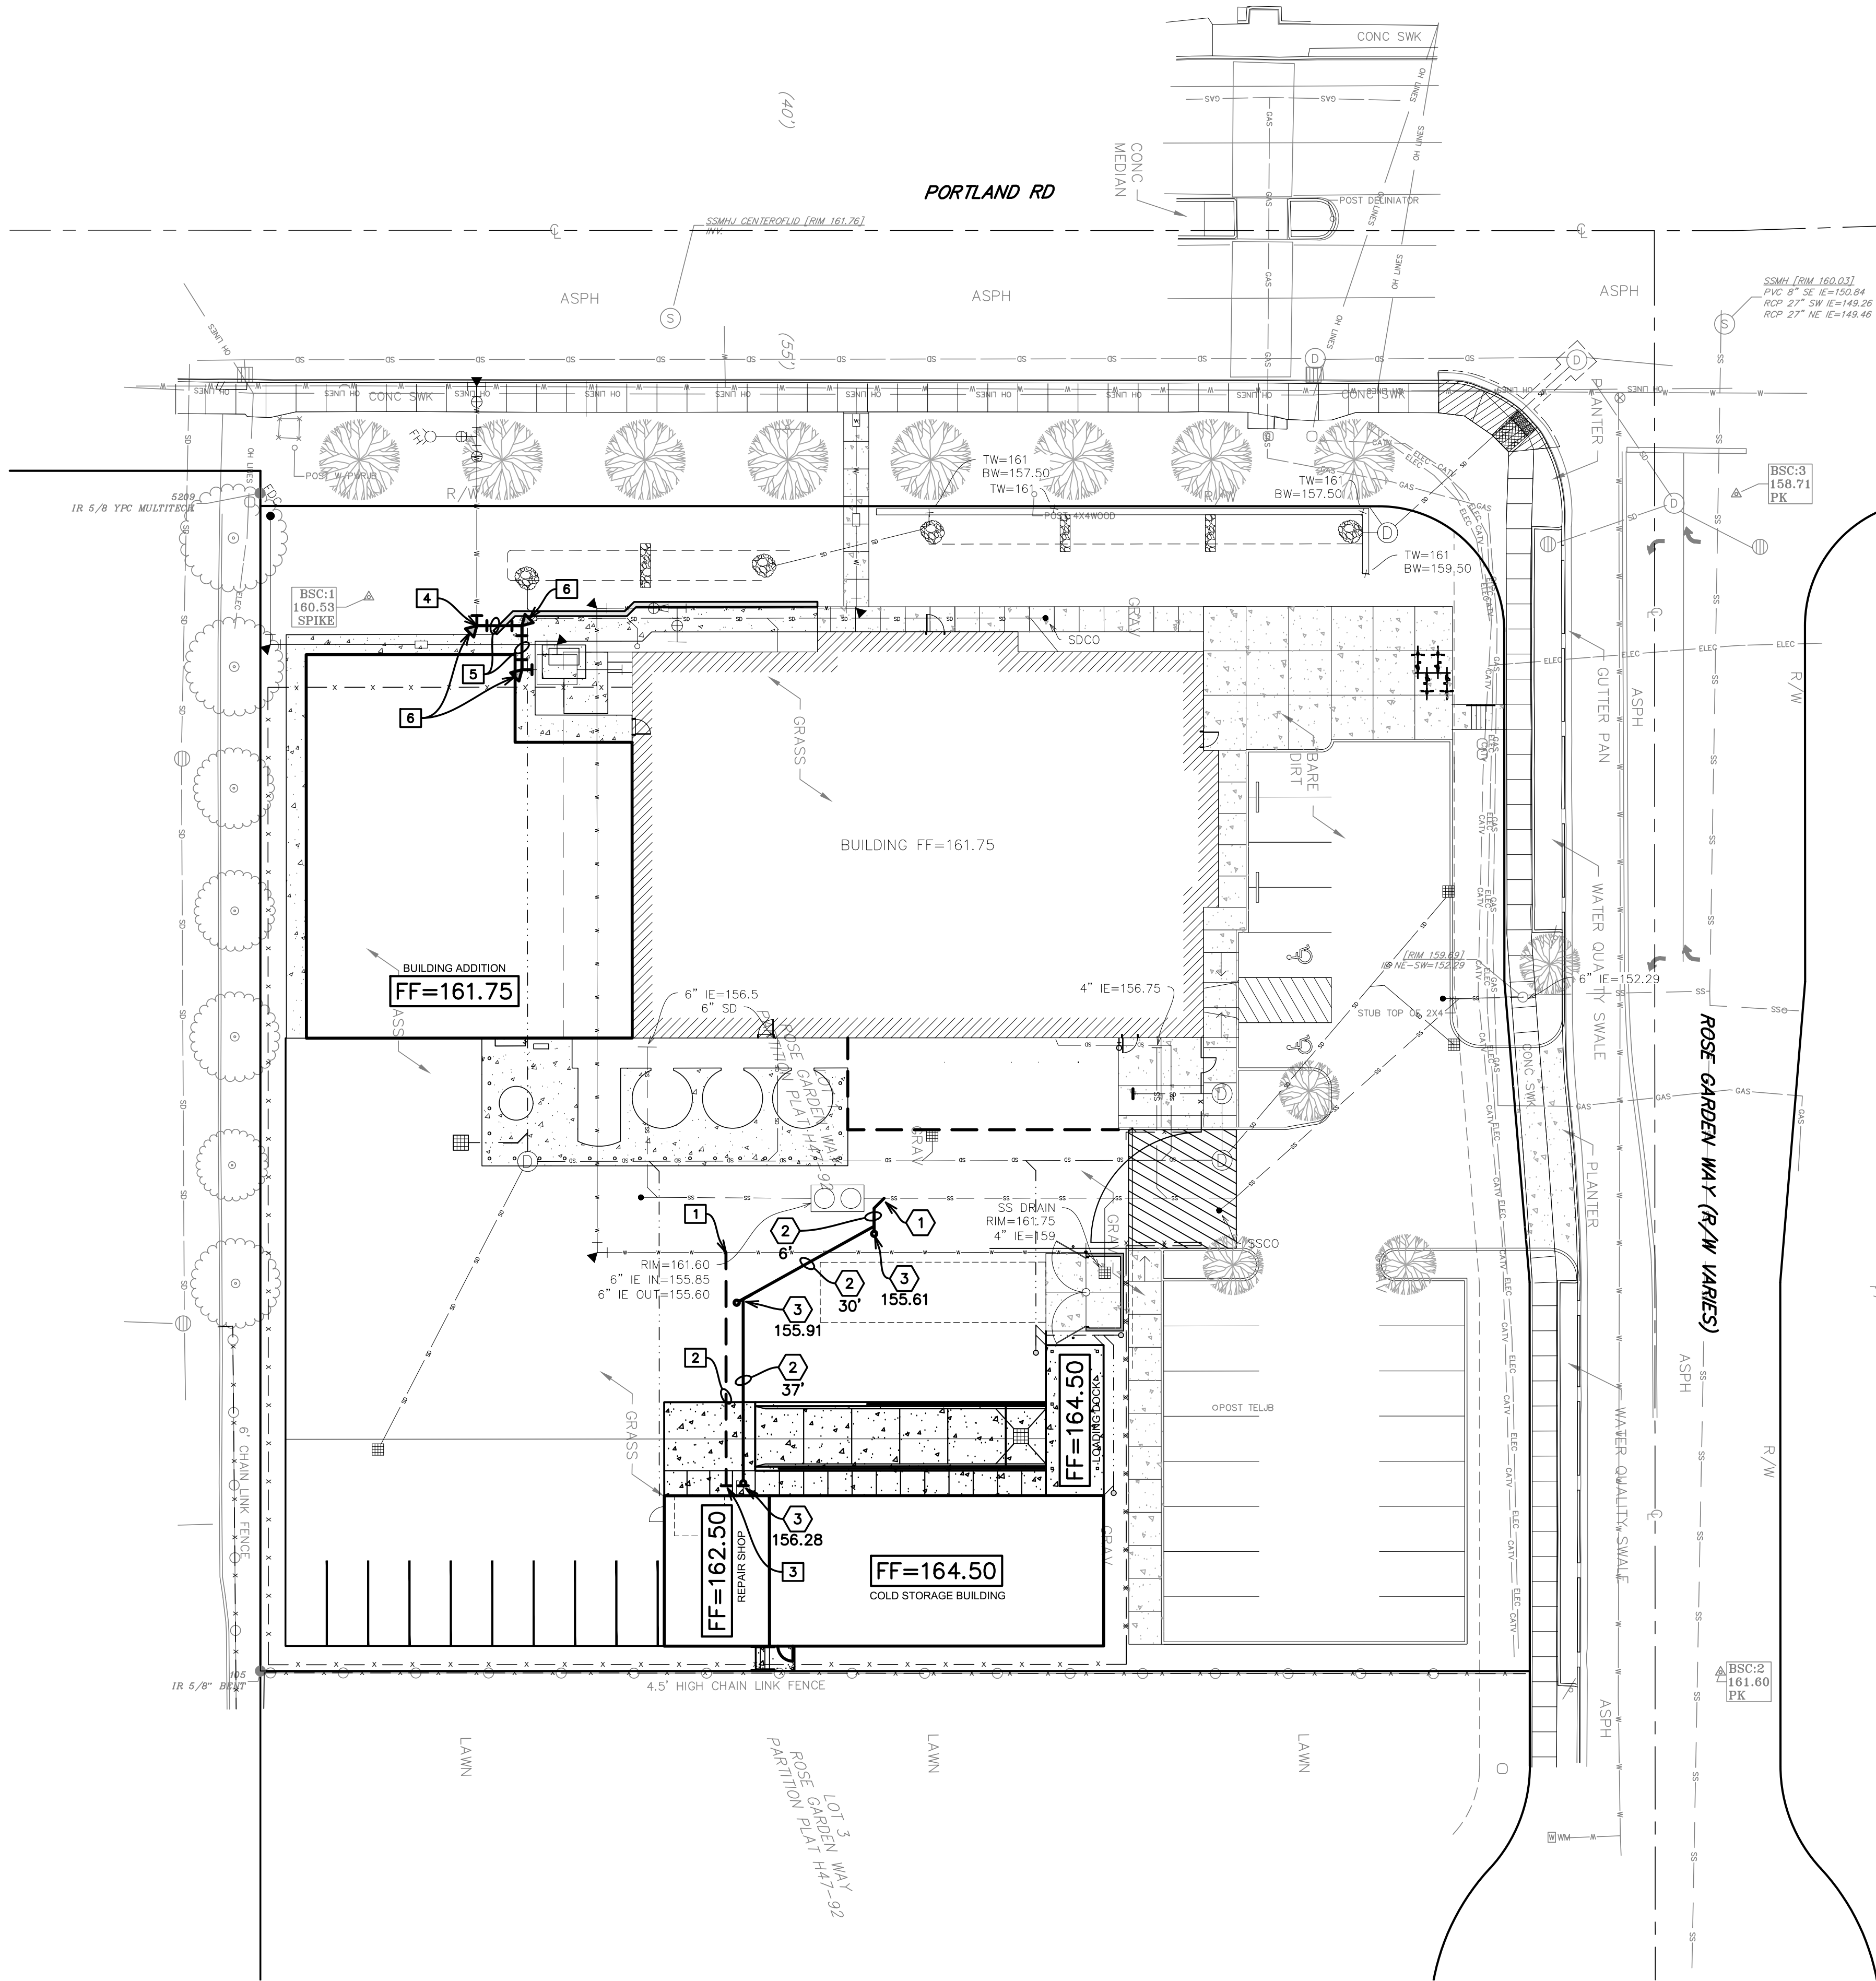


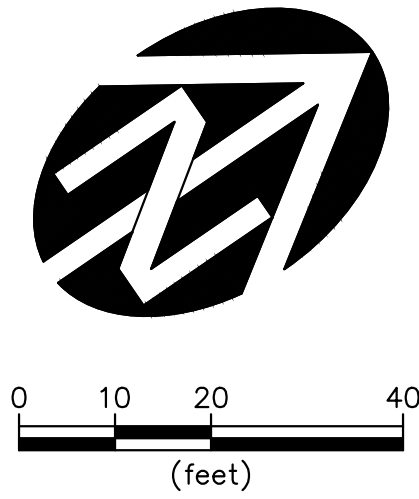

SANITARY SEWER KEY CALLOUTS	
1	CONTRACTOR TO TAP EXT'G 6"SS @ IE=155.55
2	6"SS, S=1% MIN, L=SEE PLAN
3	SSCO, IE=SEE PLAN
NOTES	
WATER KEY CALLOUTS	
1	CONTRACTOR TO TAP EXT'G 1" W/L
2	1" SCH40 PVC DOMESTIC WATER LINE
3	SEE PLUMBING FOR CONTINUATION
4	CONTRACTOR TO REROUTE 6" FIRE SERVICE
5	6" PRIVATE FIRE LINE
6	6" 90° BEND W/ TB
NOTES	
1. ALL JOINTS AND FITTINGS TO BE MECHANICALLY RESTRAINED	

project:
DON FROYLAN CREAMERY
BUILDING ADDITION PHASE 1
3310 PORTLAND RD NE
SALEM, OREGON 97301

revisions:	
1	
2	
3	
4	

date: 06.26.24
project: 2931.1000.0
dwg file:
drawn by: AK
checked by: JW
copyright © 2022
Carlson Veit Architects P.C.

UTILITY PLAN
sheet:
C3.0
of:

CARLSON
VEIT
JUNGE
ARCHITECTS PC

ARCHITECTURE • INTERIOR DESIGN
3095 RIVER RD N. SALEM, OREGON 97303
WWW.CARLSONVEIT.COM • 503-390-0281

REGISTERED PROFESSIONAL
ENGINEER
CREATED BY
WILLIAM J. STEIN
000123456789
REVIEW
DATE: 6/20/2024

WESTTECH ENGINEERING, INC.
CONSULTING ENGINEERS AND PLANNERS

3841 Fairview Industrial Dr. S.E., Suite 100, Salem, OR 97302
Phone: (503) 585-2474 Fax: (503) 585-3986
E-mail: westtech@westtech-eng.com