



SEE PREVIOUS DESIGN FOR GREEN STORMWATER INFRASTRUCTURE.

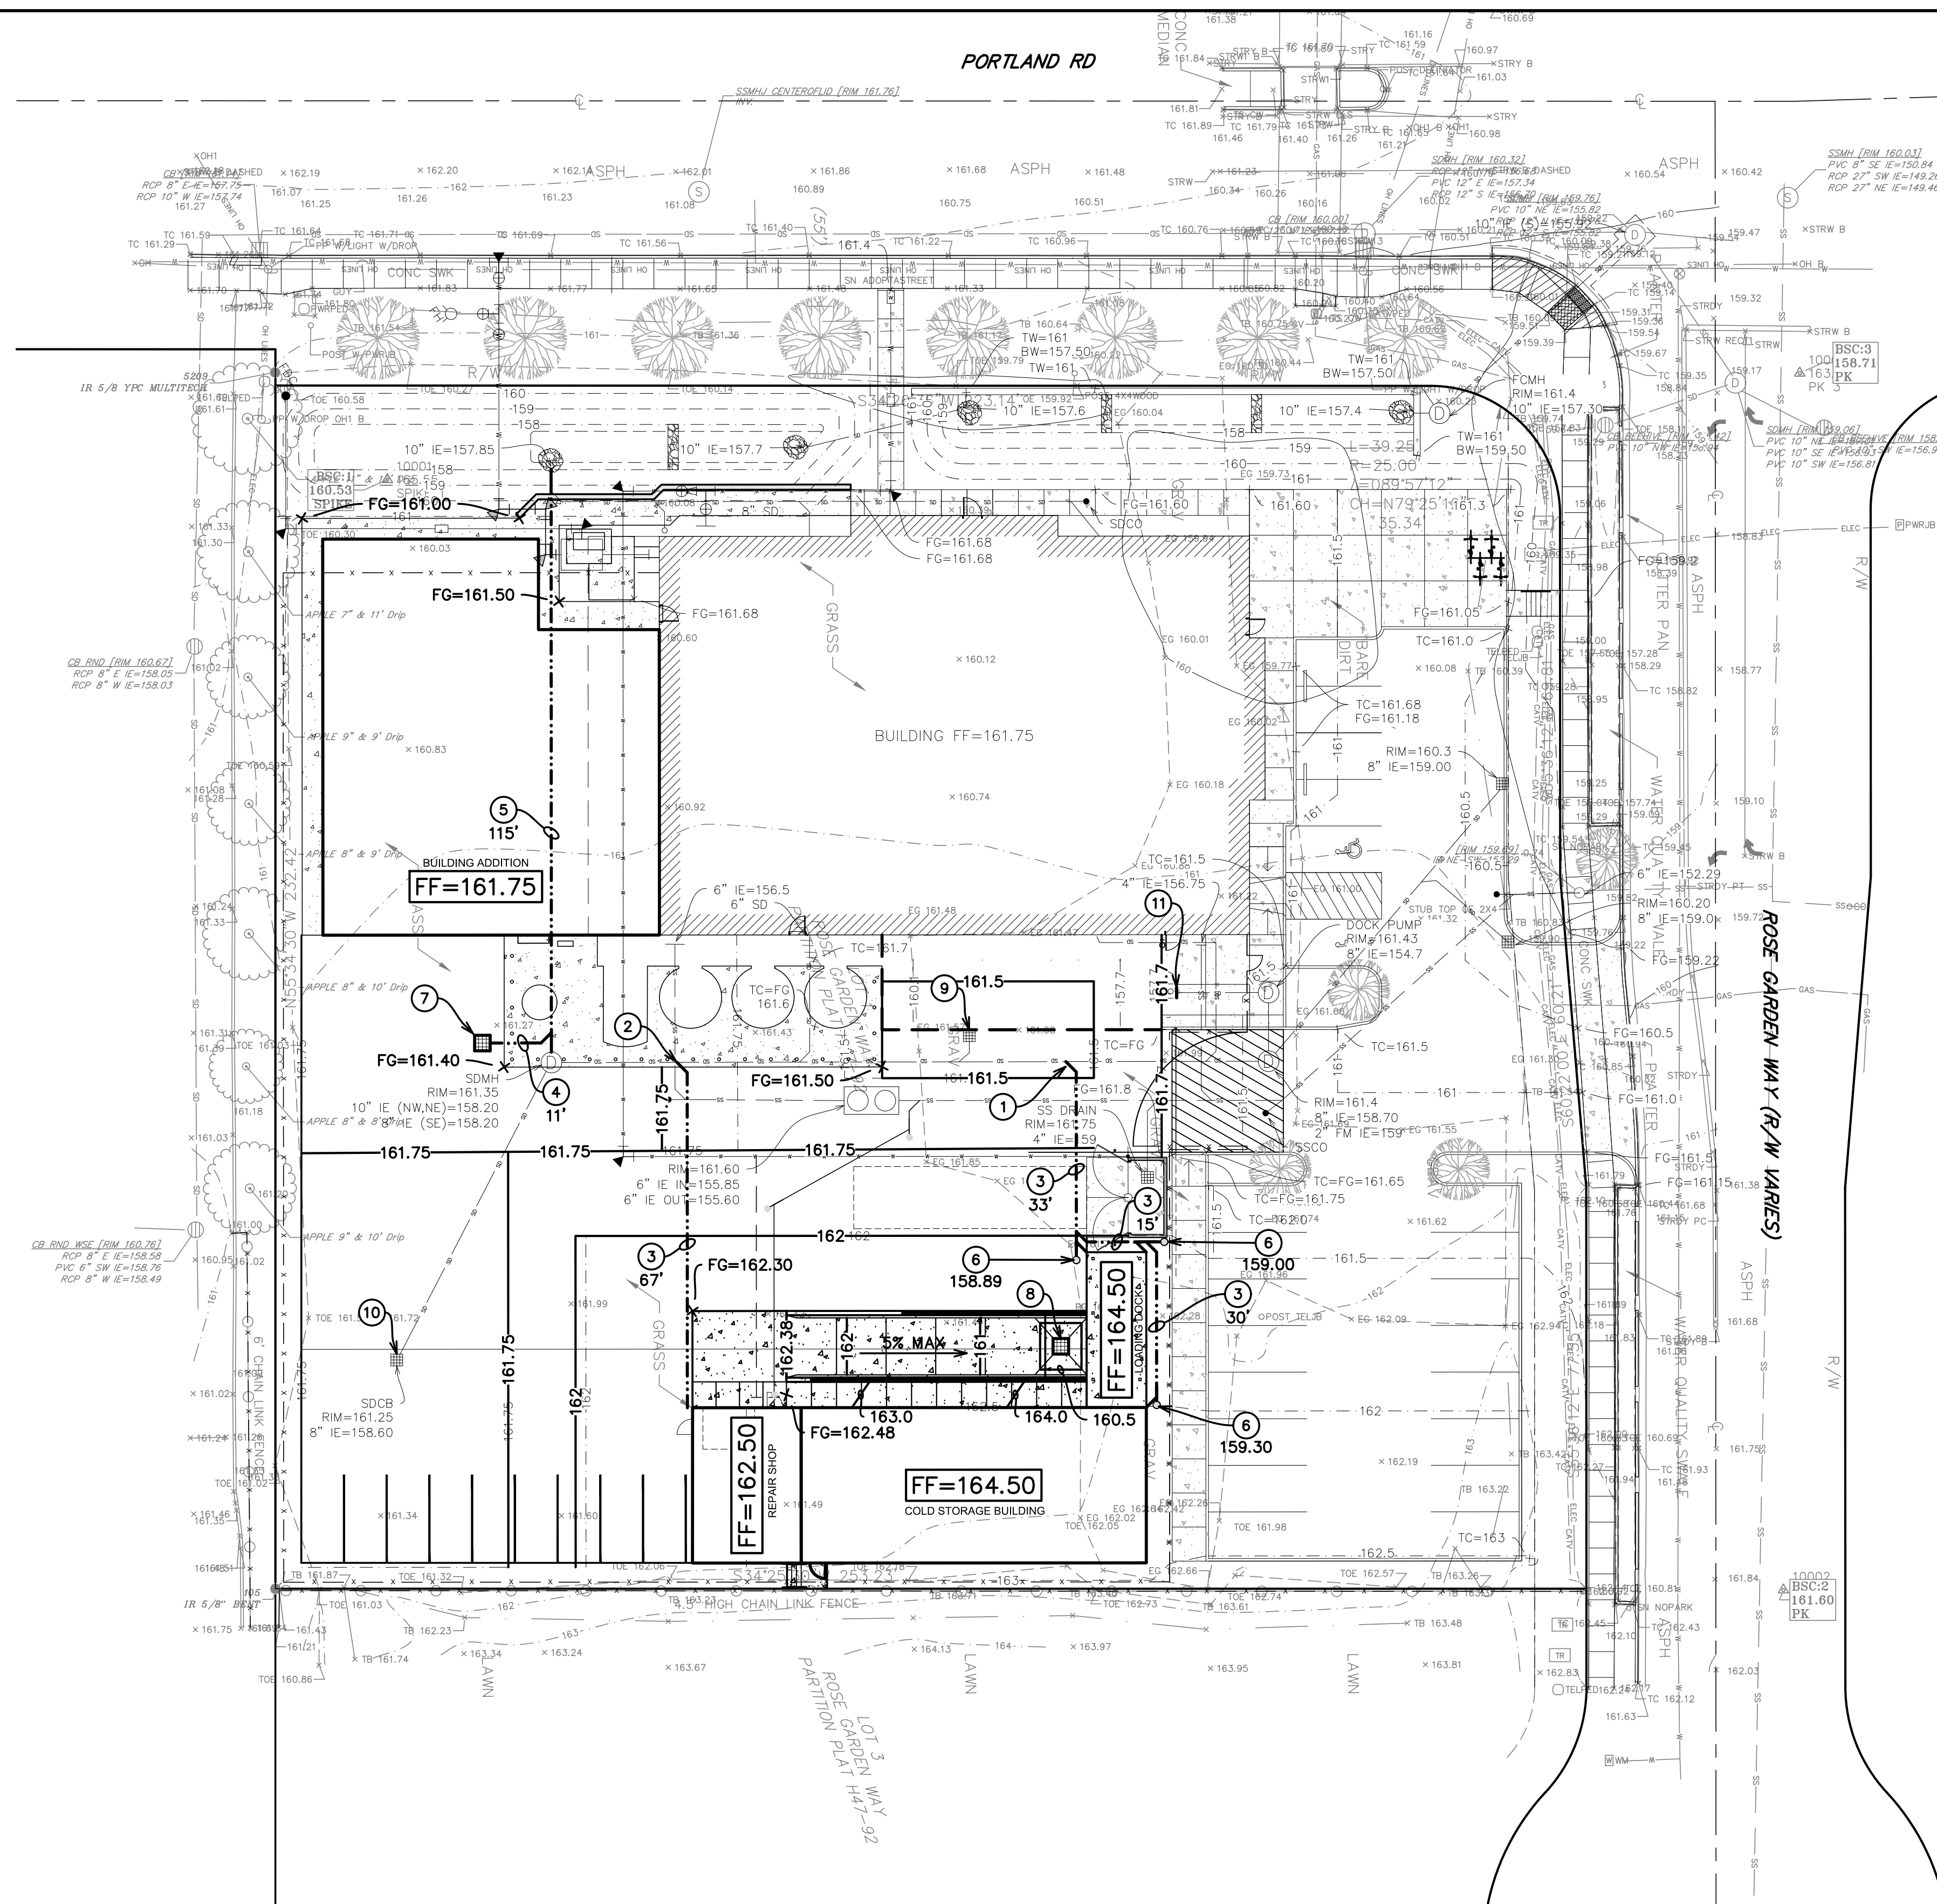

DRAINAGE KEY CALLOUTS	
①	CONNECT TO EXT'G 8"SD ☉ IE=158.52
②	CONNECT TO EXT'G 8"SD ☉ IE=158.34
③	6"RD, L=SEE PLAN, S=1% MIN
④	8" SD, S=0.5% MIN, L=SEE PLAN
⑤	10" DI SD, S=0.4% MIN, L=SEE PLAN
⑥	SDCO, IE=SEE PLAN
⑦	SDCB R=161.32 8" IE OUT (N)=158.25
⑧	SDCB R=160.3
⑨	ADJUSTED SDCB
⑩	ADJUSTED SDCB R=161.25
⑪	PLUG SD
NOTES	

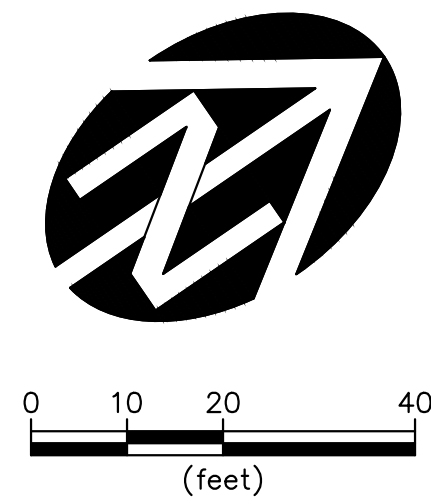

**CARLSON
VEIT
JUNGE
ARCHITECTS PC**

ARCHITECTURE • INTERIOR DESIGN

3092 RIVER RD N., SALEM, OREGON 97303
WWW.CARLSONVEIT.COM • 503-390-0281



Subject: DON FROYLAN CREAMERY
BUILDING ADDITION PHASE 1
33310 PORTLAND RD NE
SALEM, OREGON 97301

WESTTECH ENGINEERING, INC.
CONSULTING ENGINEERS AND PLANNERS

341 Fairview Industrial Dr. S.E., Suite 100, Salem, OR 97301
Phone: (503) 585-2474 Fax: (503) 585-3986
E-mail: westtech@westtech-eng.com

revisions:
 




date: 06.26.24
project: 2931.1000.0
dwg file:
drawn by: AK
checked by: JW
copyright © 2022
Carlson Veit Architects P.C.

GRADING & DRAINAGE PLAN

sheet: **C2.0**