
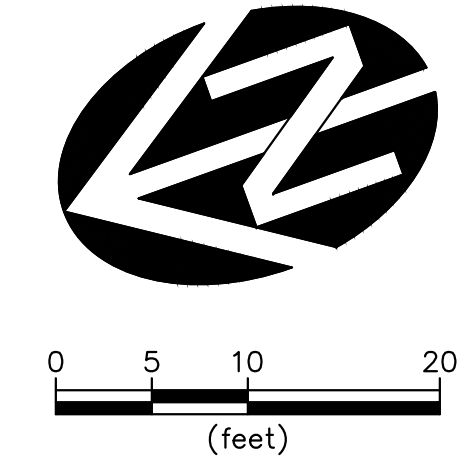


8/16/2024 3:35:36 PM C:\Users\GAD\OneDrive\Engineering\Drawings\Kenyon\My PC (108-18)\Desktop\Work (PC)\Projects\Studio 3\2020 State St\Civil\Plans\C3.0 - Utility Plan.dwg. (C3.0 Tab)

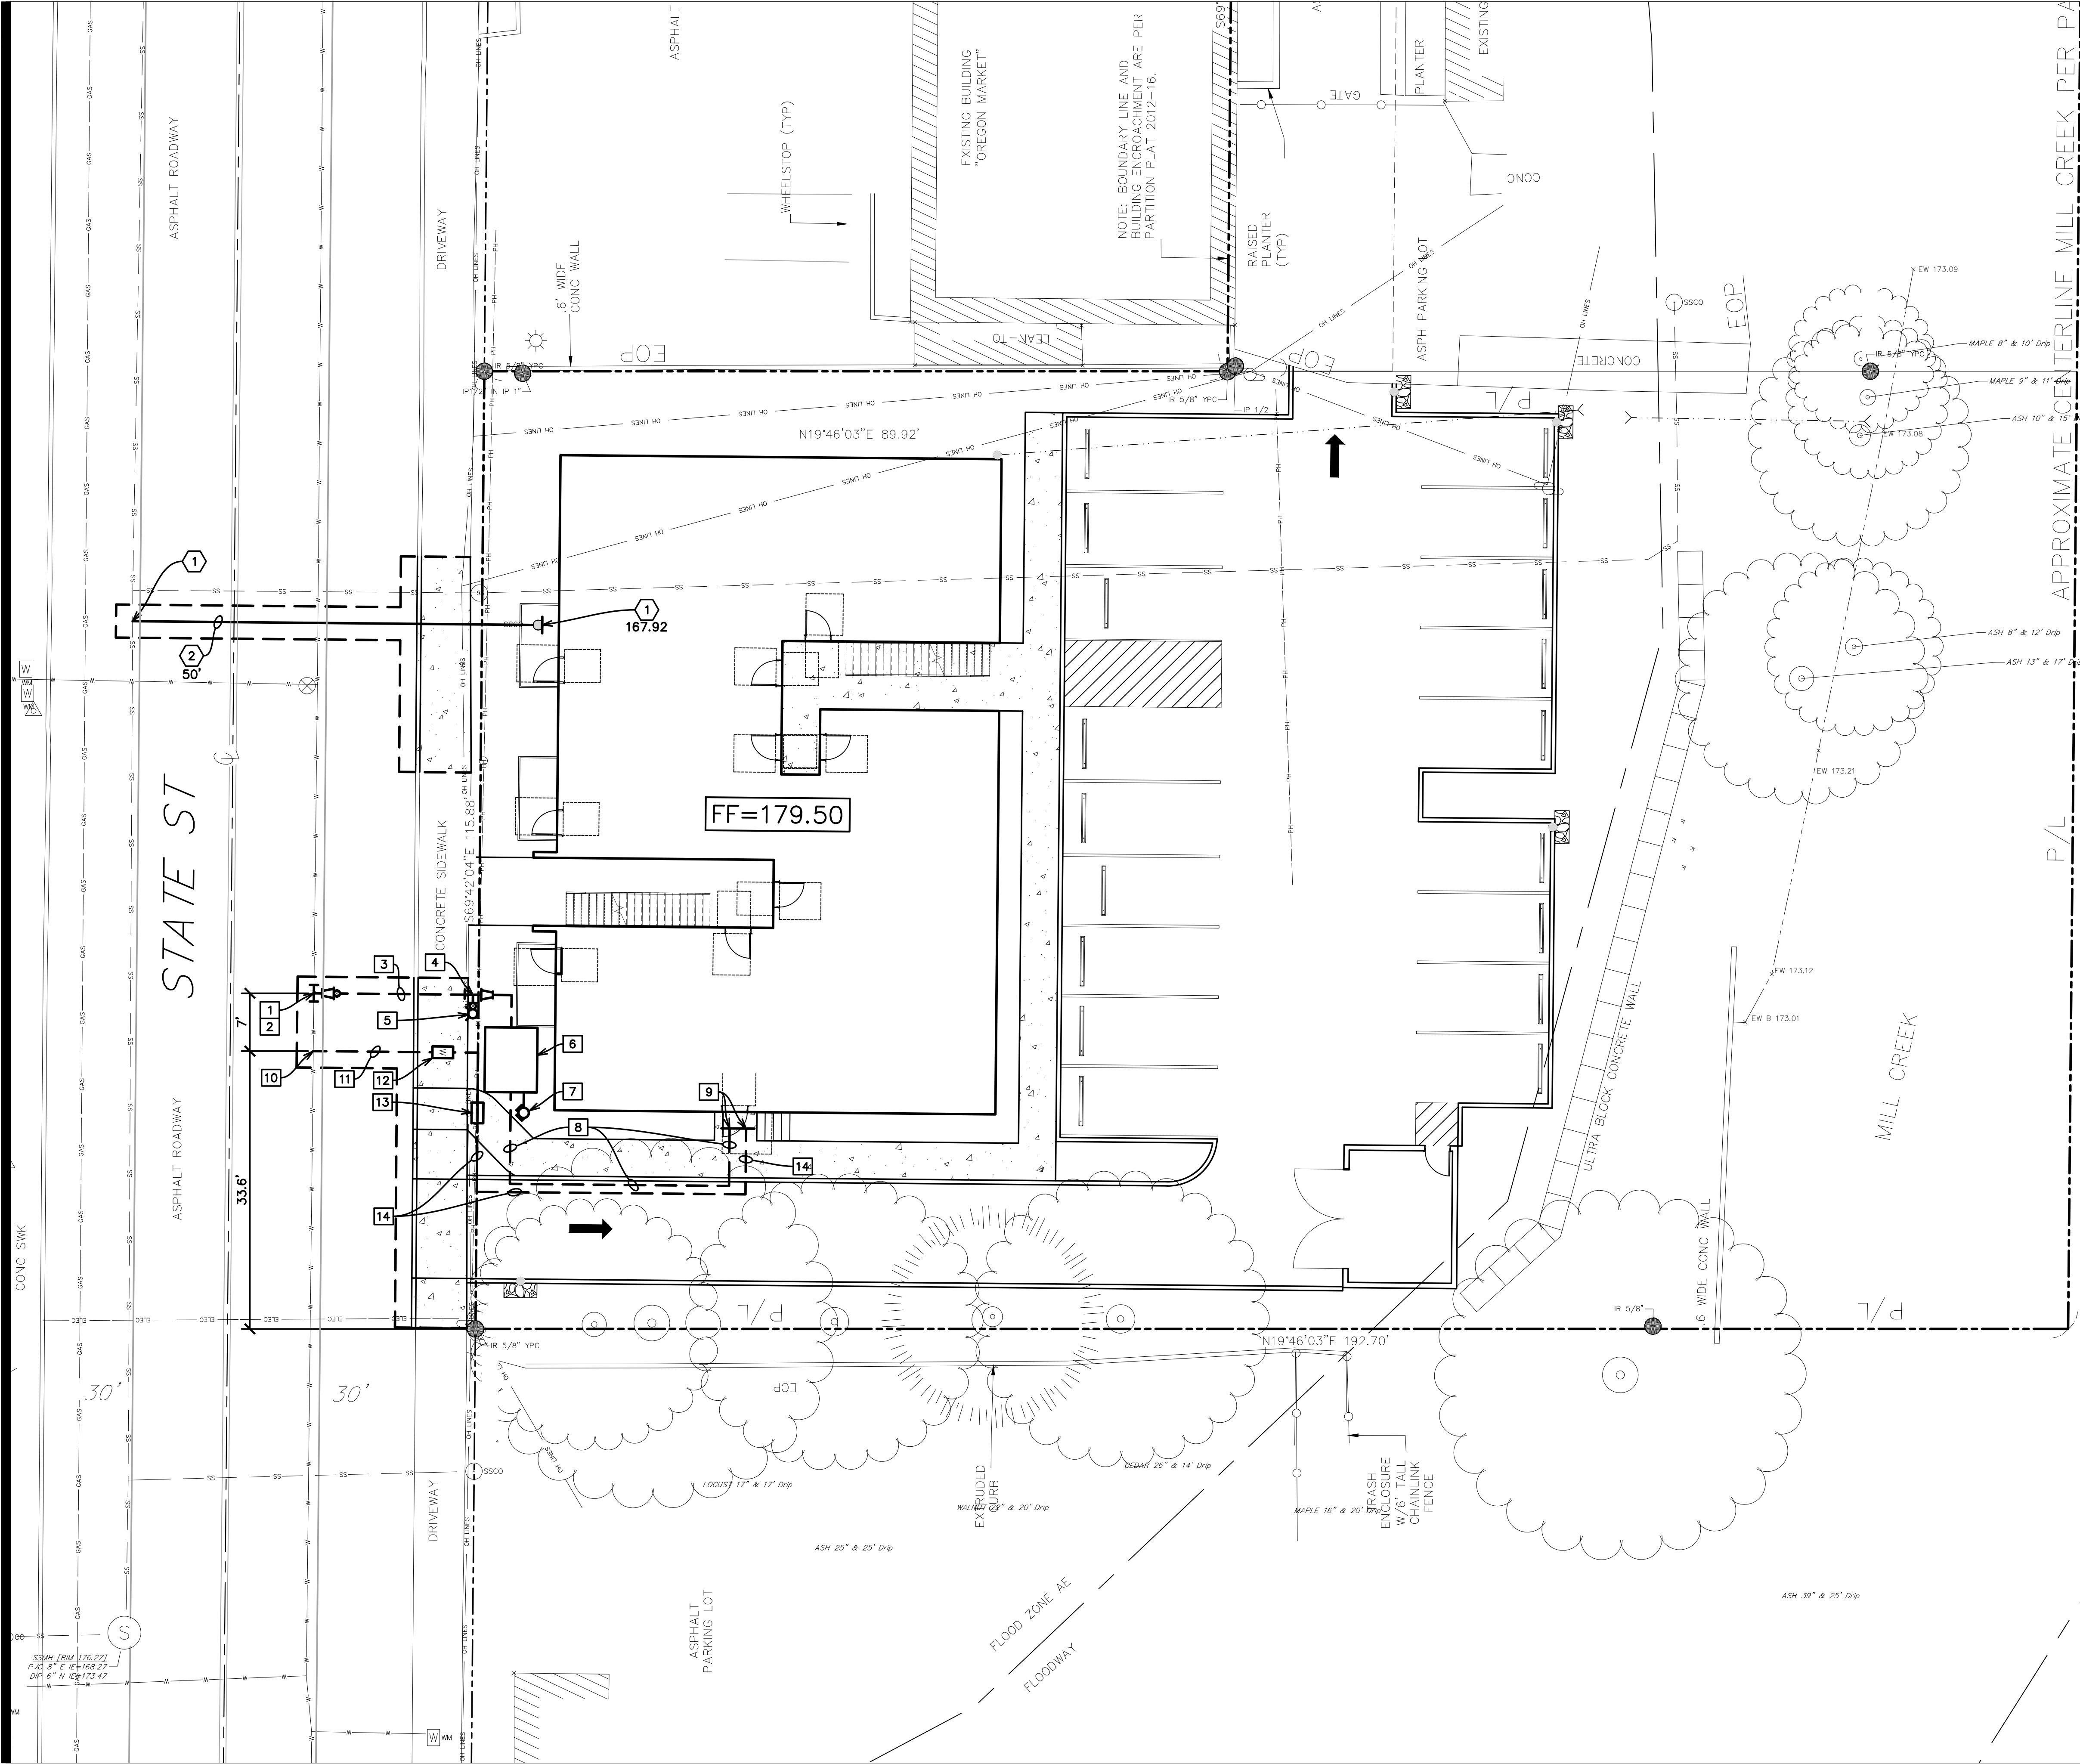

0 5 10 20
(feet)

SANITARY SEWER KEY CALLOUTS	
1	CONTRACTOR TO COORDINATE W/ CITY SHOPS TO TAP EXT'G 8"SS @ IE=167.42±. CONTRACTOR TO PROVIDE TRAFFIC CONTROL, TRENCH EXCAVATION, SHORING, BACKFILL, & SURFACE RESTORATION.
2	6"SS, S=1% MIN, L=SEE PLAN
3	SSCO, IE=SEE PLAN
NOTES	

WATER KEY CALLOUTS	
1	COORDINATE W/ CITY SHOPS TO TAP EXT'G 6"W/L & INSTALL 8" FIRE SERVICE. CONTRACTOR TO PROVIDE TRAFFIC CONTROL, TRENCH EXCAVATION, SHORING, BACKFILL, & SURFACE RESTORATION.
2	6"x6" TAPPING TEE 6"x8" INCREASER (S) 8"GV (S)
3	8"CL52 DI PUBLIC WATER LINE
4	8"x6" TEE FIRE HYDRANT ASSEMBLY (E) 8"x4" REDUCER (S)
5	FIRE HYDRANT
6	4" DCDA W/ FDC, SEE DTL #5541
7	FIRE DEPARTMENT CONNECTION
8	4"C900 FIRE LINE
9	SEE PLUMBING FOR CONTINUATION
10	CONTRACTOR TO COORDINATE W/ CITY SHOPS TO TAP EXT'G 6" WATER MAIN & INSTALL 2" WATER SERVICE. CONTRACTOR TO PROVIDE TRAFFIC CONTROL, EXCAVATION, SHORING, BACKFILL, & SURFACE RESTORATION.
11	2" SERVICE
12	1½" WATER METER
13	2" DOUBLE CHECK ASSEMBLY
14	2"SCH 40 PVC
NOTES	
1.	ALL JOINTS AND FITTINGS TO BE MECHANICALLY RESTRAINED

STUDIO
3
ARCHITECTURE
INCORPORATED
222 COMMERCIAL ST. NE
SALEM, OR 97301-3410
P: 503.390.6500
F: 503.390.6501
www.studio3architecture.com



RENEW: 6/30/2026
IN THE EVENT CONFLICTS ARE DISCOVERED BETWEEN THE ORIGINAL SIGNED AND SEALED DOCUMENTS PREPARED BY THE ARCHITECTS AND/OR THEIR CONSULTANTS, AND ANY COPY OF THE DOCUMENTS TRANSMITTED BY MAIL, FAX, ELECTRONICALLY OR OTHERWISE, THE ORIGINAL SIGNED AND SEALED DOCUMENTS SHALL GOVERN.
PROJECT #3529.0000.0
DATE: 08/24
DRAWN BY: AK
CHECKED BY: JW

REVISIONS:
△
△
△
△
WESTTECH ENGINEERING, INC.
CONSULTING ENGINEERS AND PLANNERS
3841 Fairview Industrial Dr. S.E., Suite 100, Salem, OR 97302
Phone: (503) 585-2474 Fax: (503) 585-3986
E-mail: westtech@westtech-eng.com

SITE IMPROVEMENTS
SALEM, OR 97301
2020 STATE ST

SHEET:
C3.0
UTILITY PLAN