



J:\7707\7707-Baxter\Baxter\Drawings\SDR1.dwg, SDR1, 17/10/2025, 1:14:44 PM, DgnSite

ABBREVIATIONS

A.C.	ASPHALTIC CONCRETE	L	LENGTH, LINE
ACMP	ALUMINIZED CMP	L.P.	LIGHT POLE
ASSY.	ASSEMBLY	M	METER, MAIN
B.O.	BLOW OFF	M.H.	MANHOLE
B.F.V.	BUTTERFLY VALVE	MTL	METAL
C & G	CURB & GUTTER	O.H.	OVERHEAD
CATV	CABLE TELEVISION	PC	POINT OF CURVE
CB	CATCH BASIN	PCC	POINT OF CONTINUING CURVE
C.B.C.O.	CATCH BASIN CLEANOUT	PED.	PEDESTAL
C.B.I.	CATCH BASIN INLET	PRC	POINT OF REVERSE CURVE
CCR	COMPACTED CRUSHED ROCK	PROP.	PROPOSED
C.L.	CENTERLINE	PT	POINT OF TANGENCY
CMP	CORRUGATED METAL PIPE	PUB.	PUBLIC
C.O.	CLEANOUT	PUE	PUBLIC UTILITY EASMT.
CONC.	CONCRETE	PVC	POLYVINYL CHLORIDE
CONST.	CONSTRUCT	PVT.	PRIVATE
D.I.	DUCTILE IRON	P.P.	POWER POLE
DIA.	DIAMETER	P.L.	PROPERTY LINE
DWG	DRAWING	R	RADIUS
EASMT.	EASEMENT	R-	RIM
E.G.	EXIST. GRADE / GROUND	RD	ROOF DRAIN
EOP, E.P.	EDGE OF PAVEMENT	R.O.W.	RIGHT-OF-WAY
ELEC.	ELECTRIC	SAN.S. or S.S.	SANITARY SEWER
ELEV. or EL.	ELEVATION	S	SLOPE
EX. or EXIST.	EXISTING	S.Q.F.	STORMWATER QUALITY FACILITY
F.D.C.	FIRE DEPT. CONNECTION	STA.	STATION
FT.	FEET	STD.	STANDARD
F.F.	FINISH FLOOR	STL.	STEEL
F.G.	FINISH GRADE	STM.DRN. or S.D.	STORM DRAIN
F.H.	FIRE HYDRANT	SVC.	SERVICE
F.M.	FORCE MAIN	SW	SIDEWALK
GUT. or GTR.	GUTTER	T.C.	TOP OF CURB
G.V.	GATE VALVE	TEL	TELEPHONE
IMP.	IMPROVEMENT	TYP.	TYPICAL
INST.	INSERT	U.G.	UNDERGROUND
INV. or I-	INVERT	VL.	VAULT
		W.M.	WATER MAIN

SYMBOLS

EX.	PROP.	EX.	PROP.
	BLOW OFF ASSY.		MANHOLE SAN. SEWER
	CATCH BASIN		MANHOLE STORM DRAIN
	CATCH BASIN CLEANOUT		2' DIA. C.O. / M.H.
	CATCH BASIN CURB INLET		MANHOLE TELEPHONE
	CATV PED. / BOX		MANHOLE WATER
	CLEANOUT		REDUCER / INCREASER
	ELEC. PED. / BOX		TEL. PED. / BOX
	FIRE HYDRANT		TRAFFIC PED. / BOX
	GAS LOCATION MARKER		UTILITY / POWER POLE
	GAS VALVE		WATER METER
	MAIL BOX		WATER VALVE
	CABLE TELEVISION		SANITARY SEWER EXIST.
	CENTERLINE		SANITARY SEWER CONST.
	DITCH C.L.		STORM DRAIN EXIST.
	ELECTRICAL LINE		STORM DRAIN CONST.
	NATURAL GAS LINE		WATER MAIN EXIST.
	TELEPHONE LINE		WATER MAIN CONST.

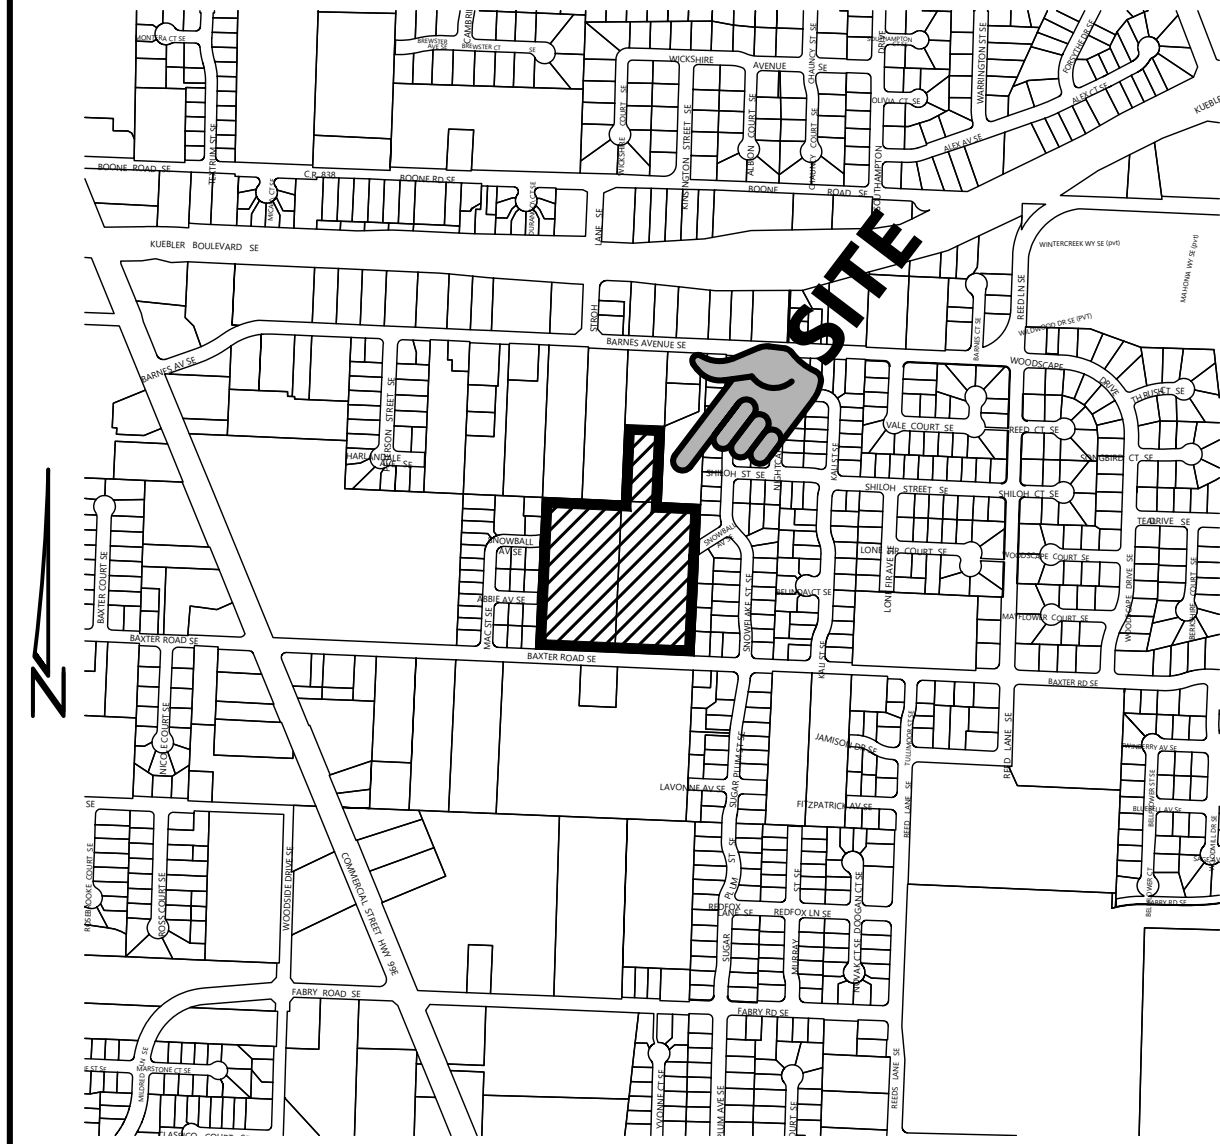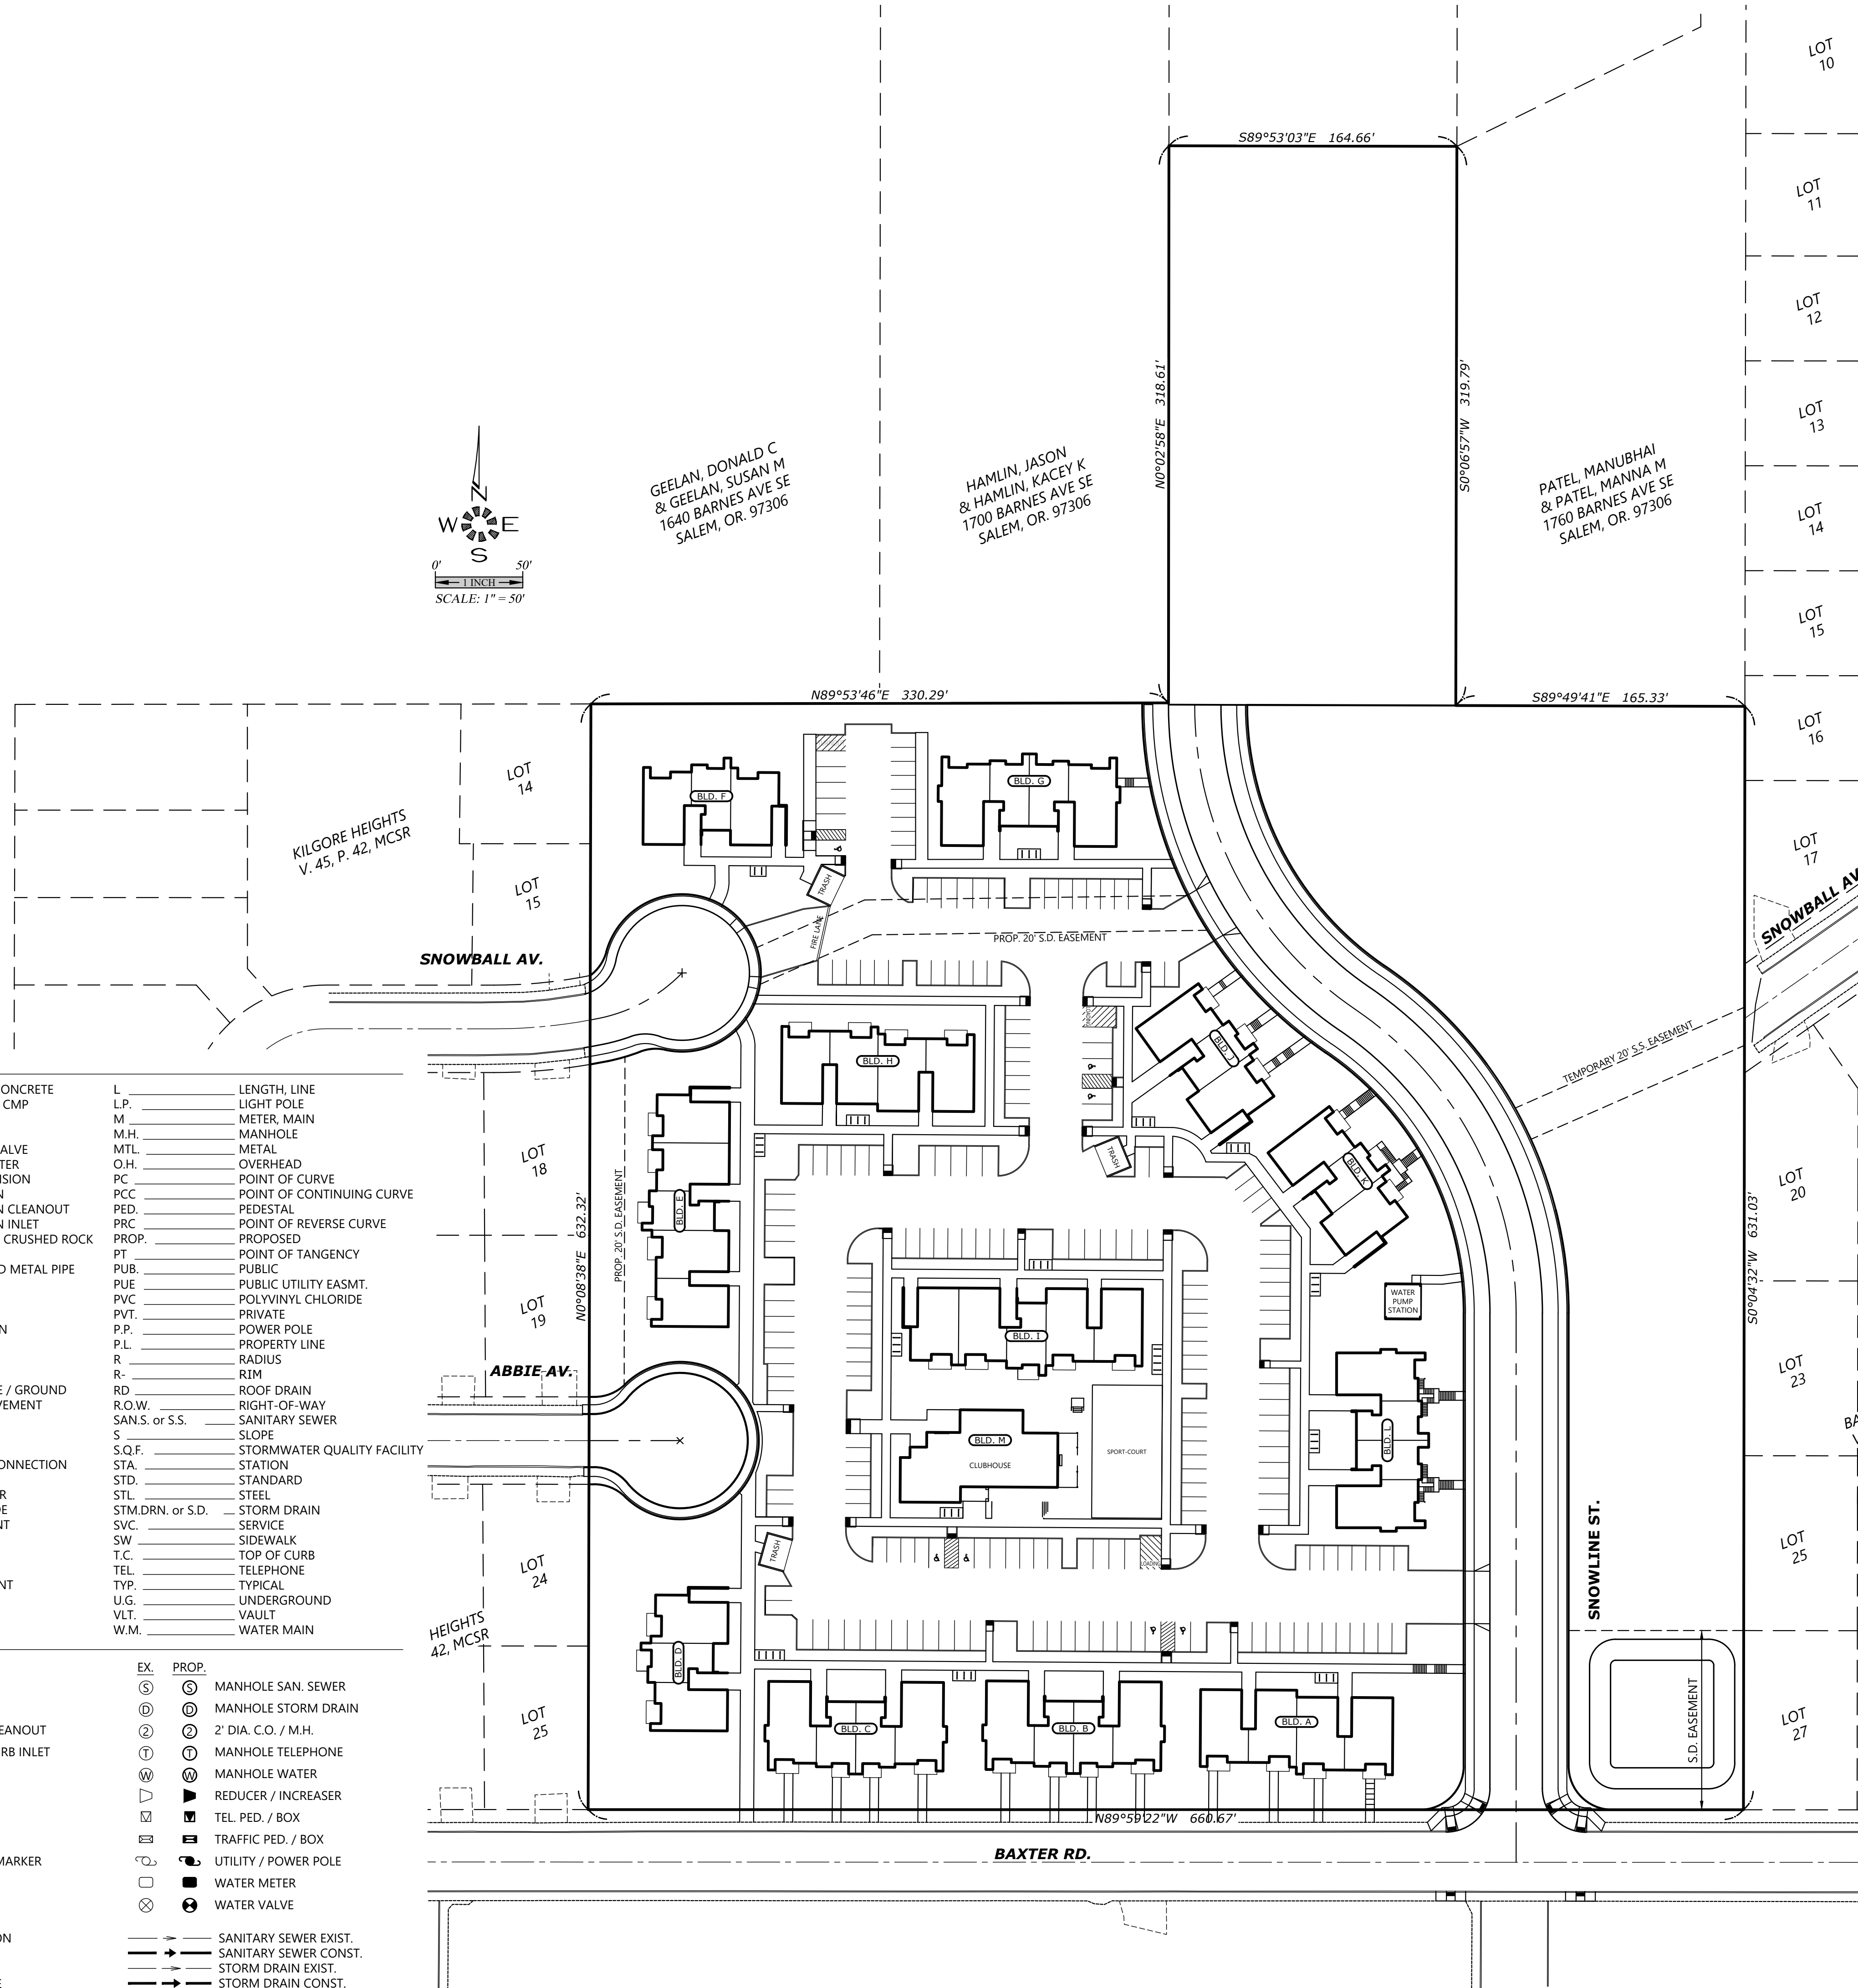

VICINITY MAP

B.M. 406.76
BENCH MARK 8300 - 2" ALUMINUM DISK
IN B.R. OF CURB. NE CORNER INTERSECTION
BAXTER CT. AND BAXTER ROAD, 20' WEST OF
C.B. 37' NE FIRE HYDRANT., 45' E MANHOLE

BAXTER DEVELOPMENT

MULTI-FAMILY HOUSING
SEC. 14, T. 08 S., R. 03 W., W.M.
CITY OF SALEM
MARION COUNTY, OREGON

Owner / Developer:

NEIGHBORLY VENTURES

2925 S RIVER ROAD, STE. 100
SALEM, OR 97302


SHEET INDEX

SDR1	COVER SHEET
SDR2	EXISTING CONDITIONS PLAN
SDR3	SITE PLAN
SDR4	SHADOW PLAN
SDR5	OPEN SPACE PLAN
SDR6	GRADING PLAN
SDR7	PRIVATE STORM DRAIN PLAN
SDR8	PRIVATE SANITARY SEWER PLAN
SDR9	PRIVATE DOMESTIC WATER PLAN
SDR10	PRIVATE FIRE SERVICE PLAN

L0.0	LANDSCAPE COVER SHEET
L1.1	PRELIMINARY PLANT SCHEDULE
L1.2	PRELIMINARY PLANTING PLAN
L1.3	PRELIMINARY PLANTING PLAN
L1.4	TREE CANOPY PLAN

NO CHANGES, MODIFICATIONS
OR REPRODUCTIONS TO BE
MADE TO THESE DRAWINGS
WITHOUT WRITTEN
AUTHORIZATION FROM THE
DESIGN ENGINEER.
DIMENSIONS & NOTES TAKE
PRECEDENCE OVER
GRAPHICAL REPRESENTATION.

Design: M.D.G.
Drawn: J.P.H.
Checked: B.M.G.
Issue Date: 11/14/25
Scale: AS SHOWN

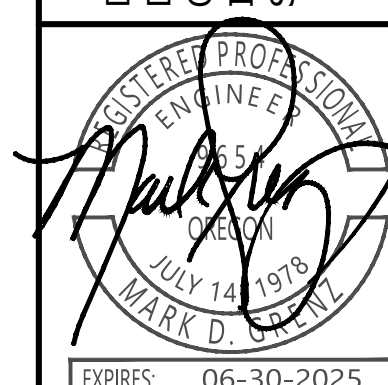

JOB # 7707

SDR1