

 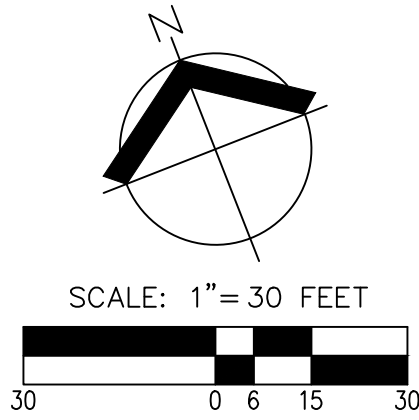


AKS DRAWING FILE: 11513 TENTATIVE REPLATING LAYOUT: LAYOUT1

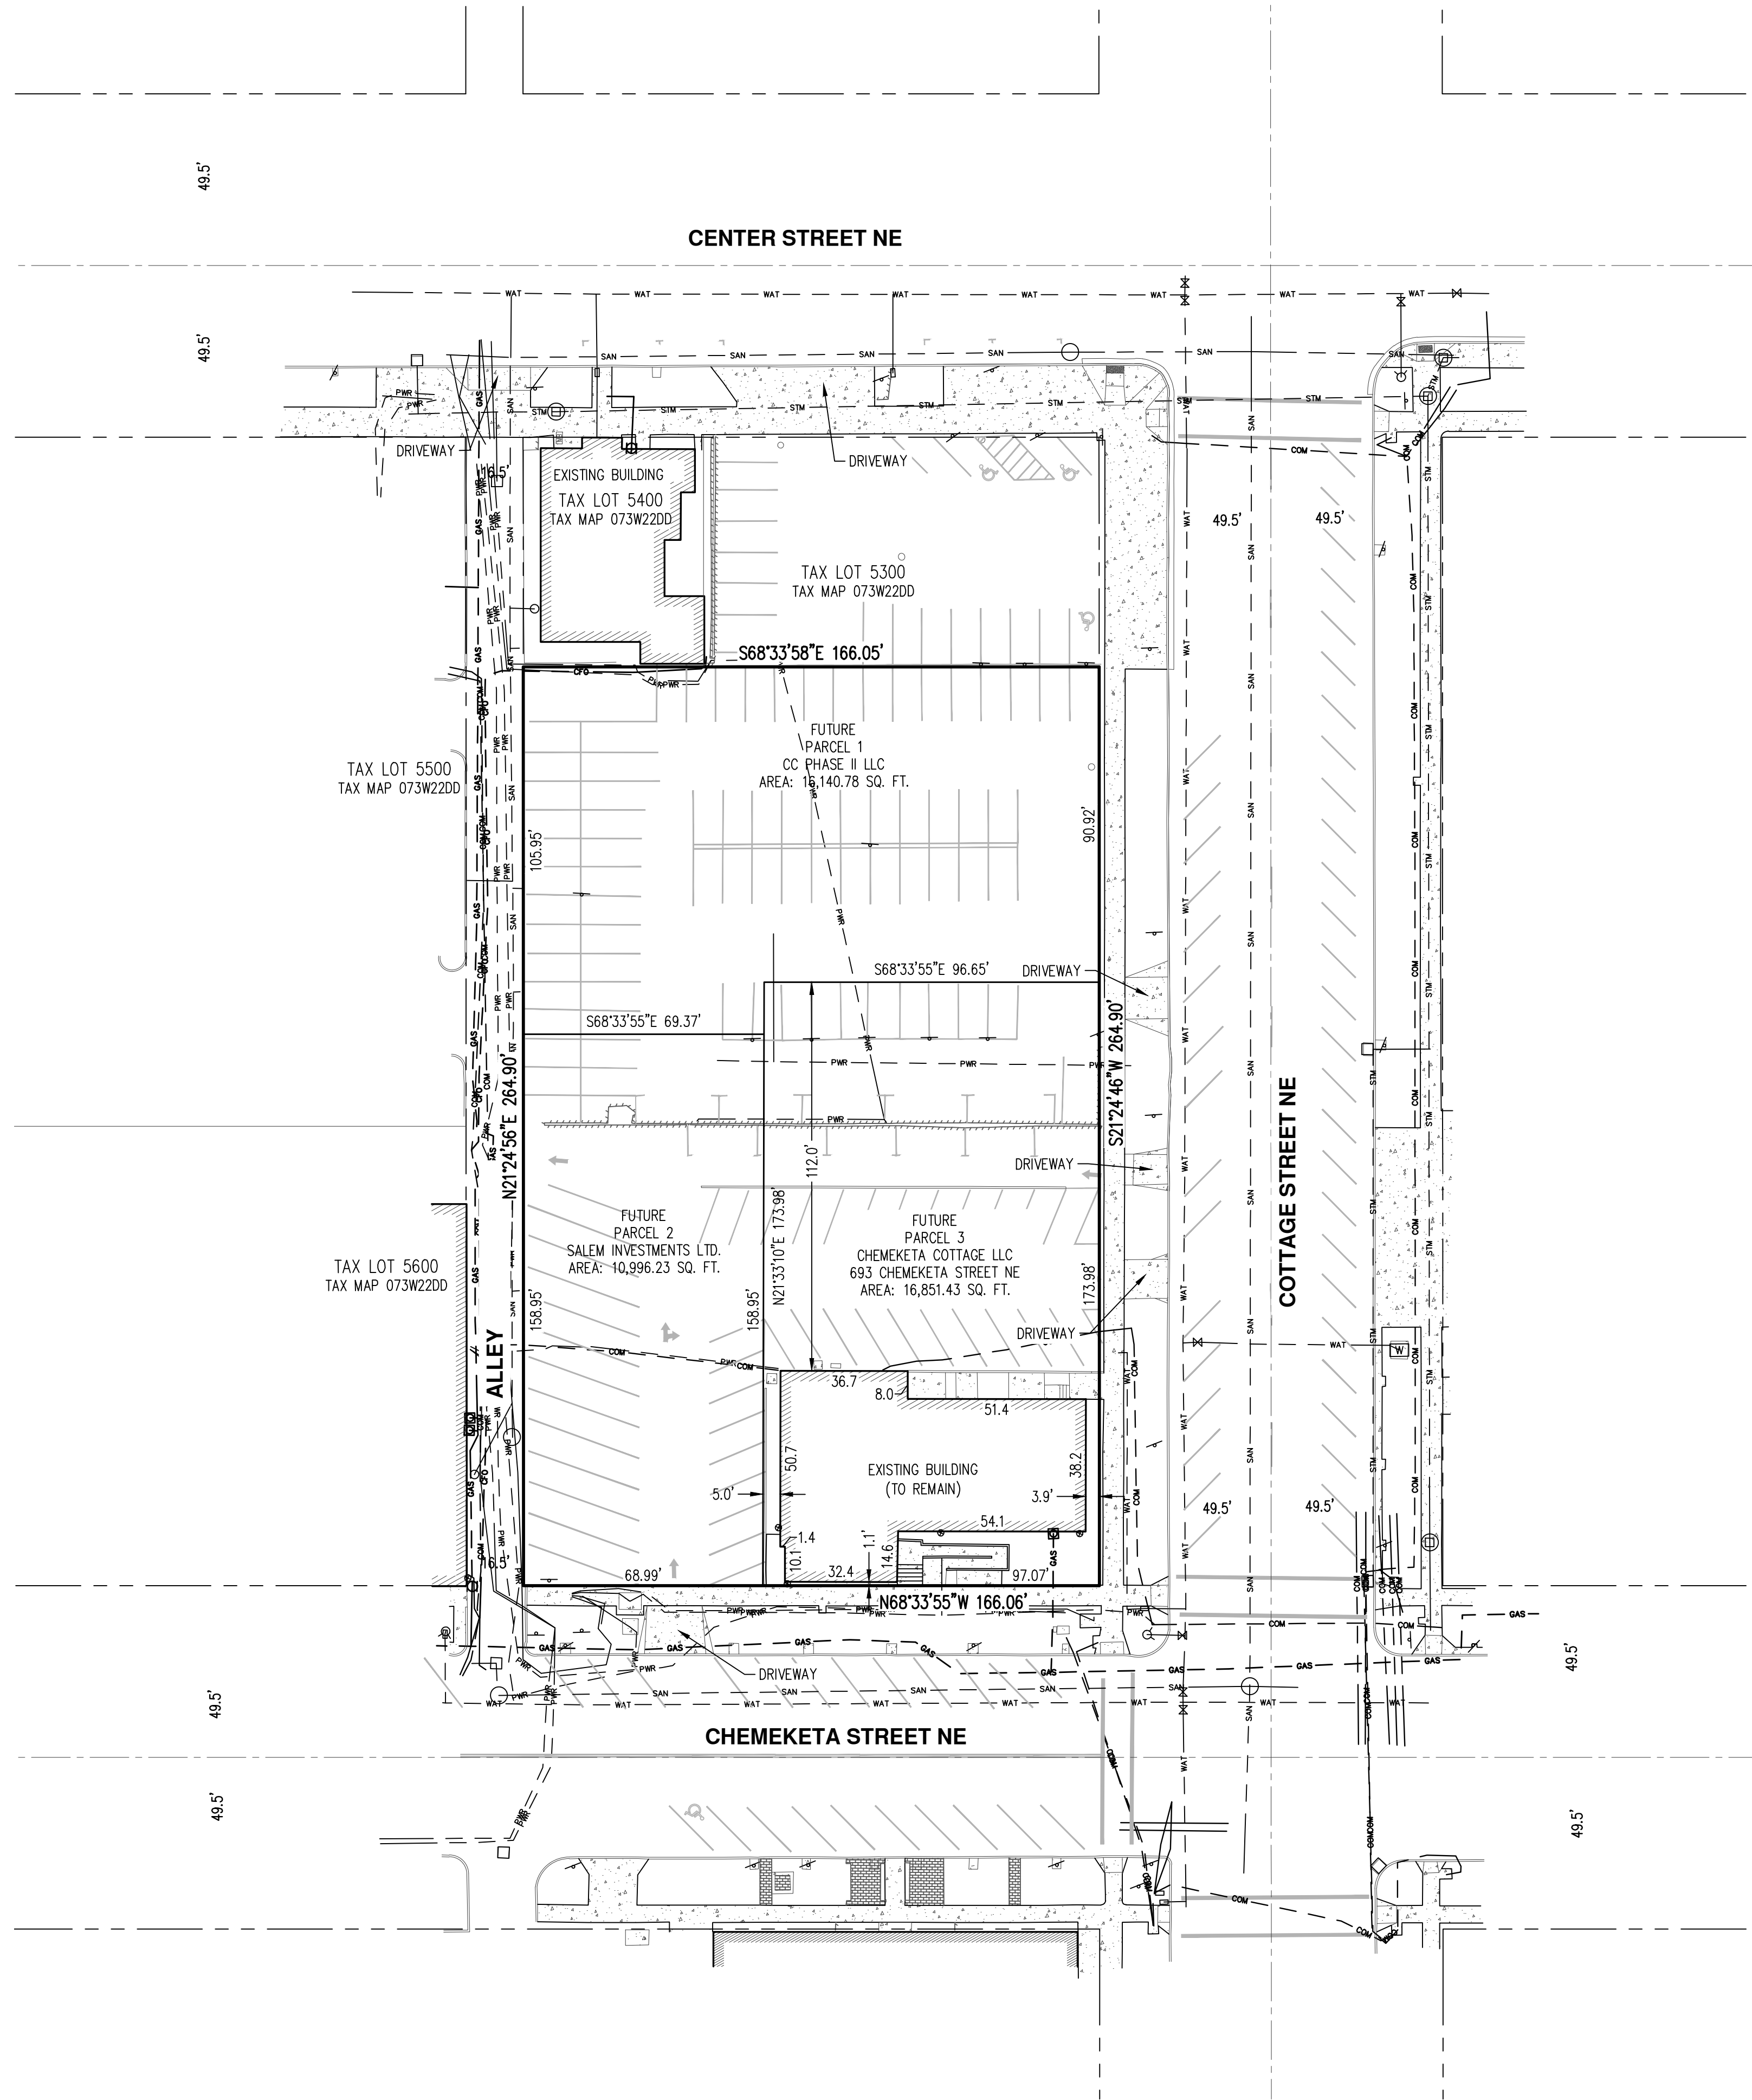

 
- DECIDUOUS TREE
CONIFEROUS TREE
FIRE HYDRANT
WATER BLOWOFF
WATER METER
WATER VALVE
DOUBLE CHECK VALVE
AIR RELEASE VALVE
SANITARY SEWER CLEAN OUT
SANITARY SEWER MANHOLE
SIGN
STREET LIGHT
MAILBOX

EXISTING




- STORM DRAIN CLEAN OUT
STORM DRAIN CATCH BASIN
STORM DRAIN AREA DRAIN
STORM DRAIN MANHOLE
GAS METER
GAS VALVE
GUY WIRE ANCHOR
UTILITY POLE
POWER VAULT
POWER JUNCTION BOX
POWER PEDESTAL
COMMUNICATIONS VAULT
COMMUNICATIONS JUNCTION BOX
COMMUNICATIONS RISER

EXISTING



EXISTING

- RIGHT-OF-WAY LINE
BOUNDARY LINE
PROPERTY LINE
CENTERLINE
DITCH
CURB
EDGE OF PAVEMENT
EASEMENT
FENCE LINE
GRAVEL EDGE
POWER LINE
OVERHEAD WIRE
COMMUNICATIONS LINE
FIBER OPTIC LINE
GAS LINE
STORM DRAIN LINE
SANITARY SEWER LINE
WATER LINE
RECLAIMED WATER LINE

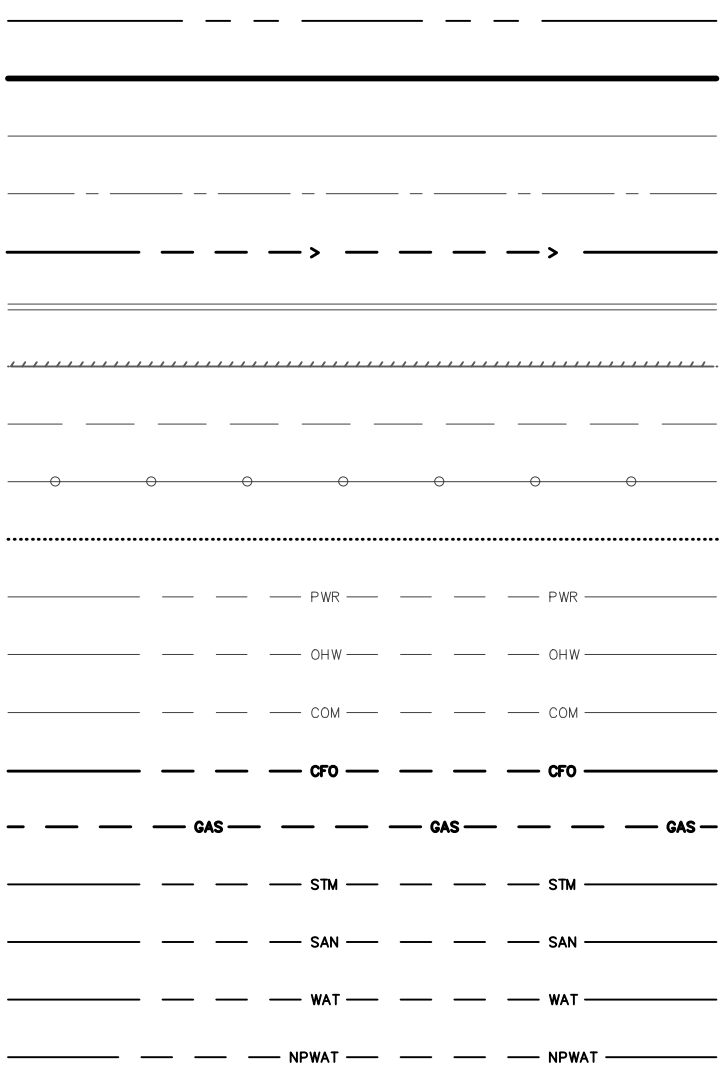

693 CHEMEKETA STREET NE

SALEM OREGON
TAX LOTS 4900, 5000, 5100 AND 5200
MARION COUNTY TAX MAP 073W22D0

TENTATIVE REPLAT

DESIGNED BY:
DRAWN BY: MEB
MANAGED BY:
CHECKED BY: RDR
DATE: 3/13/2025
REGISTERED PROFESSIONAL LAND SURVEYOR
MICHAEL T. BUTZ
95518PLS
RENEWS: 12/31/25
REVISIONS:

JOB NUMBER
11513
SHEET
EX B

AKS ENGINEERING & FORESTRY, LLC
1206 SE SW HERMAN RD., STE 100
TUALATIN, OR 97062
503.563.6151
WWW.AKS-ENG.COM
ENGINEERING · SURVEYING · NATURAL RESOURCES
FORESTRY · PLANNING · LANDSCAPE ARCHITECTURE