


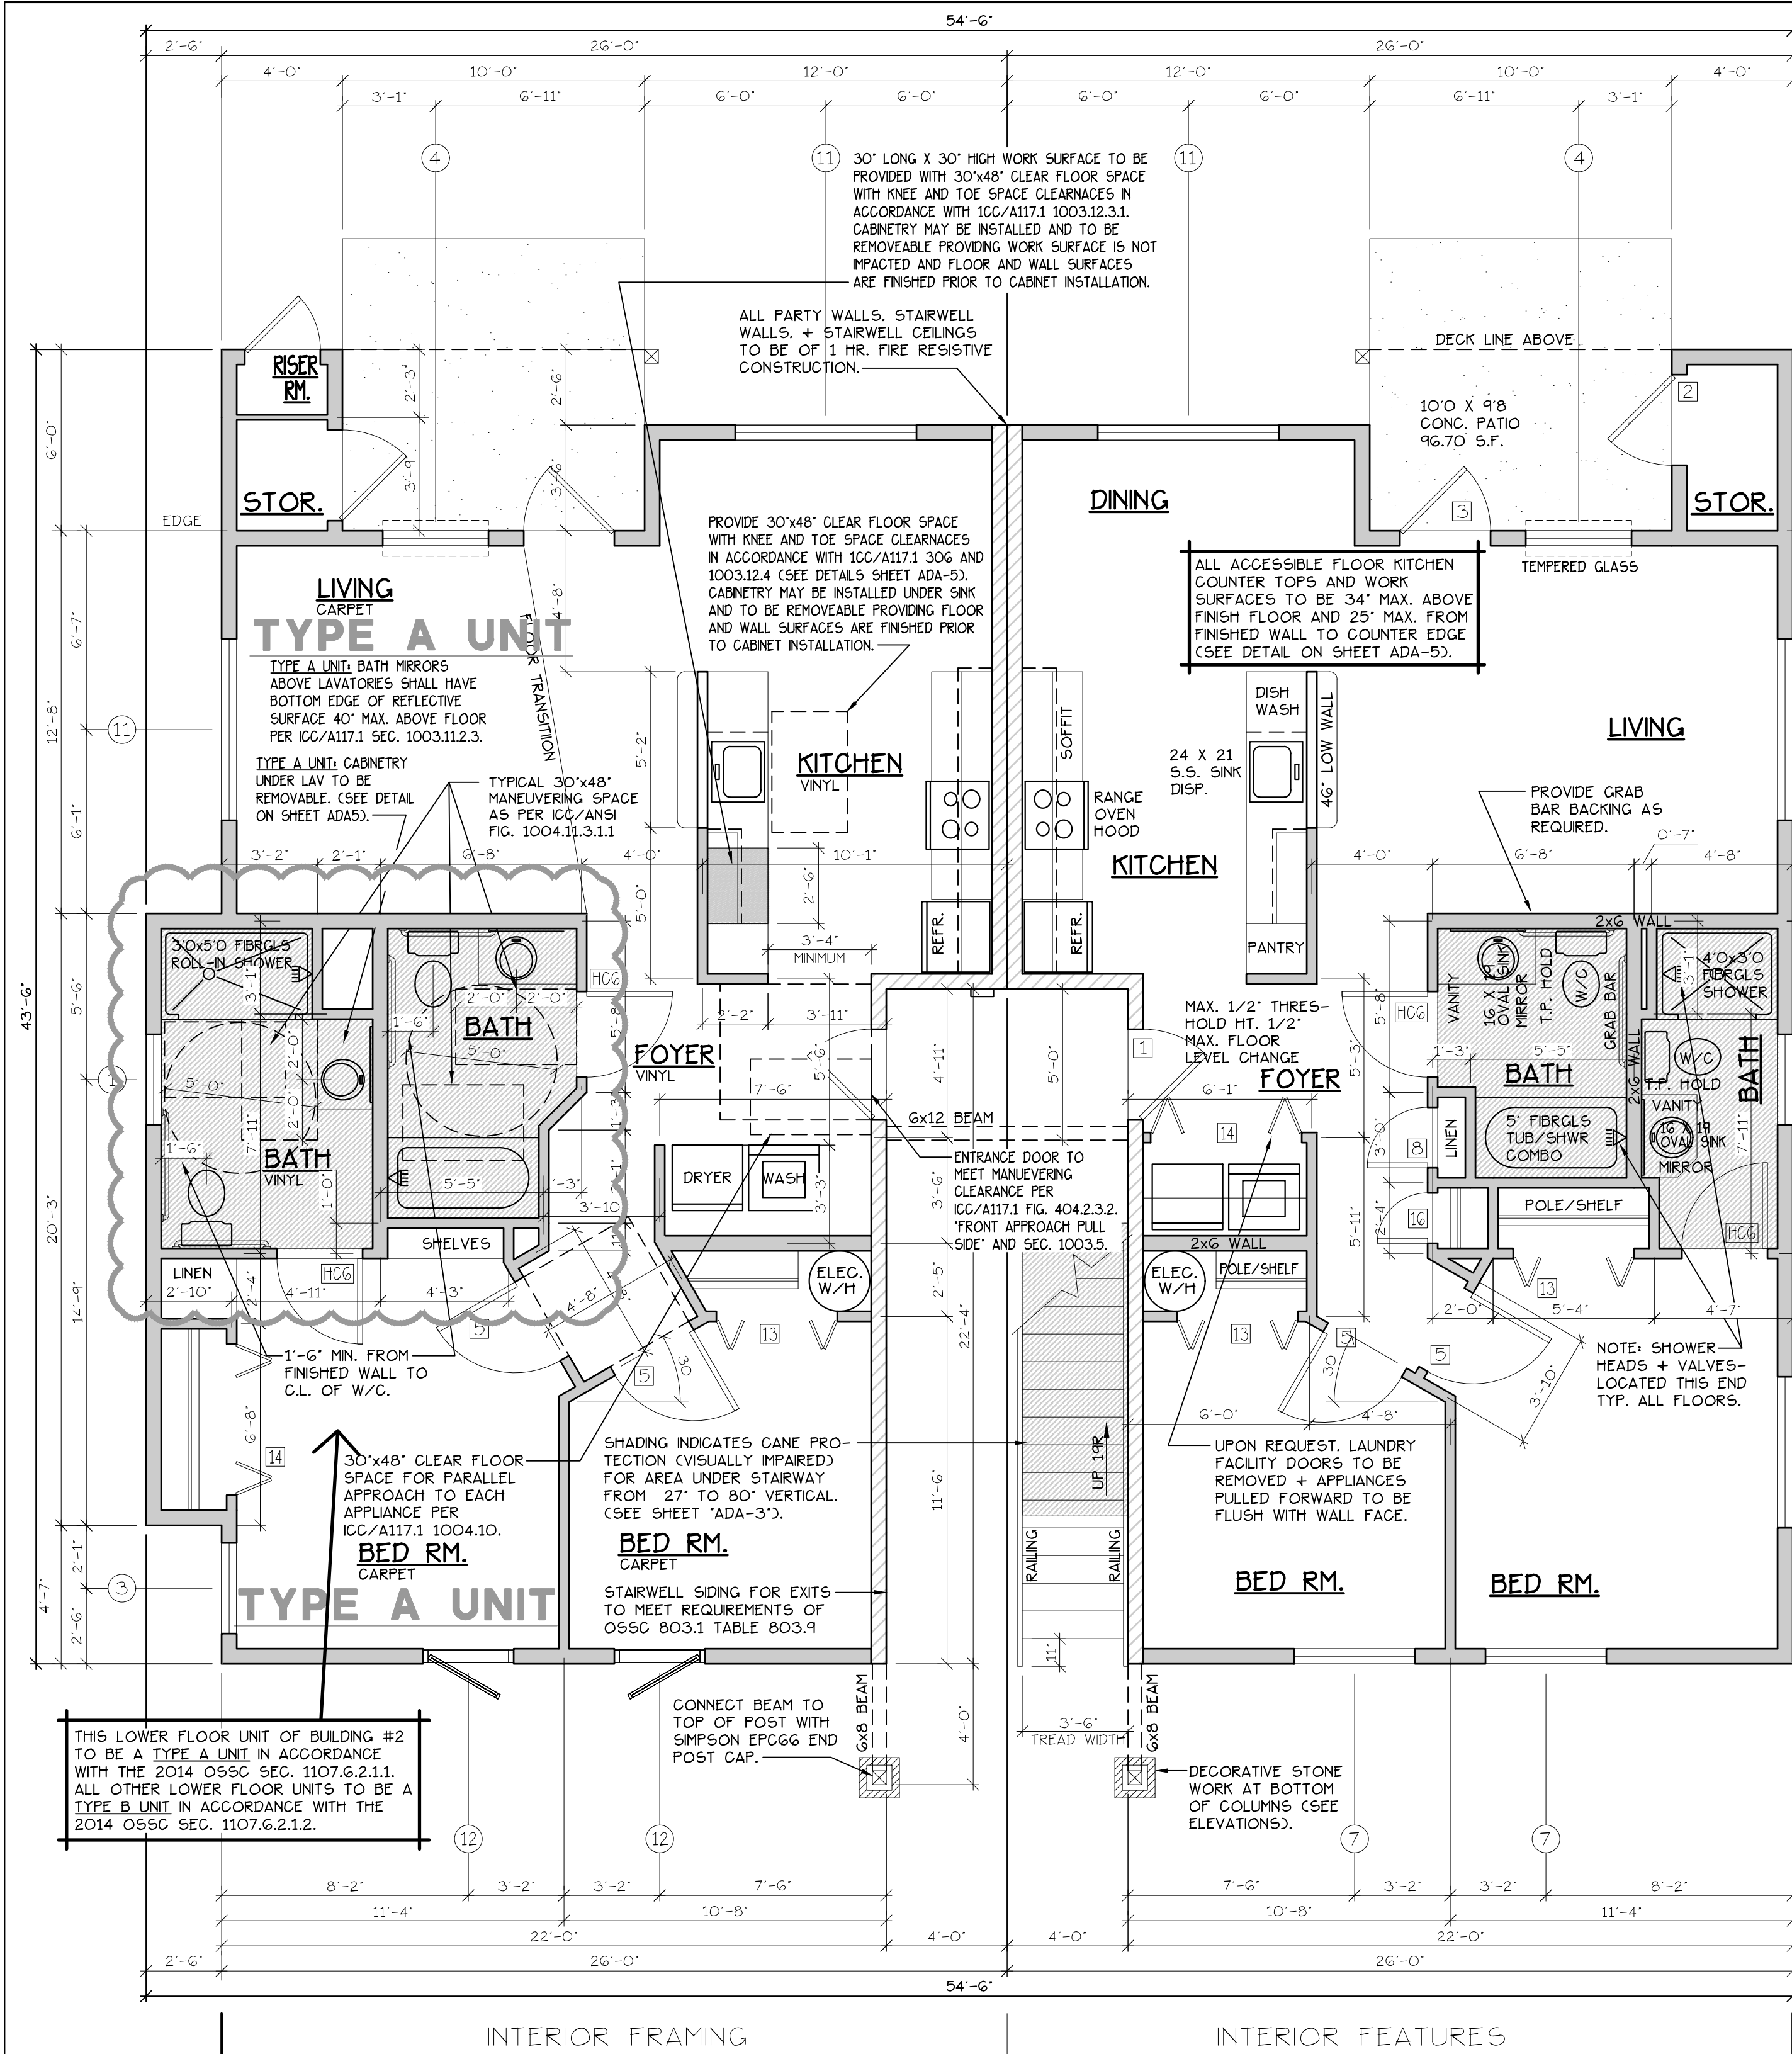

LOWER FLOOR PLAN (HANDICAP ADAPTABLE/ACCESSIBLE) "A" UNIT = 952 S.F.

TYPE A UNITS

BLD. 4

CONSTRUCTION TYPE V.B. SPRINKLED
SEE WALL DETAIL SHEETS FOR
SHEETROCK APPLICATION.


IF 707.2.10.3 SMOKE ALARMS, SINGLE AND MULTIPLE-STATION SMOKE ALARMS SHALL BE INSTALLED IN ACCORDANCE WITH SECTION 907.2.11.
IF 707.2.11 SINGLE AND MULTIPLE-STATION SMOKE ALARMS, LISTED SINGLE AND MULTIPLE-STATION SMOKE ALARMS COMPLYING WITH UL 217 SHALL BE INSTALLED IN ACCORDANCE WITH SECTIONS 907.2.11.1 THROUGH 907.2.11.4 AND NFPA 72.

DOOR SCHEDULE									
DOORS				FRAMES		REMARKS			
#	WIDTH	HEIGHT	THICK	TYP.	MATL.	FIN.	TYP.	MATL.	FIN.
1	3'-0"	6'-8"	1-3/4"	MTL.	GLAD	PANT	A	METAL	PAINT
2	3'-0"	6'-8"	1-3/4"	MTL.	GLAD	PANT	B	METAL	PAINT
3	3'-0"	6'-8"	1-3/4"	MTL.	GLAD	PANT	C	METAL	PAINT
4	2'-6"	6'-8"	1-3/4"	MTL.	GLAD	PANT	D	METAL	PAINT
5	3'-0"	6'-8"	1-3/8"	H.G.	BRCH	STAIN	E	HEMLOCK	STAIN
6	2'-10"	6'-8"	1-3/8"	H.G.	BRCH	STAIN	F	HEMLOCK	STAIN
7	2'-10"	6'-8"	1-3/8"	H.G.	BRCH	STAIN	F	HEMLOCK	STAIN
8	2'-10"	6'-8"	1-3/8"	H.G.	BRCH	STAIN	F	HEMLOCK	STAIN
9	4'-0"	6'-8"	1-3/8"	H.G.	BRCH	STAIN	F	HEMLOCK	STAIN
10	4'-0"	6'-8"	1-3/8"	H.G.	BRCH	STAIN	F	HEMLOCK	STAIN
11	5'-8"	6'-8"	1-3/8"	H.G.	BRCH	STAIN	F	HEMLOCK	STAIN
12	6'-0"	6'-8"	1-3/8"	H.G.	BRCH	STAIN	F	HEMLOCK	STAIN
13	4'-0"	6'-8"	1-3/8"	H.G.	BRCH	STAIN	F	HEMLOCK	STAIN
14	5'-0"	6'-8"	1-3/8"	H.G.	BRCH	STAIN	F	HEMLOCK	STAIN
15	6'-0"	6'-8"	1-3/8"	H.G.	BRCH	STAIN	F	HEMLOCK	STAIN
16	1'-8"	6'-8"	1-3/8"	H.G.	BRCH	STAIN	F	HEMLOCK	STAIN

* ACCESSIBLE POCKET DOORS MUST STOP FULLY OPEN WITH THEIR OPERATING HANDLES FULLY EXPOSED.
** TO PROVIDE MINIMUM 32" NET CLEAR WIDTH PER ICC/A117.1 SEC. 1004.5.2.1 WHEN FULLY OPENED.

WINDOW SCHEDULE									
#	SIZE	TYPE	MFG.	COLOR	INSUL.	REMARKS	HEADERS		
1	3'-0" X 1'-0"	VNTL STAT.	MILGARD	WHITE	YES	STATIONARY W/ FROSTED GLASS	DF #1 4x12		
2	3'-0" X 1'-0"	VNTL STAT.	MILGARD	WHITE	YES	STATIONARY W/ FROSTED GLASS	DF #1 4x12		
3	3'-0" X 4'-0"	VNTL SGL.	MILGARD	WHITE	YES	SINGLE HUNG W/ SCREEN	DF #1 4x12		
4	3'-6" X 4'-0"	VNTL SLD.	MILGARD	WHITE	YES	HORIZ. SLIDER W/ SCREEN	DF #1 4x12		
5	4'-0" X 3'-0"	VNTL SLD.	MILGARD	WHITE	YES	HORIZ. SLIDER W/ SCREEN	DF #1 4x12		
6	4'-0" X 4'-0"	VNTL SLD.	MILGARD	WHITE	YES	HORIZ. SLIDER W/ SCREEN	DF #1 4x12		
7	4'-0" X 5'-0"	VNTL SLD.	MILGARD	WHITE	YES	HORIZ. SLIDER W/ SCREEN	DF#1 6x8 (SEE ALT. HEADER DETAIL SHT. A15.40)		
8	5'-0" X 2'-0"	VNTL SLD.	MILGARD	WHITE	YES	HORIZ. SLIDER W/ SCREEN	DF #1 4x12		
9	5'-0" X 4'-0"	VNTL SLD.	MILGARD	WHITE	YES	HORIZ. SLIDER W/ SCREEN	DF #1 4x12		
10	5'-0" X 5'-0"	VNTL SLD.	MILGARD	WHITE	YES	HORIZ. SLIDER W/ SCREEN	DF#1 6x8 (SEE ALT. HEADER DETAIL SHT. A15.40)		
11	6'-0" X 4'-0"	VNTL SLD.	MILGARD	WHITE	YES	HORIZ. SLIDER W/ SCREEN	DF #1 4x12		
12	4'-0" X 5'-0"	CASEMENT	MILGARD	WHITE	YES	CASEMENT W/ SCREEN	DF #1 4x12		

NOTE: ALL LOWER FLOOR OPERABLE WINDOWS + HARDWARE TO COMPLY WITH O.S.S.C. 2014 CHAPTER 11 SEC. 1107.2 ON TO ICC/ANSI A117.1 THEN SEC. 1002.9. OPERABLE PARTS SHALL COMPLY WITH SEC. 309. SEE "OPERABLE WINDOWS IN ACCESSIBLE LOCATIONS" DETAIL ON SHEET ADA-5. ALL LOWER FLOOR WINDOW HEADERS TO BE SET MIN. 7'-0" A.F.F. UNO.

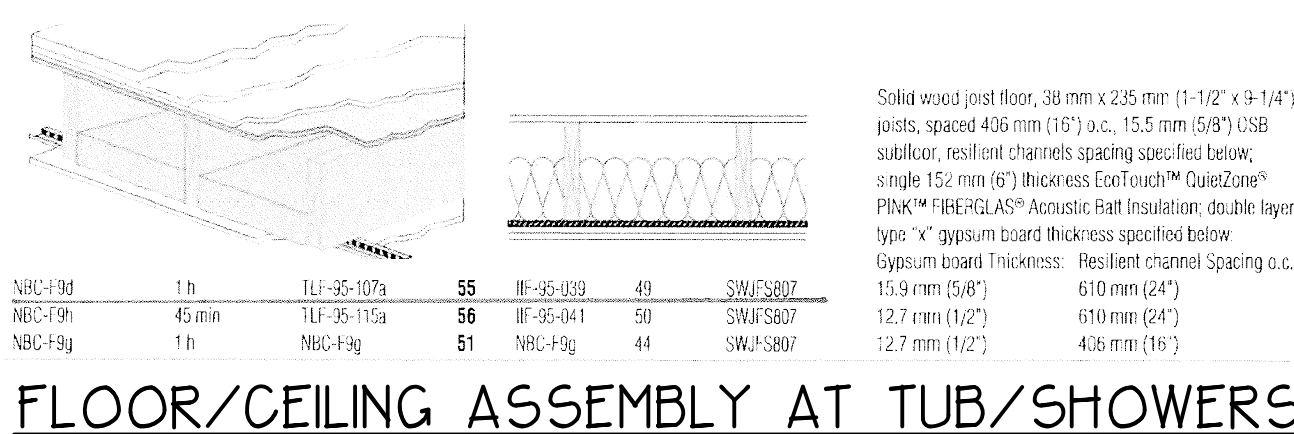


NOTE: ALL ACCESSIBLE DOORS SHALL BE PROVIDED WITH LEVER DOOR HARDWARE + OTHER OPERATING DEVICES IN COMPLIANCE WITH ICC/ANSI A117.1 SECTIONS 309.4 + 404.2.6.

NOTE: MAX. U-VALUE FOR ALL WINDOWS AS PER TABLE 401.1(2) OESG U-0.32.

NOTE: WINDOW SILLS MORE THAN 72" ABOVE FINISH GRADE SHALL BE A MINIMUM OF 36" ABOVE FINISH FLOOR SURFACE (OR) BE INSTALLED WITH WINDOW OPENING CONTROL DEVICES IN COMPLIANCE WITH THE 2014 OESG SECTIONS 1013.8.1 AND 1029.4.

NOTE: FOR WINDOW PLACEMENT SEE "WINDOW PLACEMENT FOR EGRESS AND FALL PROTECTION" DETAIL ON SHEET A15.40.

CONSTRUCTION TYPE V.B. SPRINKLED.

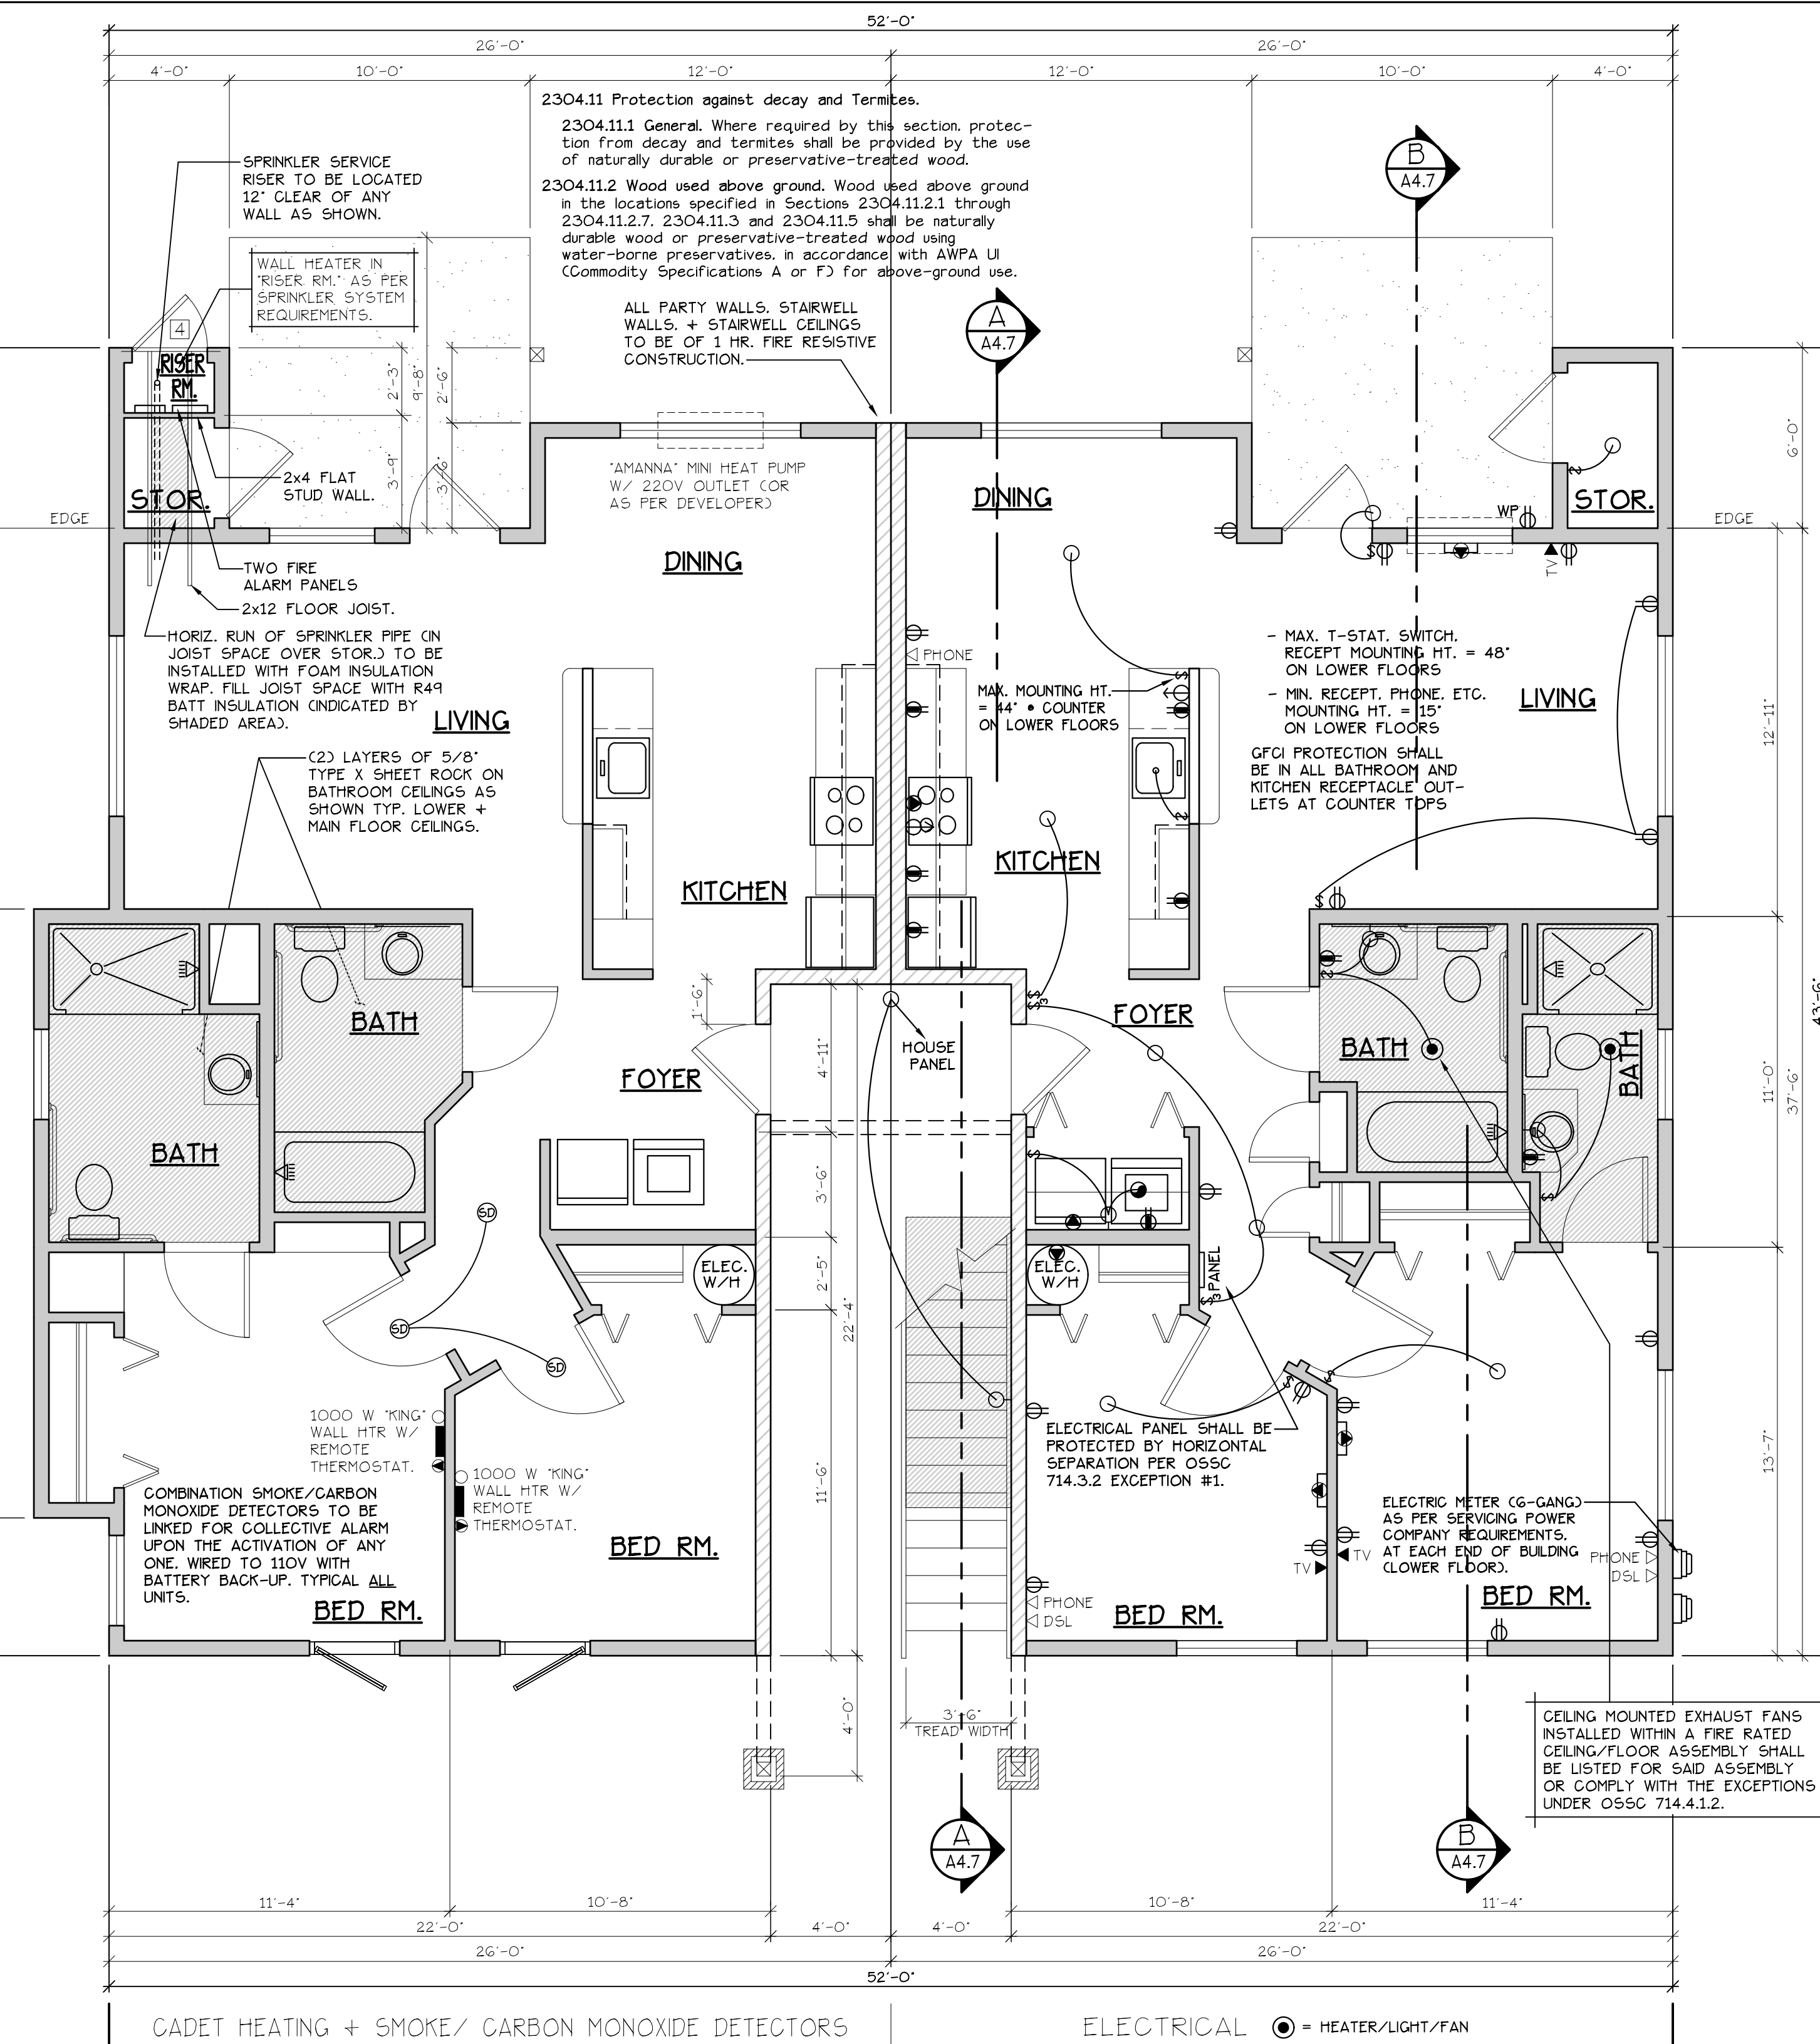

- GENERAL NOTES:**
- ALL EXTERIOR WALLS TO BE 2 X 6 STUDS. ALL OTHER WALLS TO BE 2 X 4 STUDS UNLESS OTHERWISE NOTED.
 - FIRE BLOCK CONCEALED SPACES (VERTICAL + HORIZONTAL) AS PER OESG 718.2.2 AND OESG 718.2.3.
 - PRIOR TO INSTALLATION OF FIBERGLASS TUB/SHOWER + SHOWER UNITS, SHEET ROCK SHALL BE APPLIED TO STUD WALLS AS INDICATED ON PLANS.
 - ALL BATH FANS TO HAVE MIN. 80 CFM. RANGE HOOD EXHAUST FANS TO HAVE MIN. 150 CFM.
 - ELECTRIC OUTLETS IN 1 HR. WALL MAY NOT BE BACK TO BACK AND MUST BE SEPARATED BY HORIZONTAL DISTANCE OF 2'-0".
 - ALL EXTERIOR FLOOD LIGHTING SHALL BE CONNECTED TO HOUSE PANELS LOCATED IN ON-SITE UTILITY ROOMS + STORAGE BLD'S.
 - AS PER OESG HIGH-EFFICIENCY LIGHTING SYSTEMS - A MINIMUM OF 50 PERCENT OF THE LAMPS IN PERMANENTLY INSTALLED LIGHTING FIXTURES SHALL BE COMPACT OR LINEAR FLUORESCENT, OR A LIGHTING SOURCE THAT HAS A MINIMUM EFFICACY OF 40 LUMENS PER INPUT WATT.
 - ALL TYPE "A" ACCESSIBLE UNITS REQUIRE THE PATIO TO BE AT SAME LEVEL AS DWELLING UNIT.

SEE "GENERAL STRUCTURAL NOTES" ON SHEET A4.2 BEFORE BEGINNING ANY CONSTRUCTION.

HANDICAP UNIT NOTES:

THE UNITS HAVE BEEN DESIGNED TO COMPLY WITH OESG 2014 REVISED TO BE EFFECTIVE APRIL 1, 2014. CHAPTER 11 OF THE OESG 2014 AS REVISED INCORPORATES AS PART OF IT, AMERICAN NATIONAL STANDARD ICC/ANSI A117.1-1003, WITHIN ICC/ANSI A117.1, CHAPTER 10 SETS OUT SPECIFIC CODE REQUIREMENTS FOR DWELLING AND SLEEPING UNITS. CHAPTER 10 SETS OUT THE CODE REQUIREMENTS THAT ALL GROUND FLOOR UNITS MUST MEET.

THE INTENT IS THAT "ALL" GROUND FLOOR UNITS ARE TO BE DESIGNED AND CONSTRUCTED IN ACCORDANCE WITH THE PROVISIONS OF THIS CODE.

WITHIN THE PROJECT THERE ARE ALSO TYPE "B" UNITS WHICH MUST MEET SPECIFIC REQUIREMENTS SET OUT IN ICC/ANSI A117.1, CHAPTER 10, SECTION 1004. ALL ACCESSIBLE FLOOR UNITS WITHIN THIS PROJECT ARE TO BE TYPE "B" UNITS UNLESS SPECIFICALLY DESIGNATED TYPE "A" UNITS. WITHIN THESE TYPE "B" UNITS THE MAIN BATHROOM (OR ONLY BATHROOM) SHALL BE DESIGNATED AS AN OPTION "B" ADAPTABLE BATHROOM WHICH MUST MEET THE REQUIREMENTS OF ICC/ANSI A117.1 SECTION 1004.11.3.2.

ATTACHED TO THE DRAWING SETS ARE OUR SHEETS ADA-1 THRU 5 THAT SET OUT SPECIFIC INFORMATION FROM OESG 2014, CHAPTER 10 AS WELL AS THE REFERENCED DOCUMENTS. THE DRAWINGS SET OUT SPECIFIC MINIMUM ELEMENTS AND DIMENSIONS THAT MUST BE MET TO ASSURE COMPLIANCE WITH THIS CODE.

MULTI / TECH

CONSULTANTS

ENGINEERING SERVICES, INC.

1105 13th ST. S.E. SALEM, OR 97302

PHONE: (503) 343 - 9227 • FAX: (503) 844-1260

www.multitech.us office@multitech.us

MARKET STREET

APARTMENT COMPLEX

NO CHANGES, MODIFICATIONS OR REVISIONS TO BE MADE TO THIS DRAWING WITHOUT THE AUTHORIZATION FROM THE DESIGN ENGINEER.

Design: P.L.M.

Drawn: G.L.D.

Checked: M.D.G.

Date: Jul-19

Scale: AS SHOWN

JOB # 6847

REGISTERED PROFESSIONAL ENGINEER

MARK D. GREGG

July 14, 1978

Renew date: June 30, 2021

A4.31