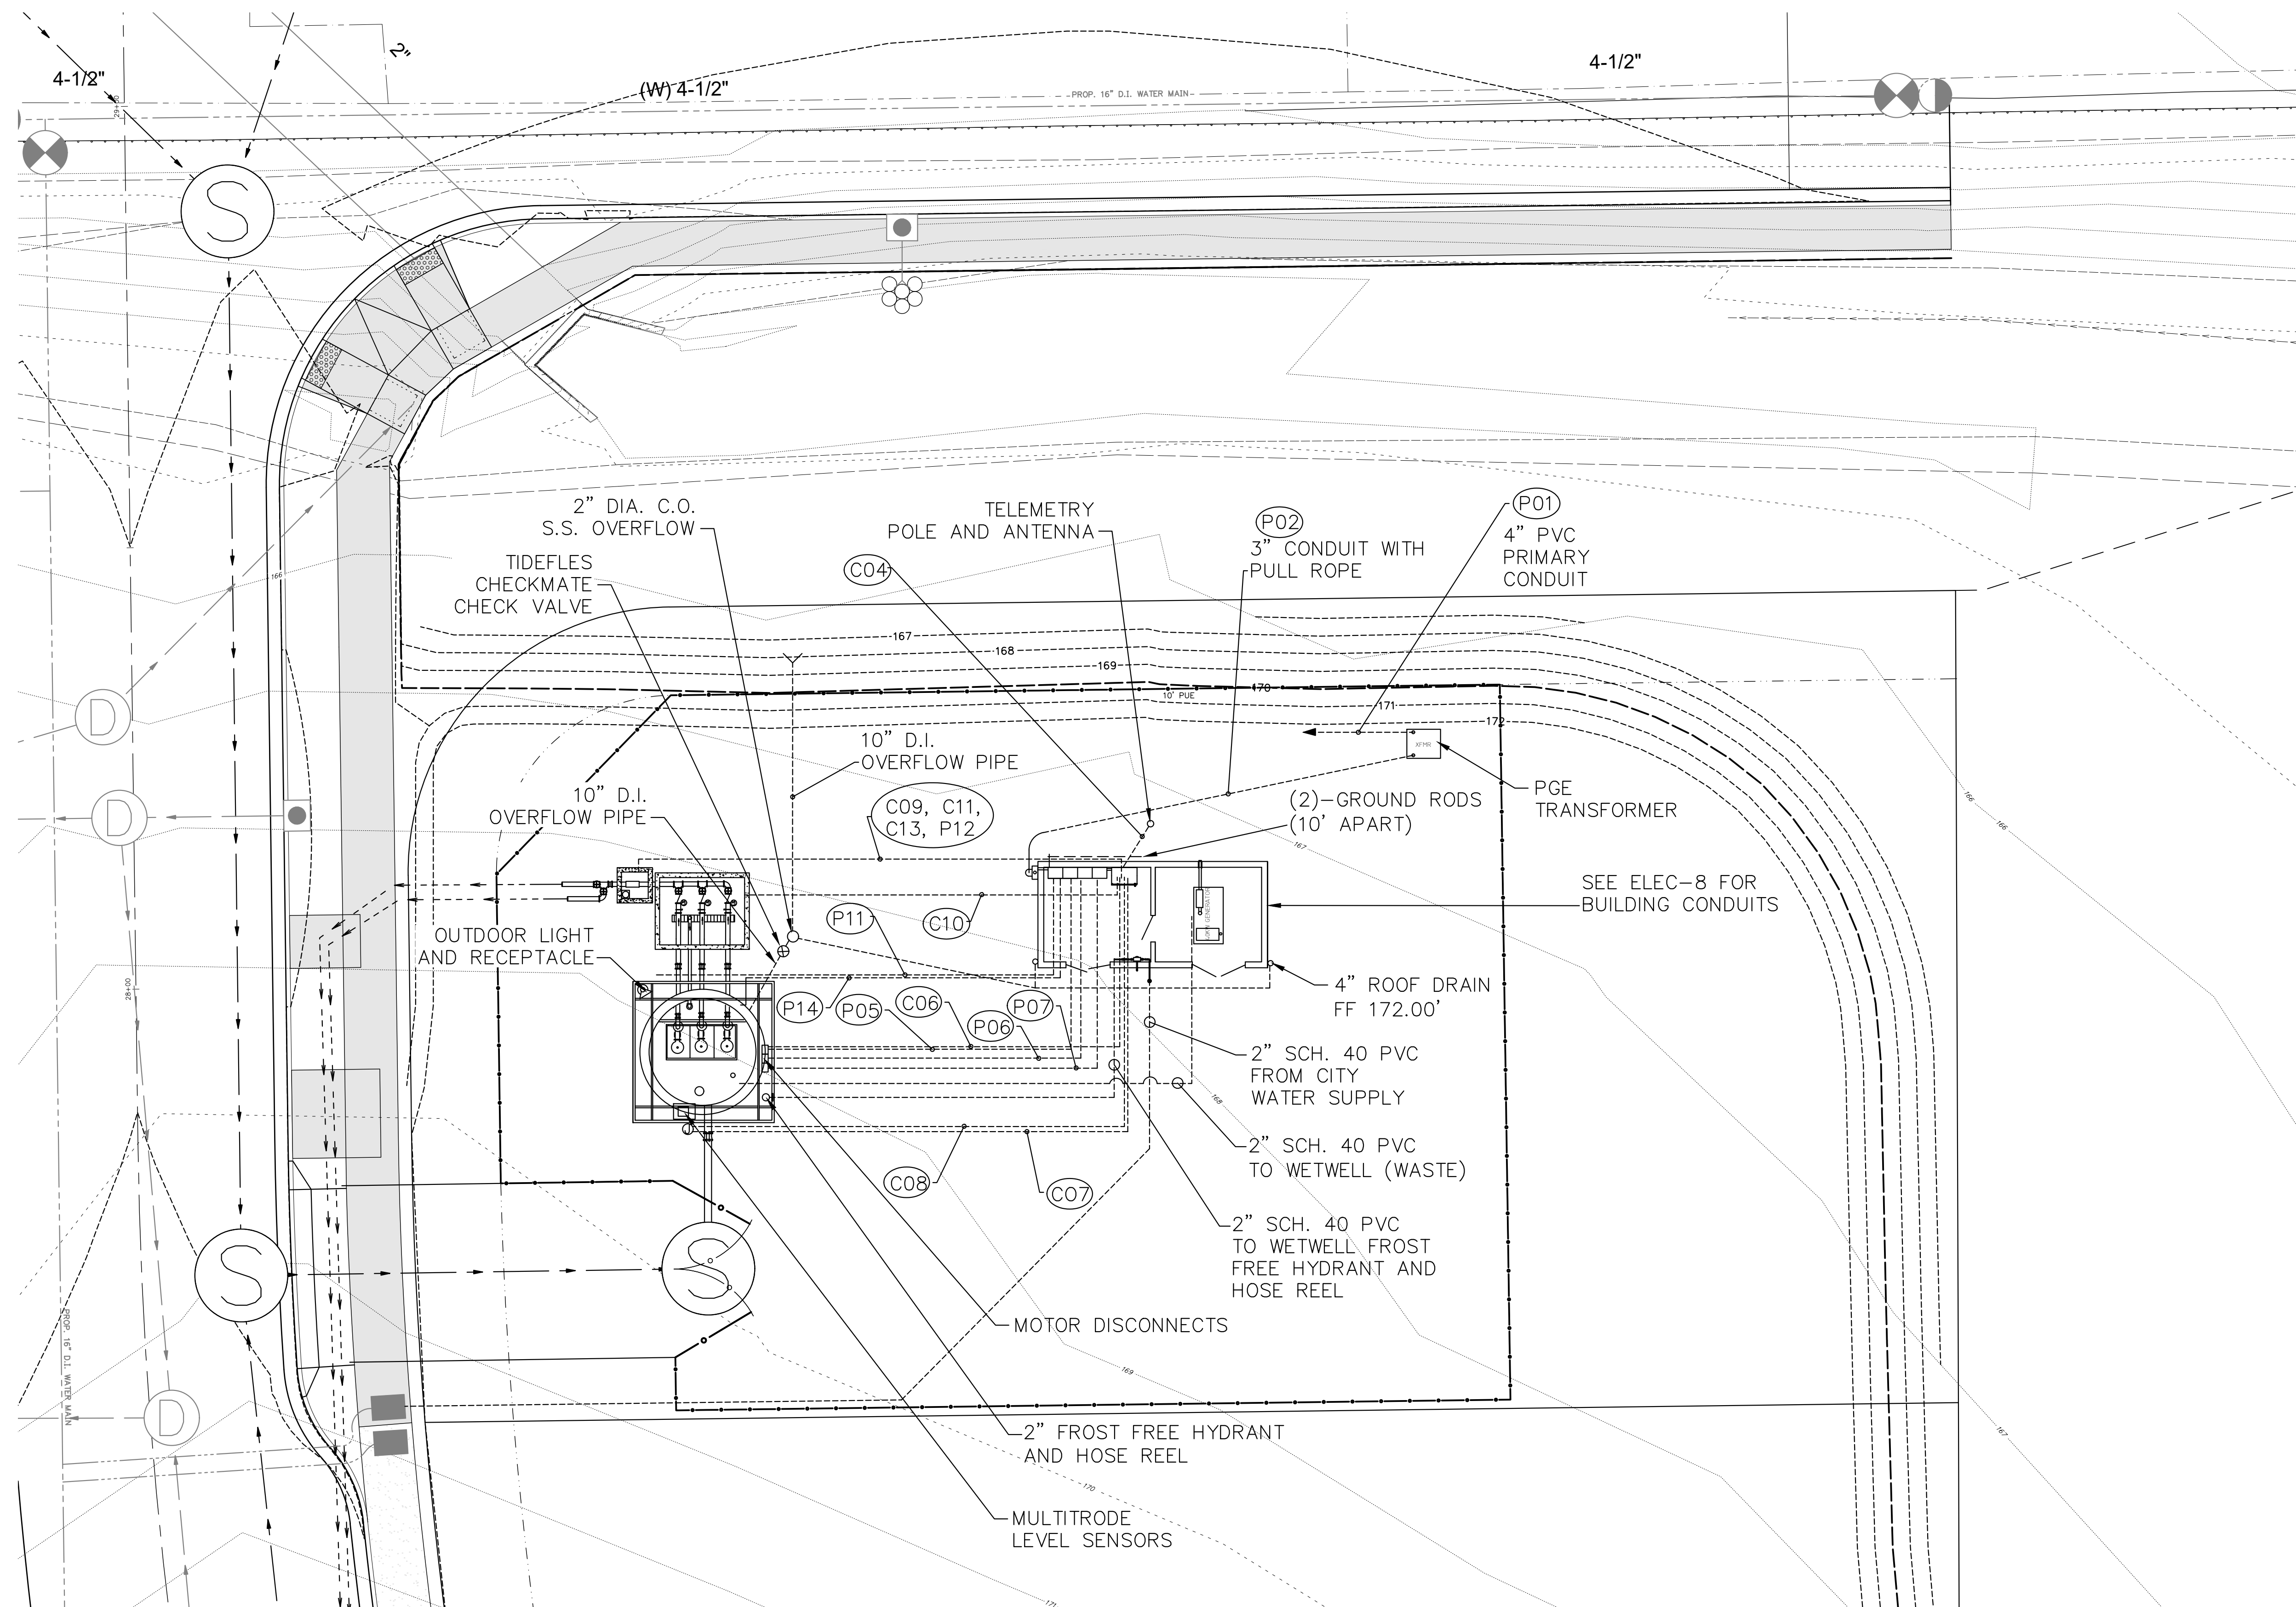


# PUMP STATION SITE PLAN

## NORTHSTAR SEGMENTS 'J-K'

NOT FOR  
CONSTRUCTION  
UNLESS STAMPED  
APPROVED HERE

NO CHANGES, MODIFICATIONS  
OR REPRODUCTIONS TO BE  
MADE TO THESE DRAWINGS  
WITHOUT WRITTEN  
AUTHORIZATION FROM THE  
DESIGN ENGINEER.

DIMENSIONS & NOTES TAKE  
PRECEDENCE OVER  
GRAPHICAL REPRESENTATION

68763K-2SS ELEC-4

Design: M.D.G.  
Drawn: C.F.S.  
ProjMgr: J.J.G.  
Date: JUNE 2020  
Scale: AS SHOWN

As-Built: -----

JOB # 6876

**ELEC-4**