



J:\6502-6599\6502-DevonAvenueSubstation\Drawings\6502\6502020.dwg, P304.DRW, 11/10/2020 11:03:54 AM, P304.dwg

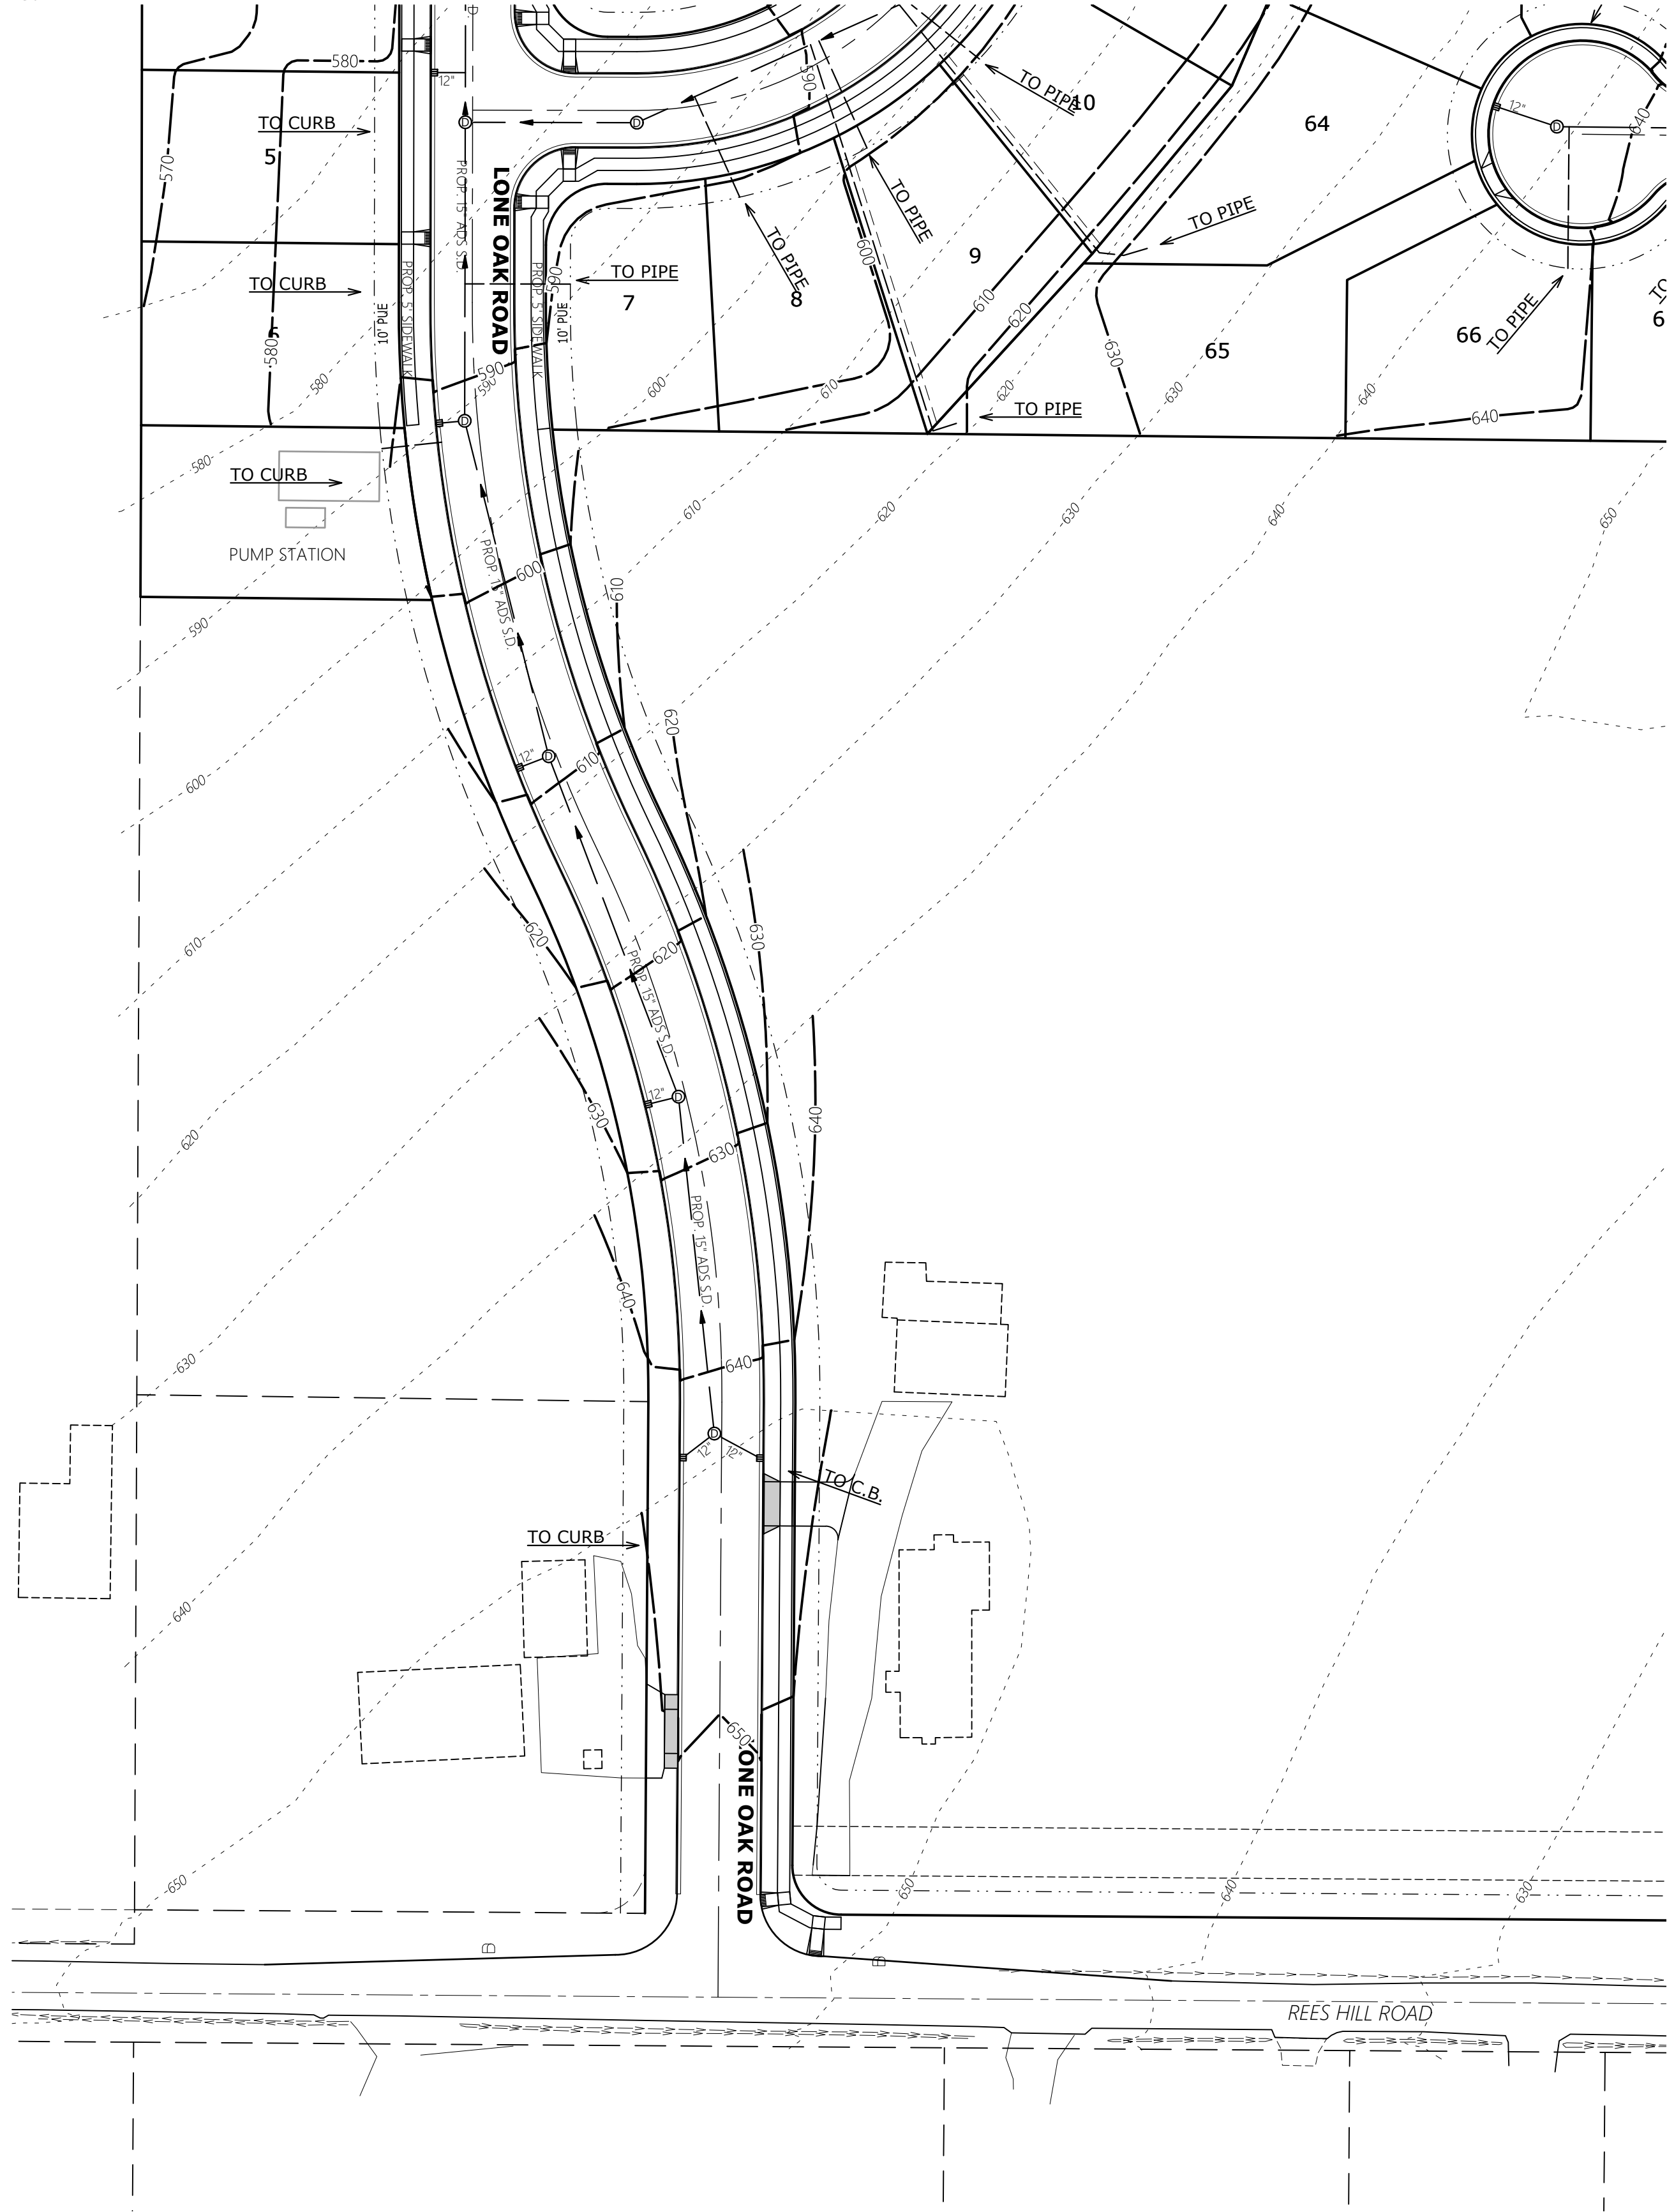

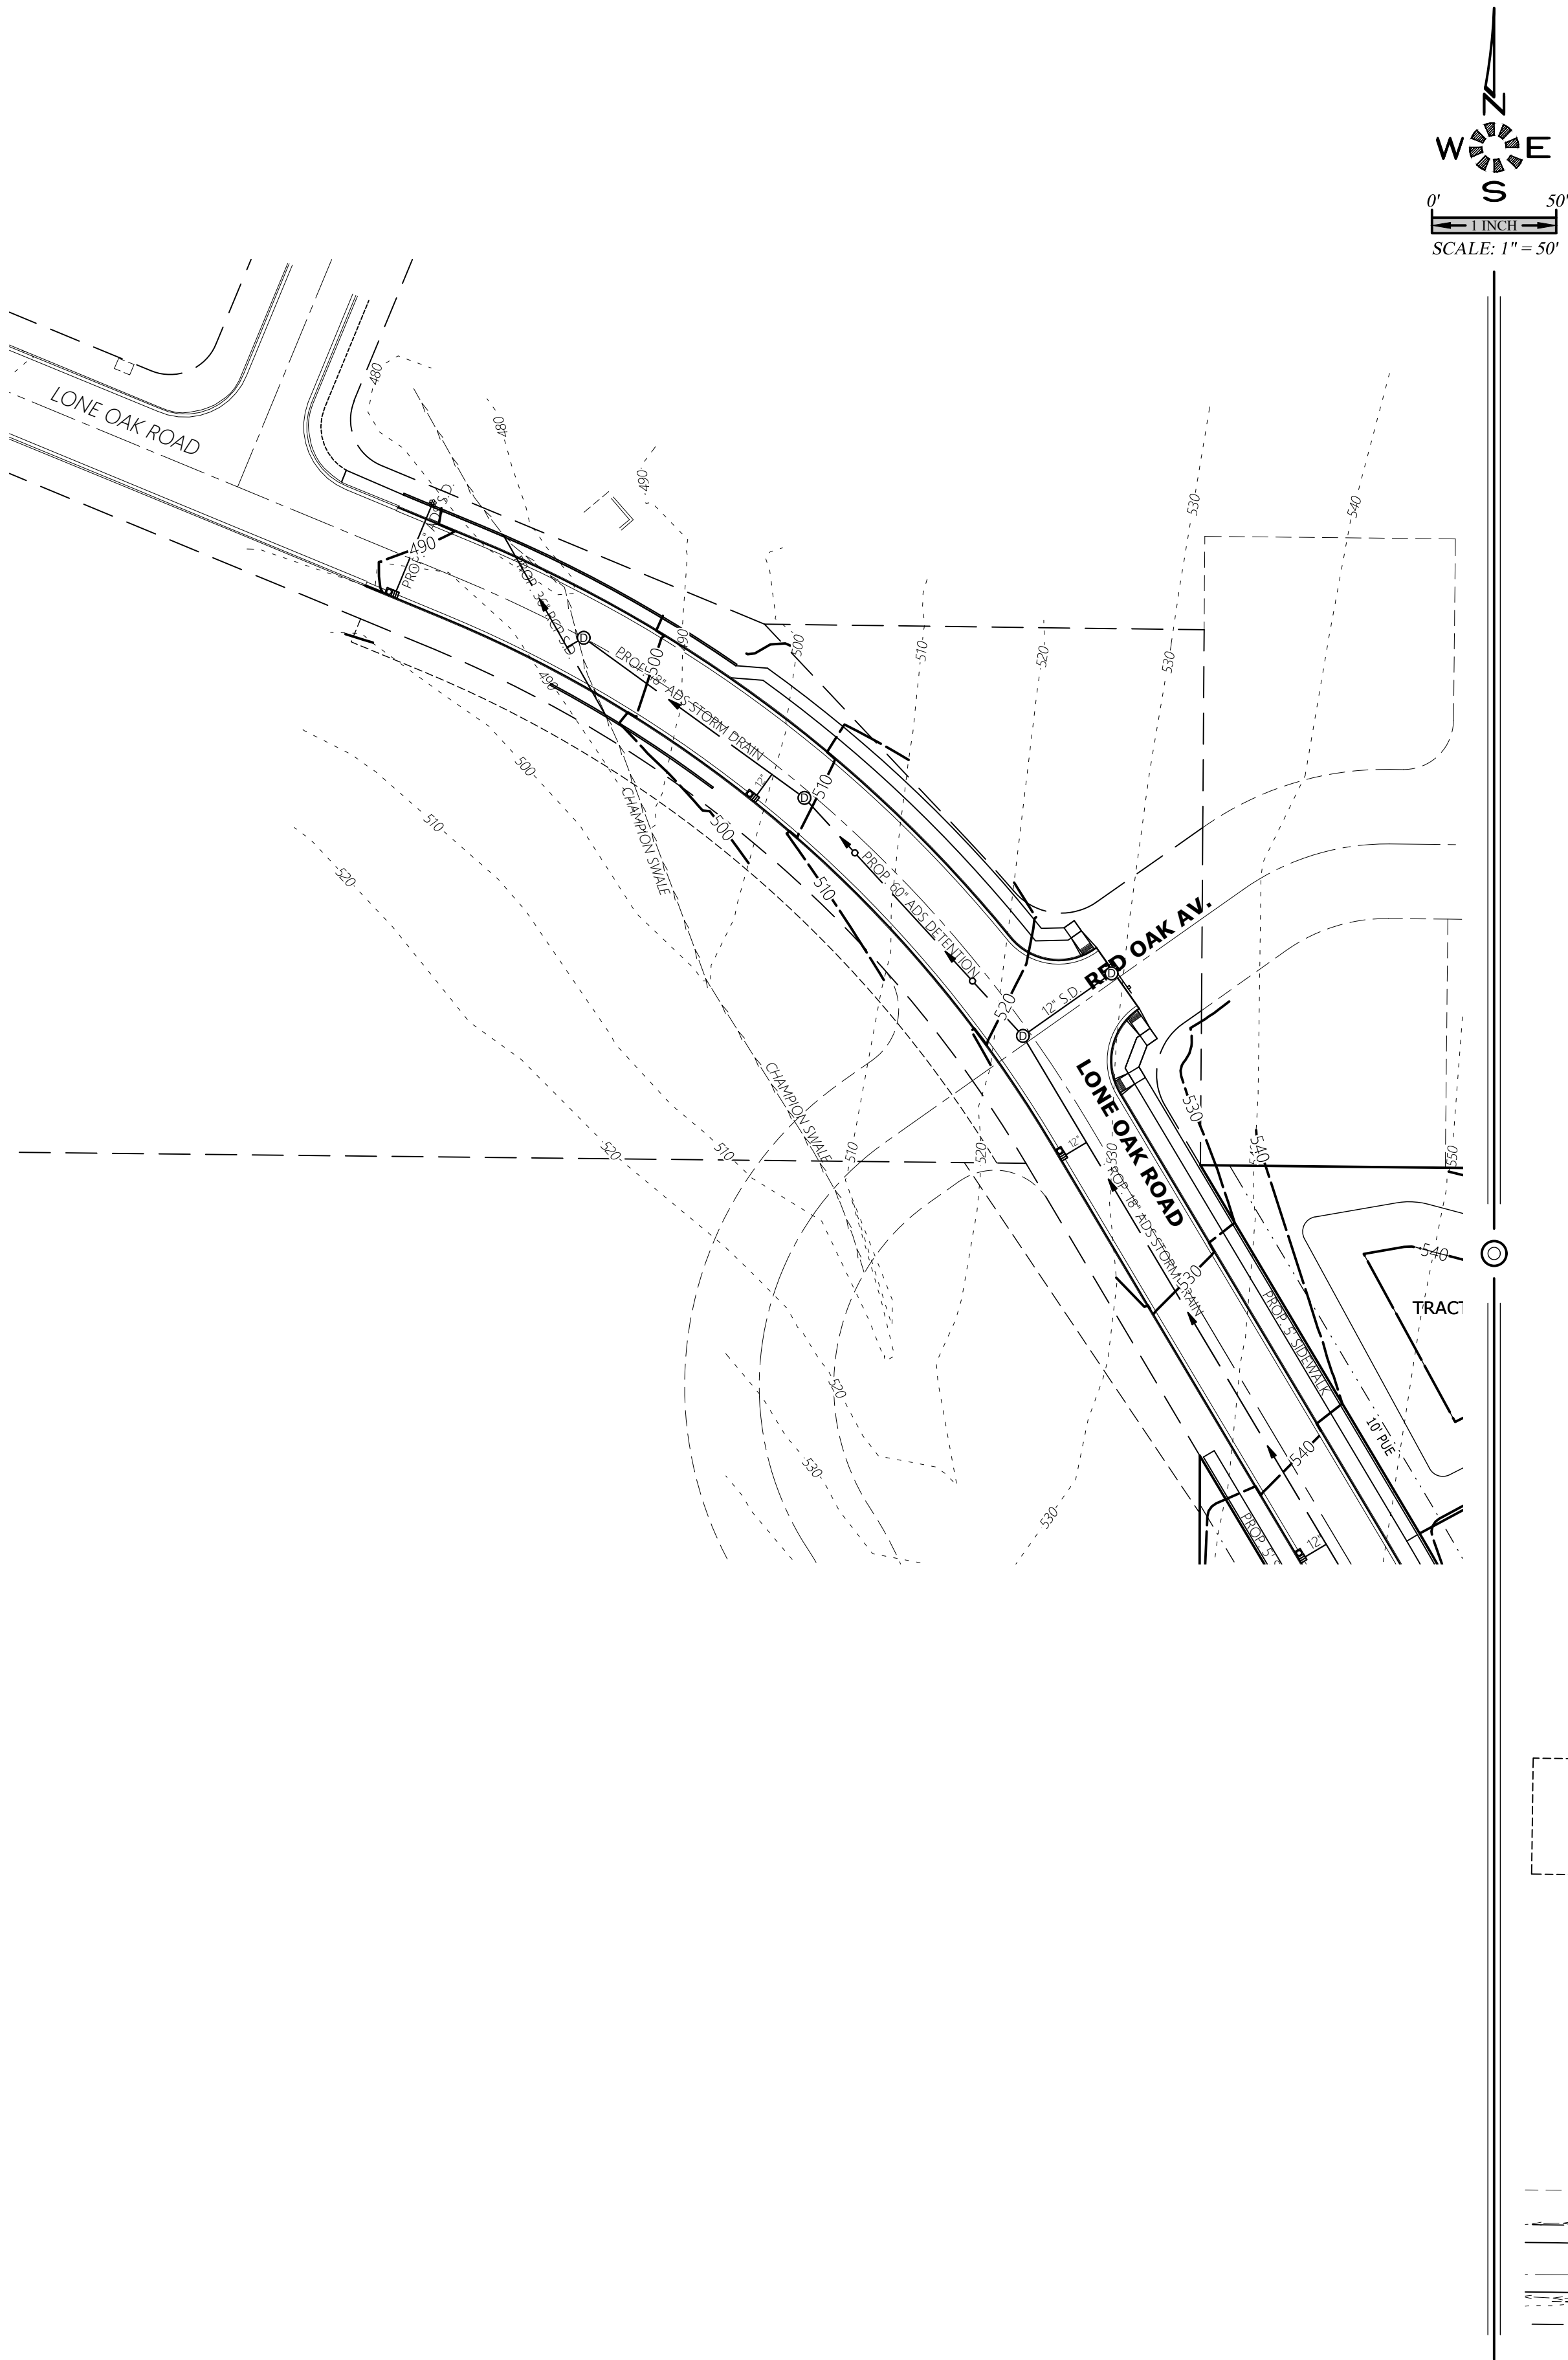

ENGINEERING SERVICES, INC.
1155 13th ST., S.E. SALEM, OR. 97302
PH. (503) 363-5227 FAX (503) 364-1860
www.mtengr.com office@mtengr.com

**PRELIMINARY
DRAINAGE PLAN - OFFSITE**

DEVON ESTATES

NO CHANGES, MODIFICATIONS
OR REDUCTIONS SHALL BE
MADE TO THESE DRAWINGS
WITHOUT WRITTEN
AUTHORIZATION FROM THE
DESIGN ENGINEER.
DIMENSIONS & NOTES TAKE
PRECEDENCE OVER
GRAPHICAL REPRESENTATION.

Design: M.D.G.
Drawn: P.H.S.
Checked: B.M.G.
Date: NOV. 2017
Scale: AS SHOWN
As-Built: ----



REGISTERED PROFESSIONAL
ENGINEER
OREGON
JULY 4, 1978
MARK D. GREYM
EXPIRES: 06-30-2021

JOB # 6502

P304