


J:\6502-6599\6502-DevonAvenueSubdivision\Drawings\6502\6502P305.dwg, P305DRN, 1/20/2021 2:58:36 PM, P.Saunders

SEE SHEET 303
FOR ON-SITE
DRAINAGE PLAN

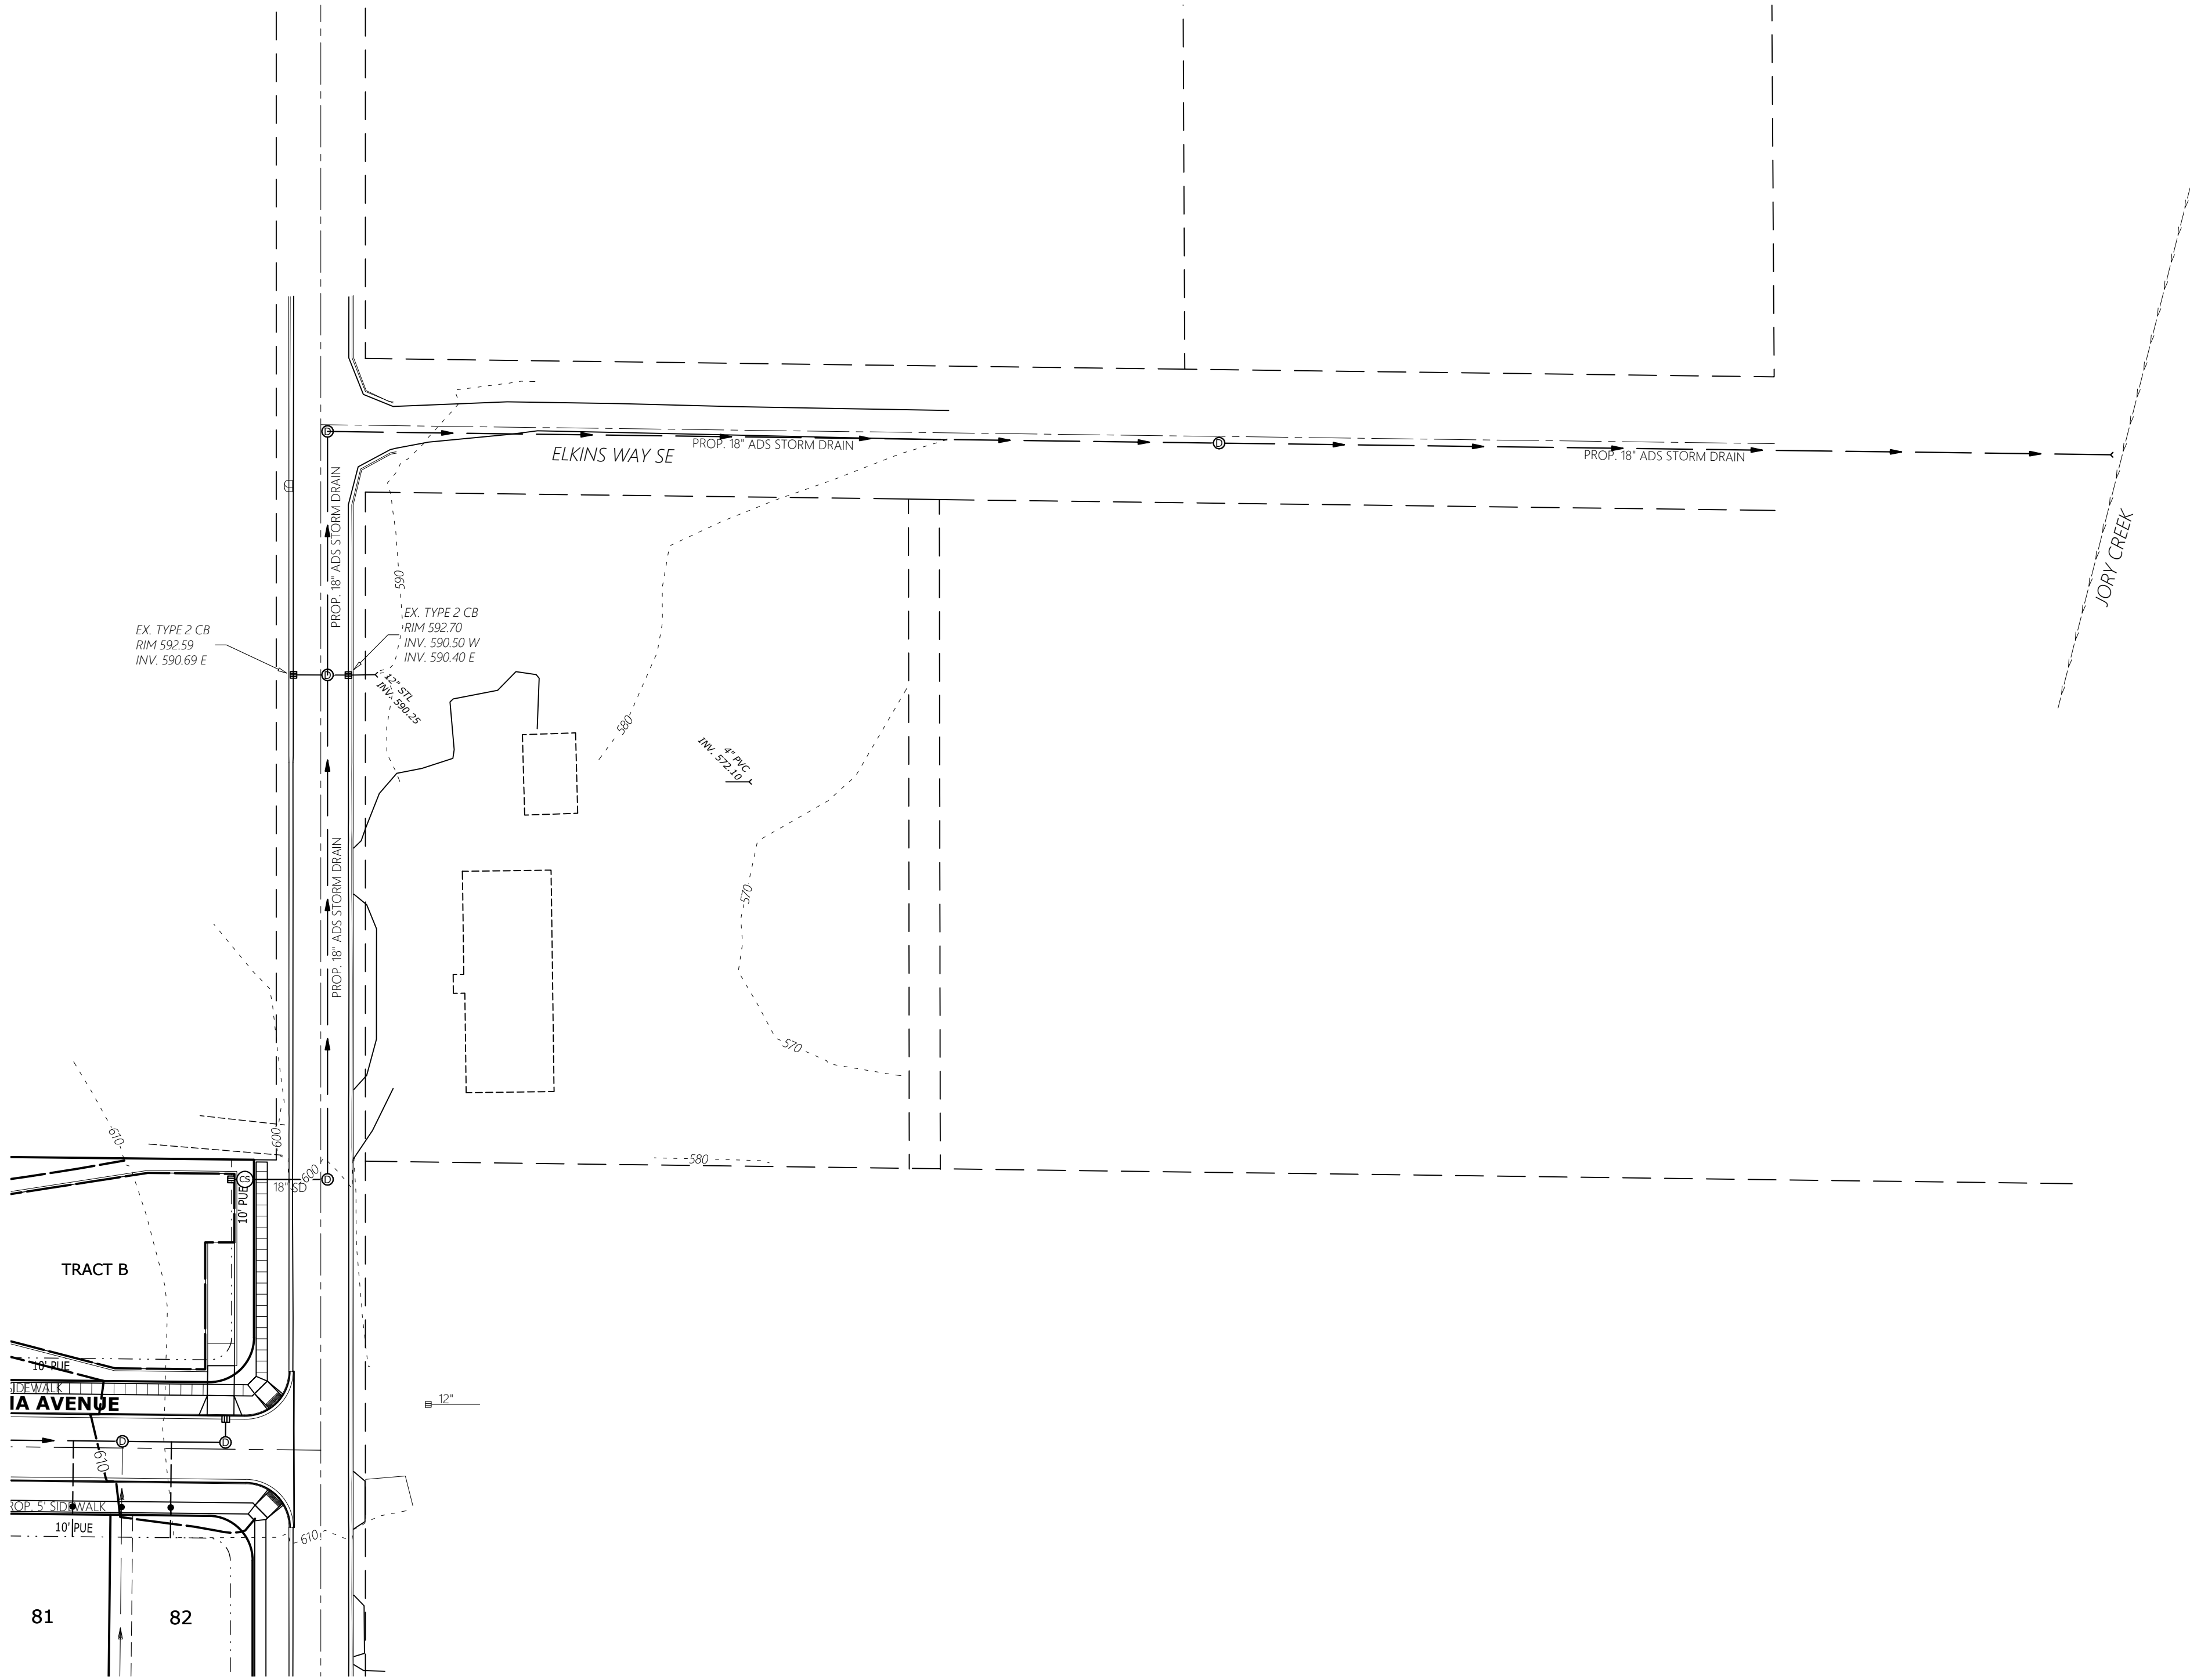



ENGINEERING SERVICES, INC.
1155 13TH ST., S.E. SALEM, OR. 97302
PH: (503) 363-5277 FAX: (503) 364-2660
www.mtengineering.net office@mtengineering.net

PRELIMINARY
DRAINAGE PLAN - OFFSITE:
NORTHEAST

DEVON ESTATES

NO CHANGES, MODIFICATIONS
OR REVISIONS TO THIS DRAWING
MADE TO THESE DRAWINGS
WITHOUT WRITTEN
AUTHORIZATION FROM THE
DESIGN ENGINEER.
DIMENSIONS & NOTES TAKE
PRECEDENCE OVER
GRAPHICAL REPRESENTATION.

Design:	M.D.G.
Drawn:	P.H.S.
Checked:	M.D.G.
Date:	NOV. 2017
Scale:	AS SHOWN
As-Built:	----



REGISTERED PROFESSIONAL
ENGINEER
OREGON
NO. 8654
JULY 14, 1978
MARK D. GREVILLE
EXPIRES: 06-30-2021

JOB # 6502

P305