

**BUILDING ELEVATIONS
 AND ELECTRICAL PLAN**

**COBURN
 APARTMENT COMPLEX**

NO CHANGES, MODIFICATIONS OR
 REVISIONS TO BE MADE
 WITHOUT WRITTEN
 AUTHORIZATION FROM THE DESIGN
 ENGINEER.
 DIMENSIONS & NOTES TAKE
 PRECEDENCE OVER GRAPHICAL
 REPRESENTATION.

Design: P.L.M.
 Drawn: G.L.D.
 Checked: M.D.G.
 Date: Jun-21
 Scale: AS SHOWN


JOB # 7192

REGISTERED PROFESSIONAL
 ENGINEER
 JULY 14, 1978
 MARK D. GREY
 Renew date: June 30, 2023

A9.60



EAST ELEVATION (RECREATION BLD. 12)
 SCALE: 1/8" = 1'-0"

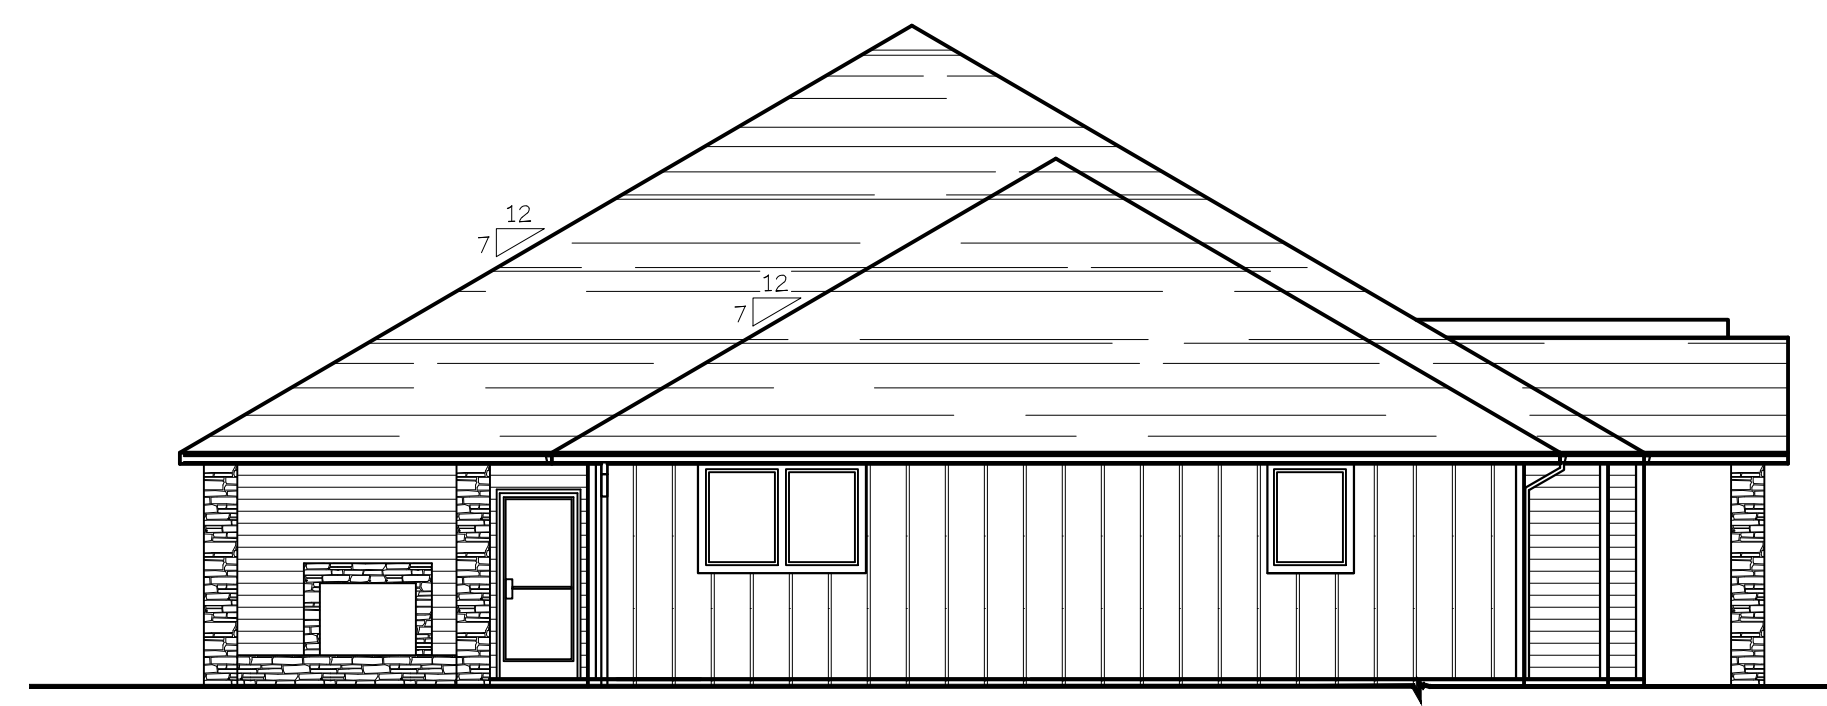

NORTH ELEVATION (RECREATION BLD. 12)
 SCALE: 1/8" = 1'-0"




WEST ELEVATION (RECREATION BLD. 12)
 SCALE: 1/8" = 1'-0"

- 30 YEAR OR BETTER ROOFING
 W/ FELT TYPE PAPER
 PER CODE
- FIBER CEMENT SHAKE
- 1X3 CEDAR TRIM
- 7" LAP SIDING W/
 2X6 SUB FASCIA
- CONT. GUTTER
 W/ DOWN SPOUT
- 5/4 FINGER JOINTED
 PRE PRIMED HOUSE TRIM
- FIBER CEMENT BOARD AND BATT
 (SHOWN AT 16" O.C.)



SOUTH ELEVATION (RECREATION BLD. 12)
 SCALE: 1/8" = 1'-0"

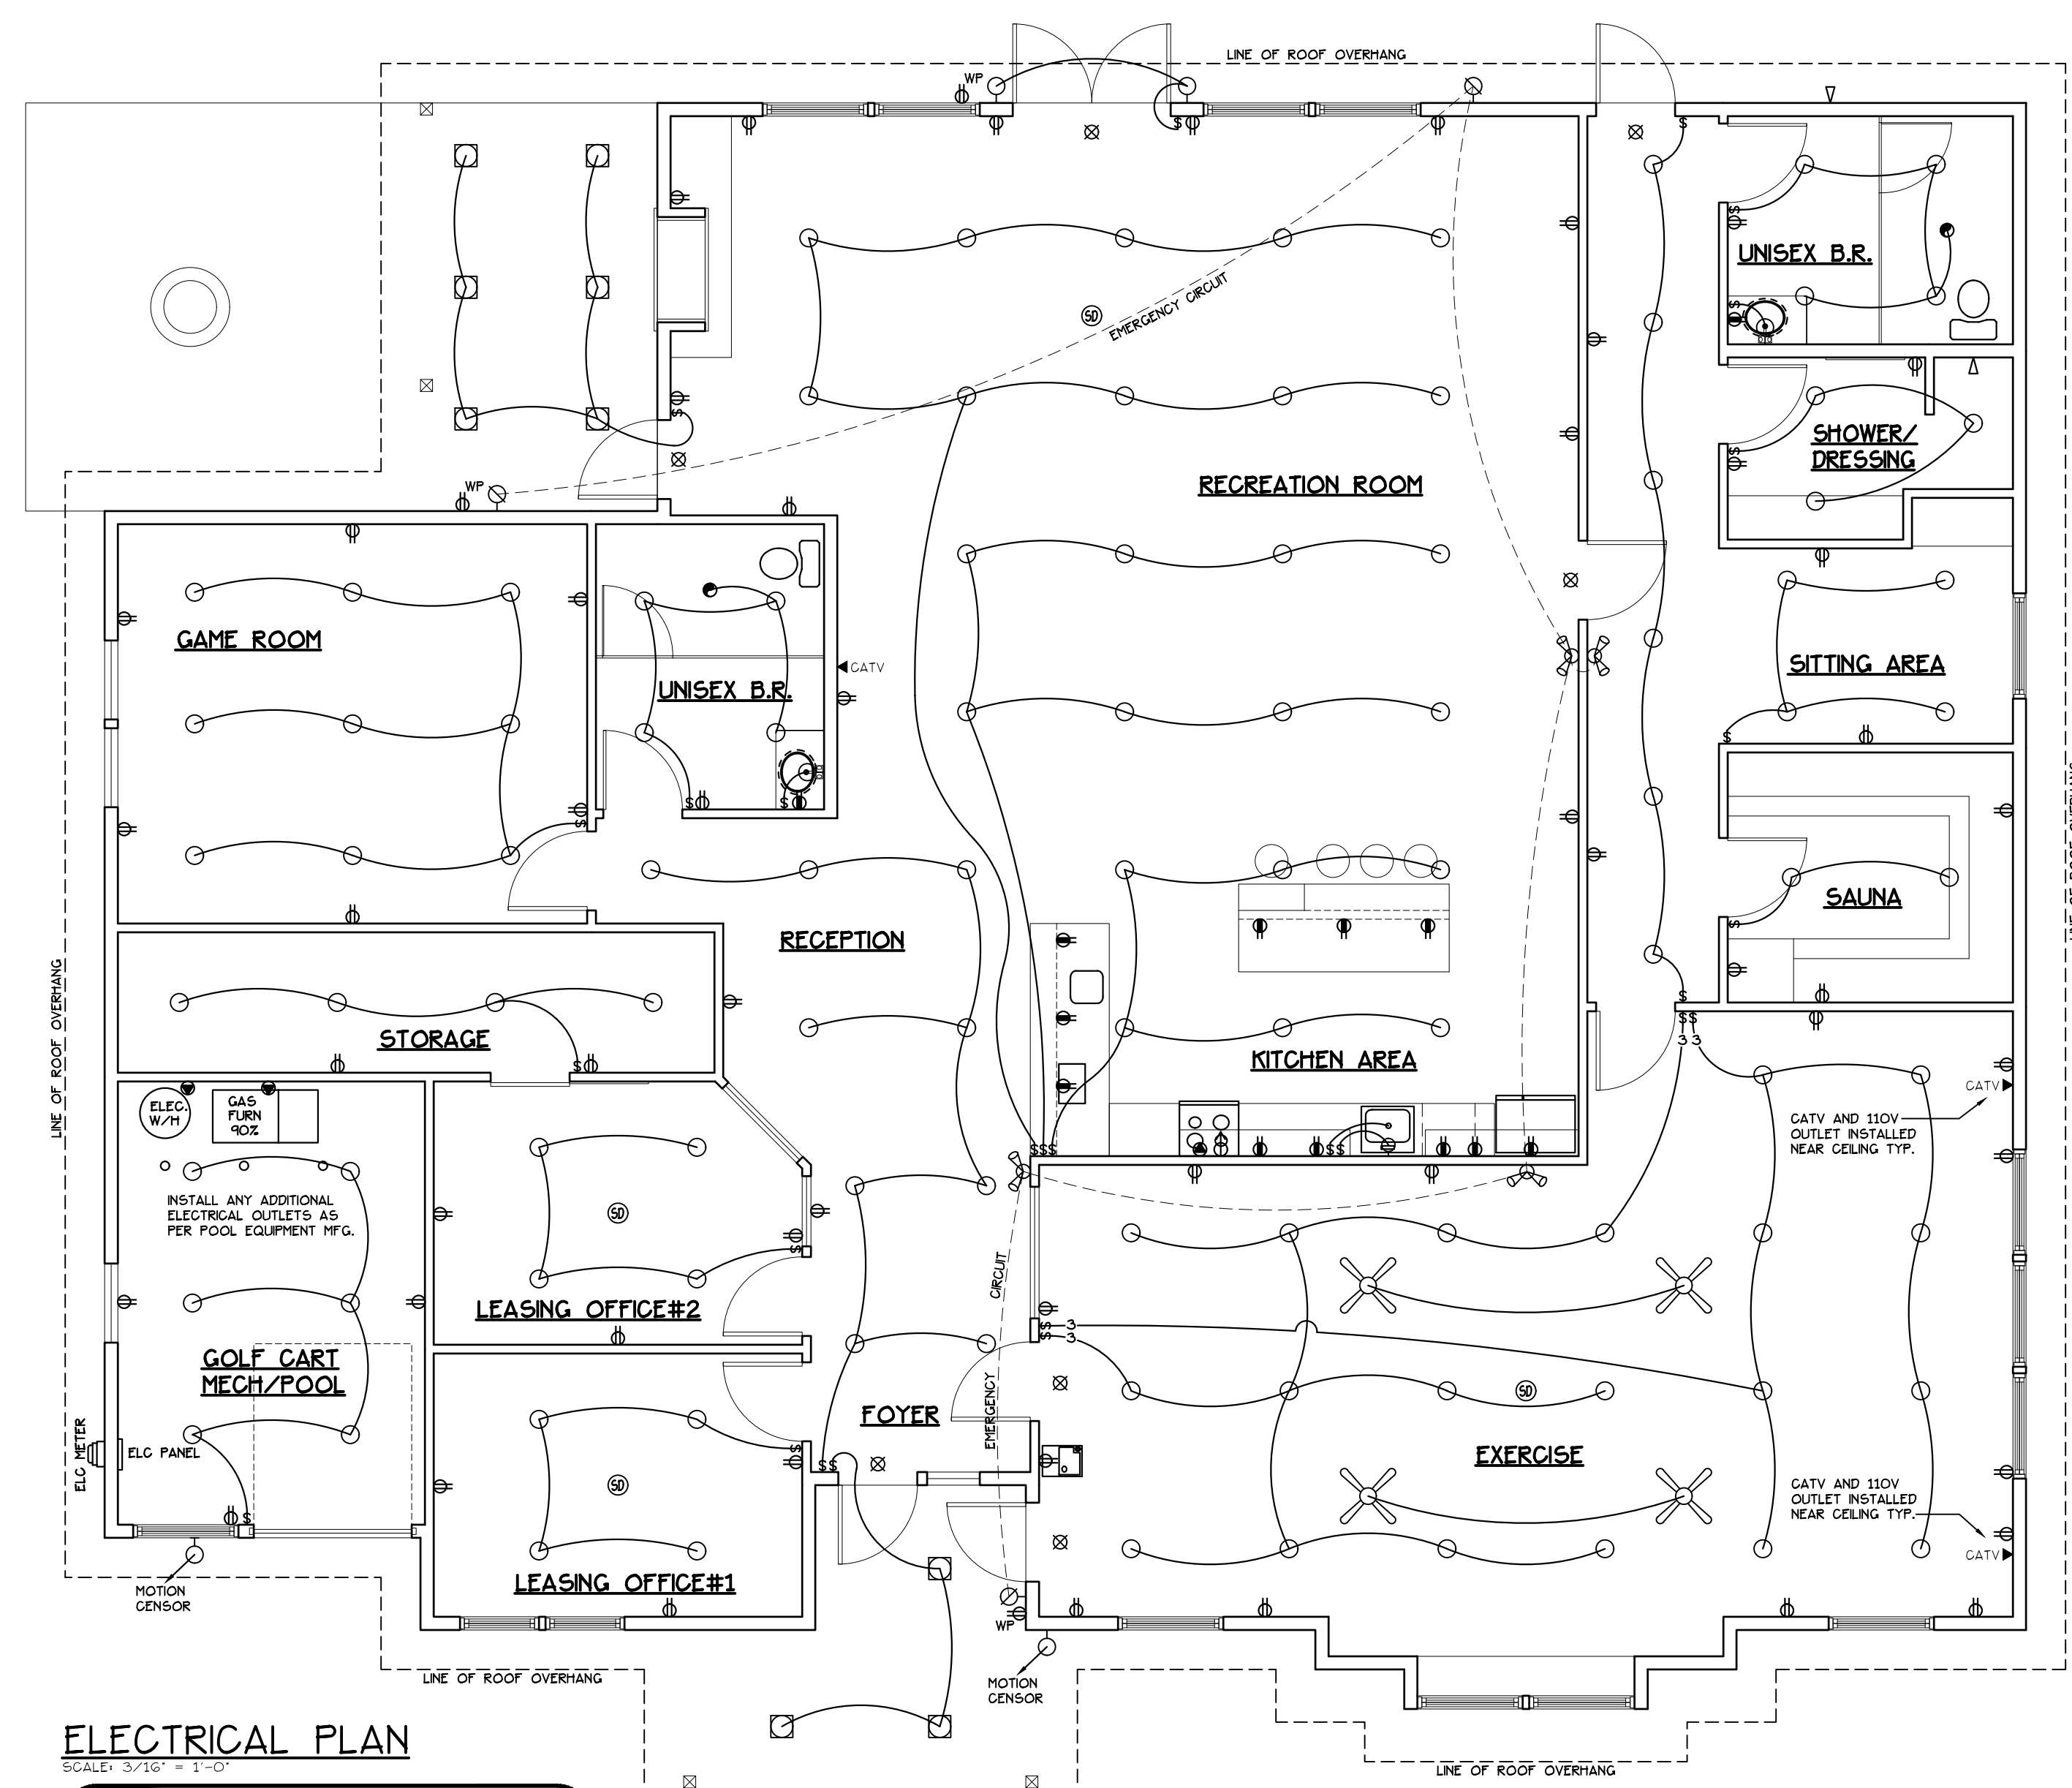

ELECTRICAL PLAN
 SCALE: 3/16" = 1'-0"
RECREATION BLD. 12

⊗ COMBINATION SMOKE/CARBON MONOXIDE
 DETECTORS TO BE LINKED FOR COLLECTIVE
 ALARM UPON THE ACTIVATION OF ANY ONE.
 WIRED TO 110V WITH BATTERY BACK-UP.