



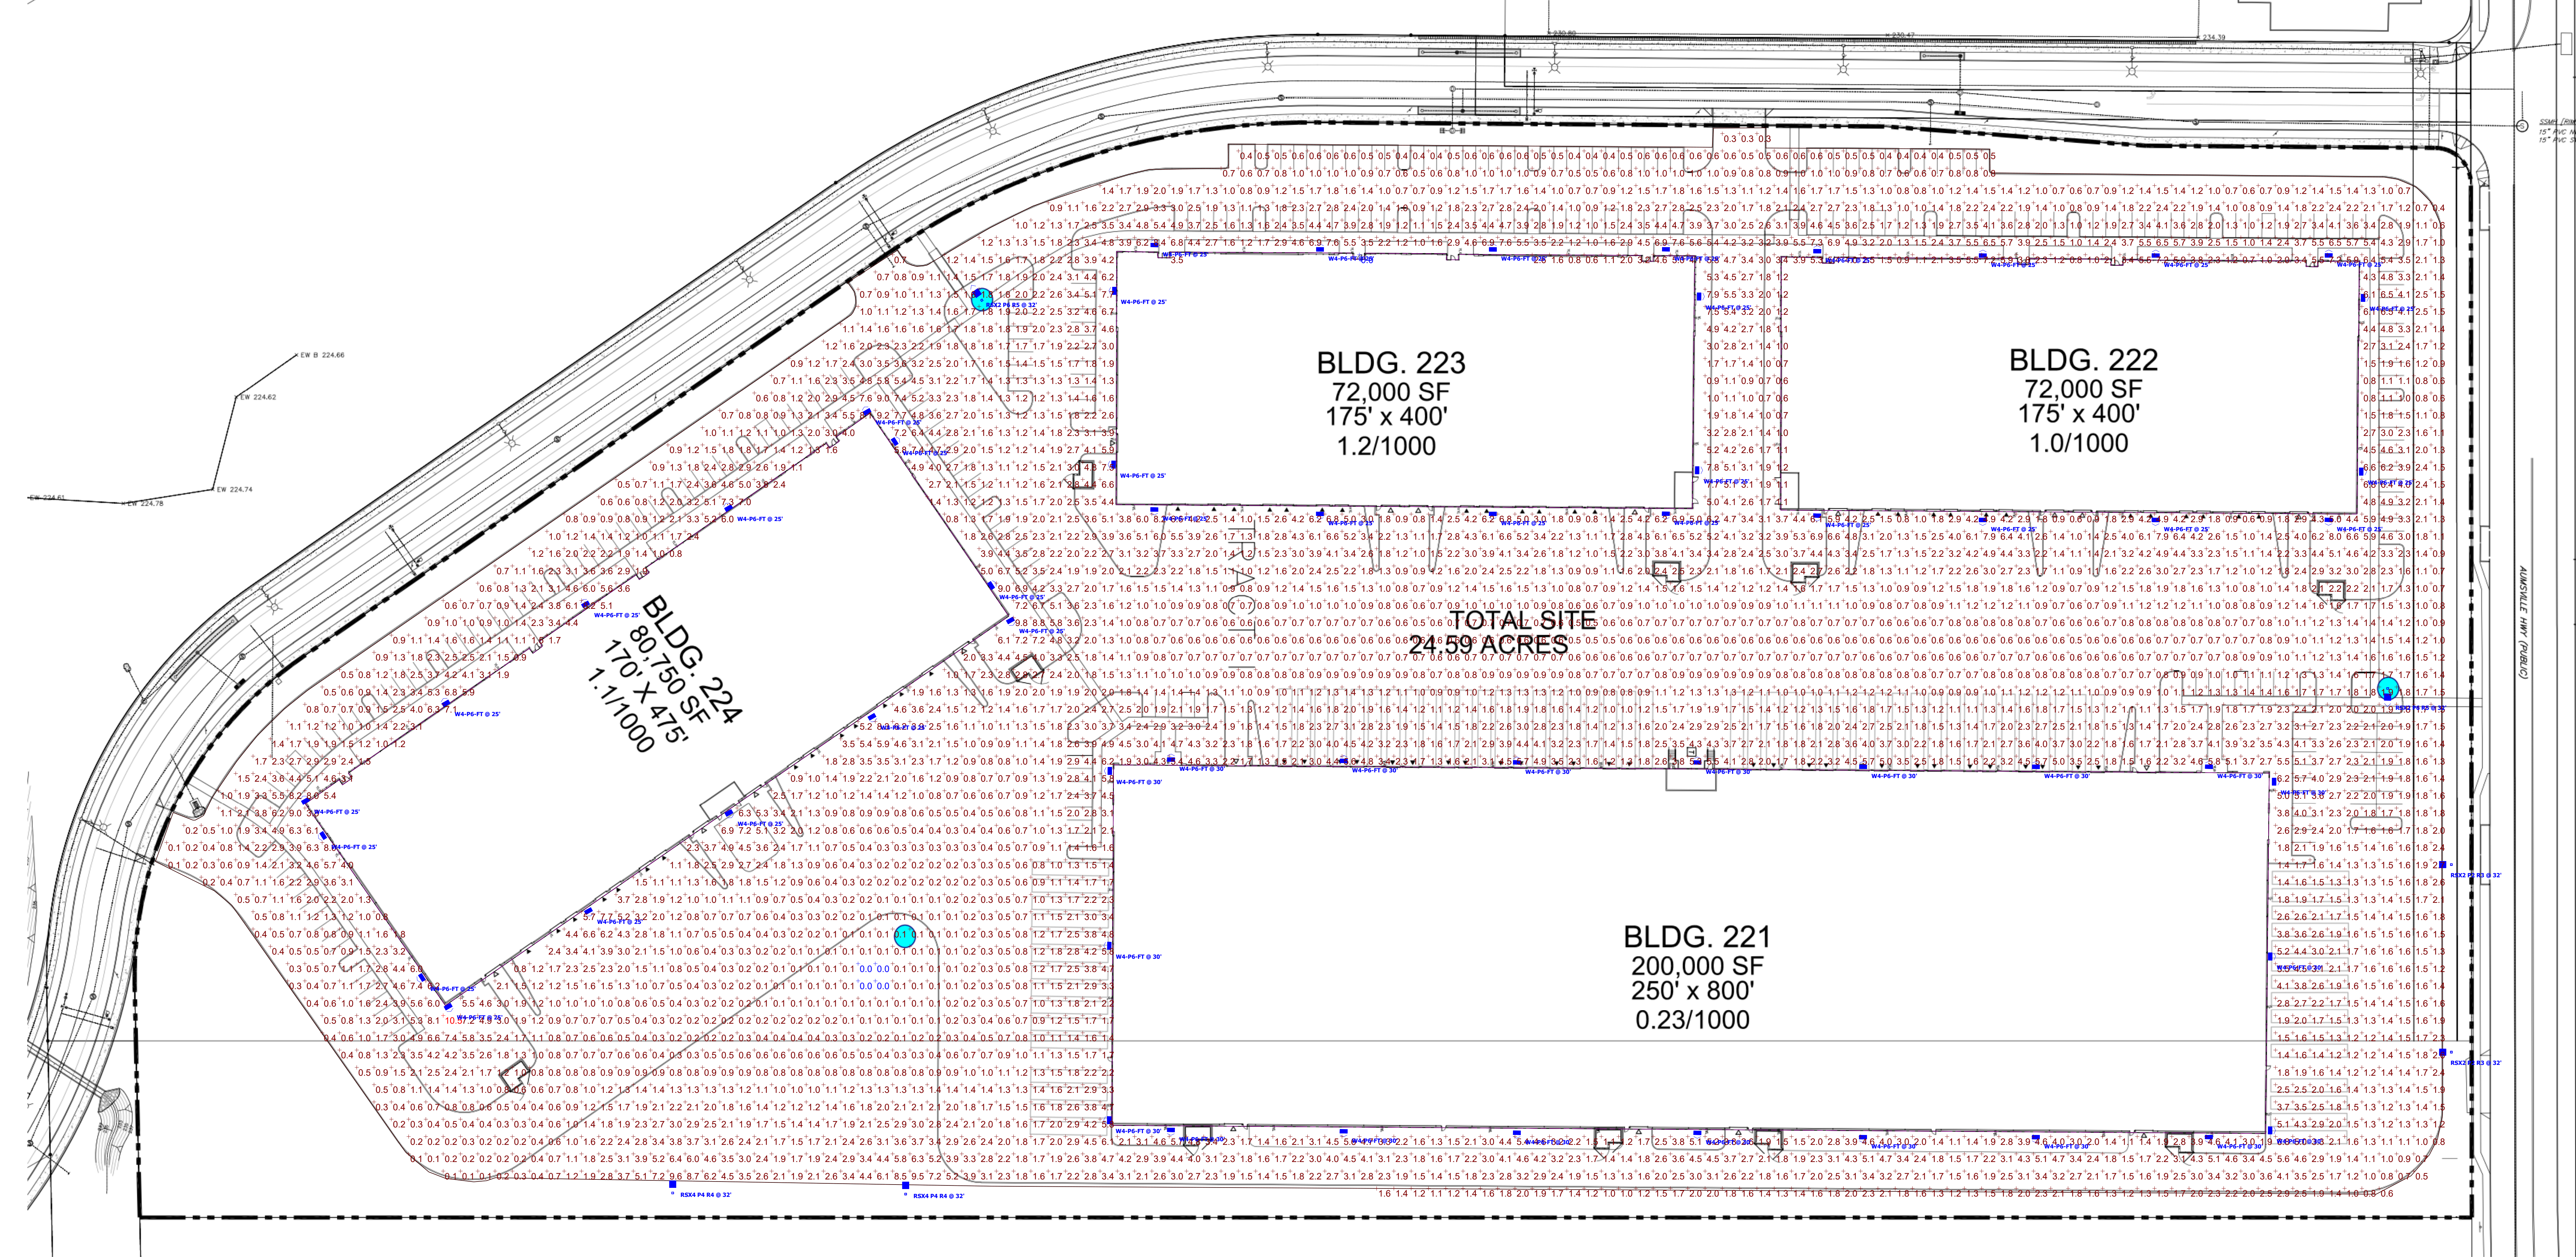

ENLARGED SITE PLAN
SCALE: 1" = 50'-0"

Statistics						
Description	Symbol	Max	Min	Max/Min	Avg/Min	Avg
Parking Lot Light Level		10.5 fc	0.0 fc	N/A	N/A	2.0 fc

Schedule									
Symbol	Label	Image	Quantity	Manufacturer	Catalog Number	Description	Lumens Per Lamp	Light Loss Factor	Wattage
	W4-P6-FT		56	Lithonia Lighting	WDGE4 LED P6 70CRI RFT 40K	WDGE4 LED WITH P6 - PERFORMANCE PACKAGE, 4000K, 70CRI, FORWARD THROW OPTIC	25586	0.9	185.23
	RSX 2 P6 R5		2	Lithonia Lighting	RSX2 LED P6 40K R5	RSX Area Fixture Size 2 P6 Lumen Package 4000K CCT Type R5 Distribution	31073	0.9	246.63
	RSX 2 P2 R3		2	Lithonia Lighting	RSX2 LED P2 40K R3	RSX Area Fixture Size 2 P2 Lumen Package 4000K CCT Type R3 Distribution	17202	0.9	114.07
	RSX 4 P4 R4		2	Lithonia Lighting	RSX4 LED P4 40K R4	RSX Area Luminaire Size 4 P4 Lumen Package 4000K CCT Type R4 Distribution	56197	0.9	430.6189

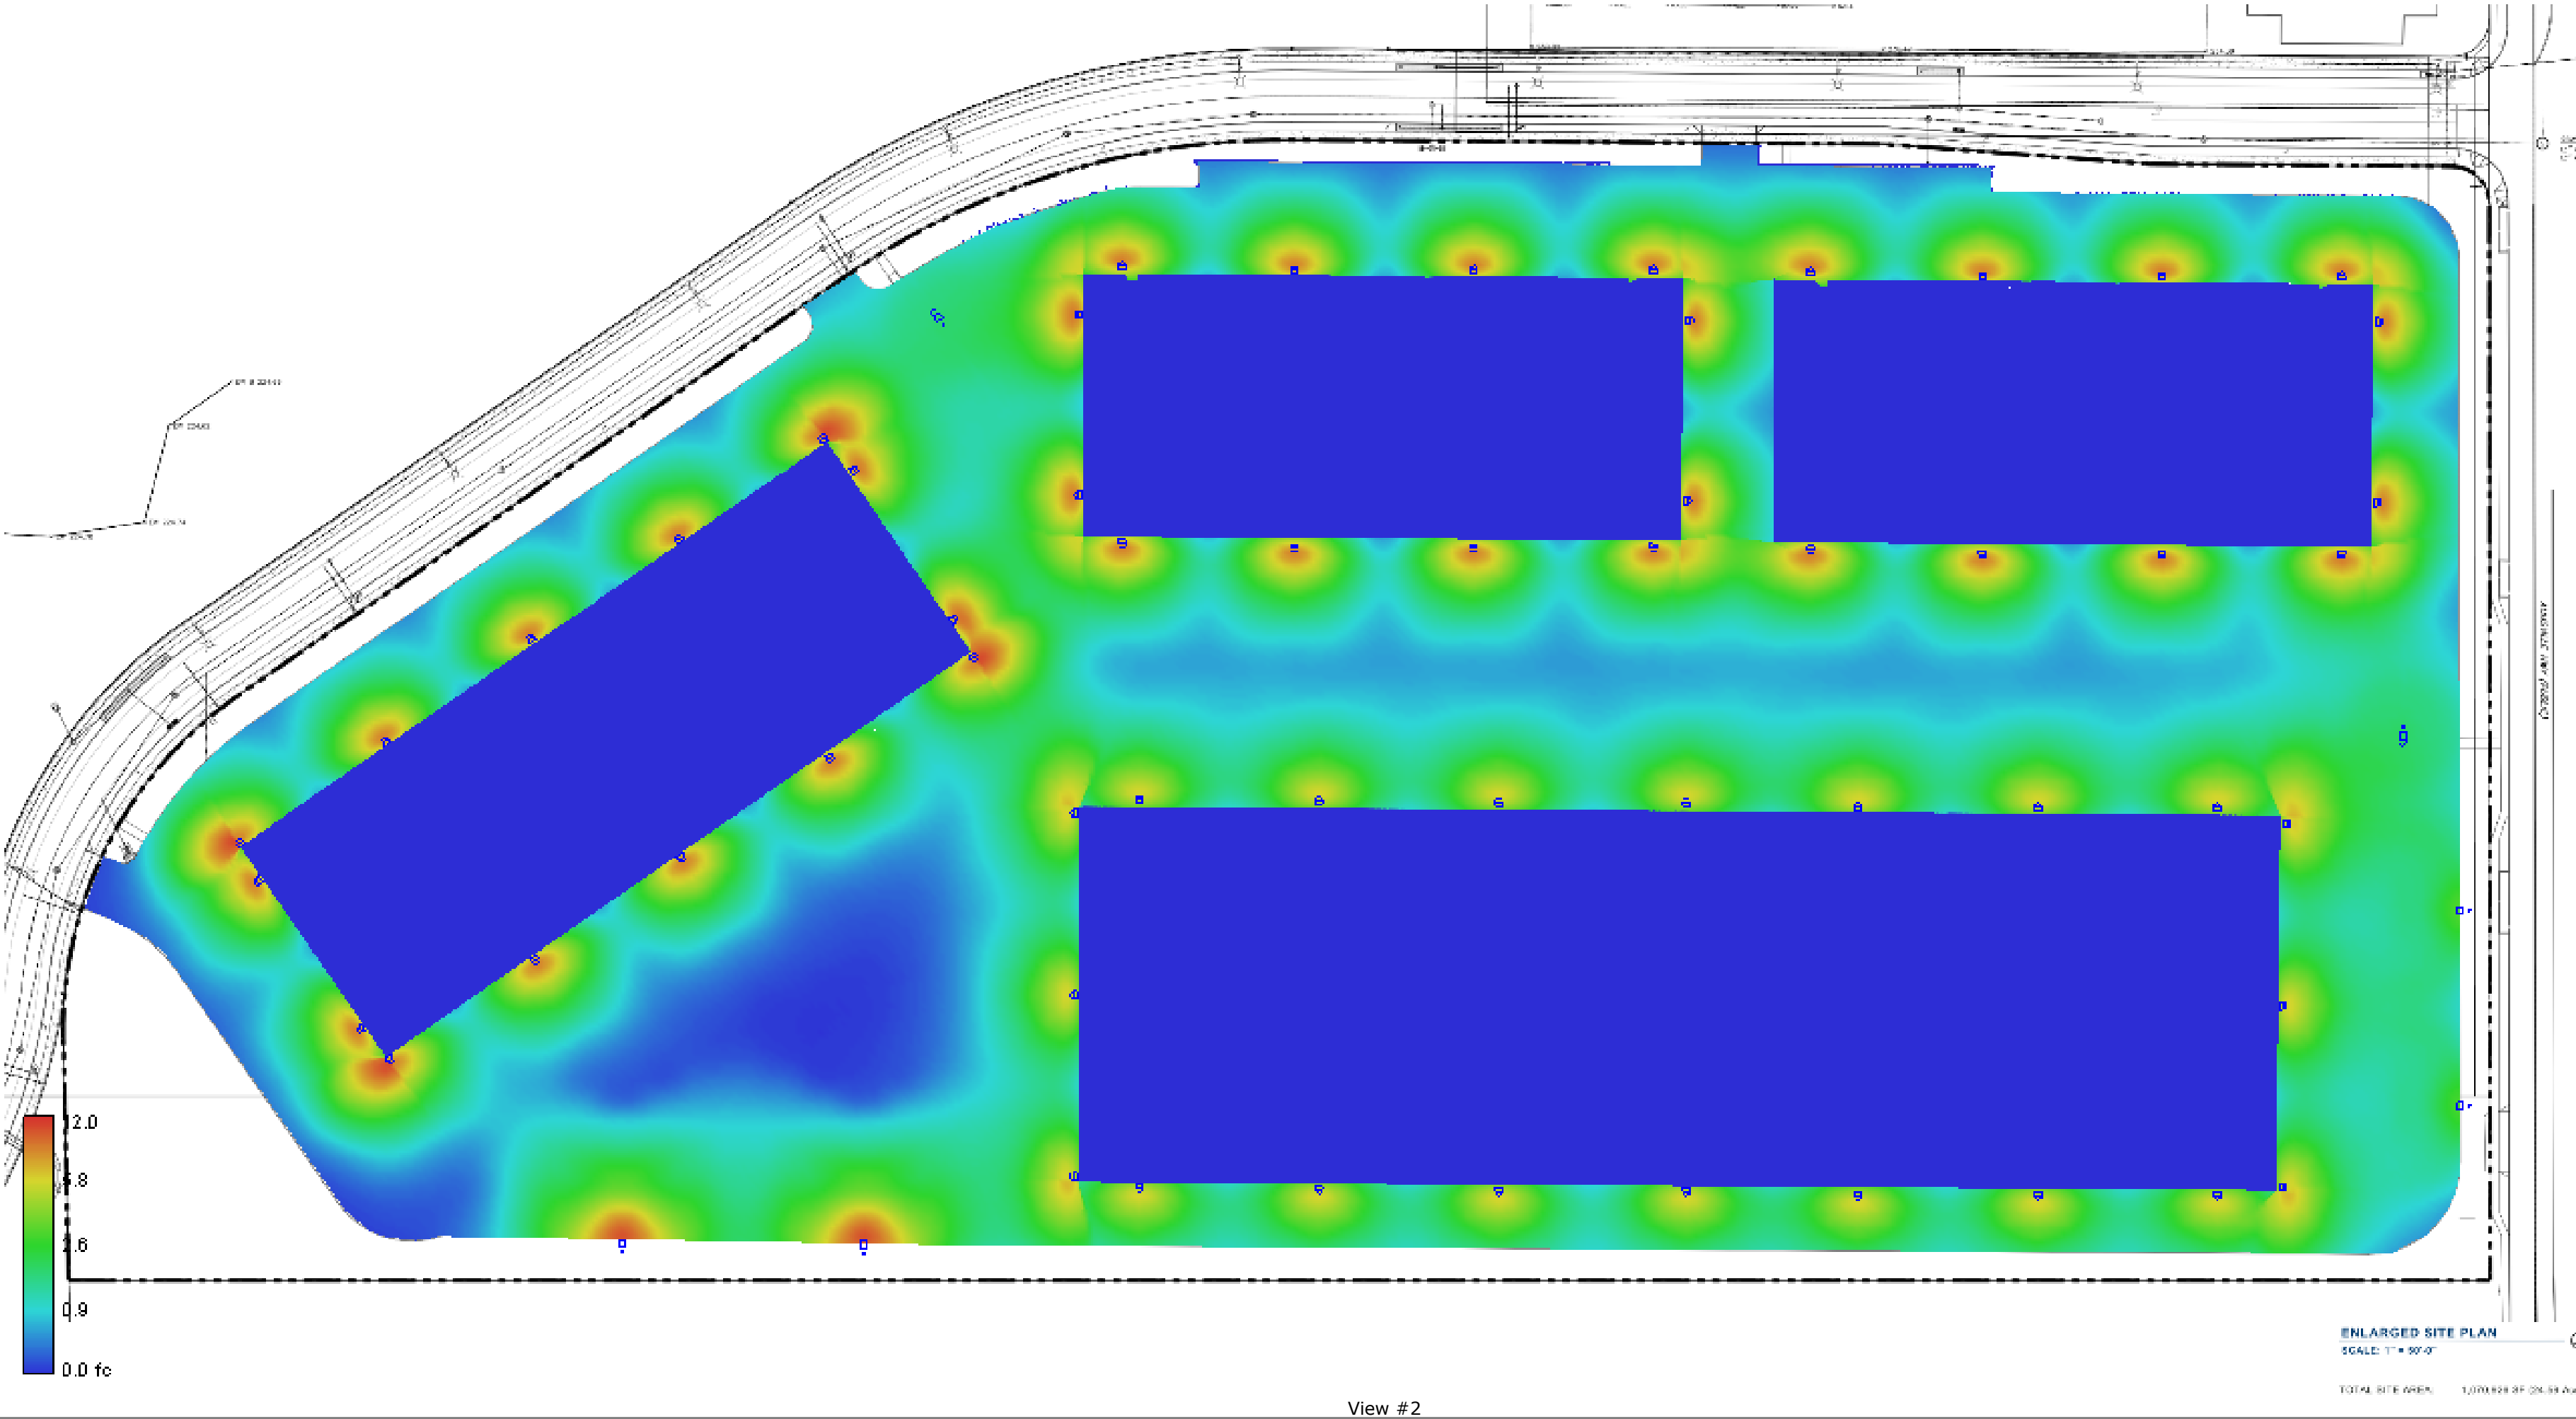

PACTRUST
11/19/21