



2/17/2022 12:43:37 PM

C:\Reel Projects\212020-21 Hillcrest
Site_Central_melindam678N.rvt

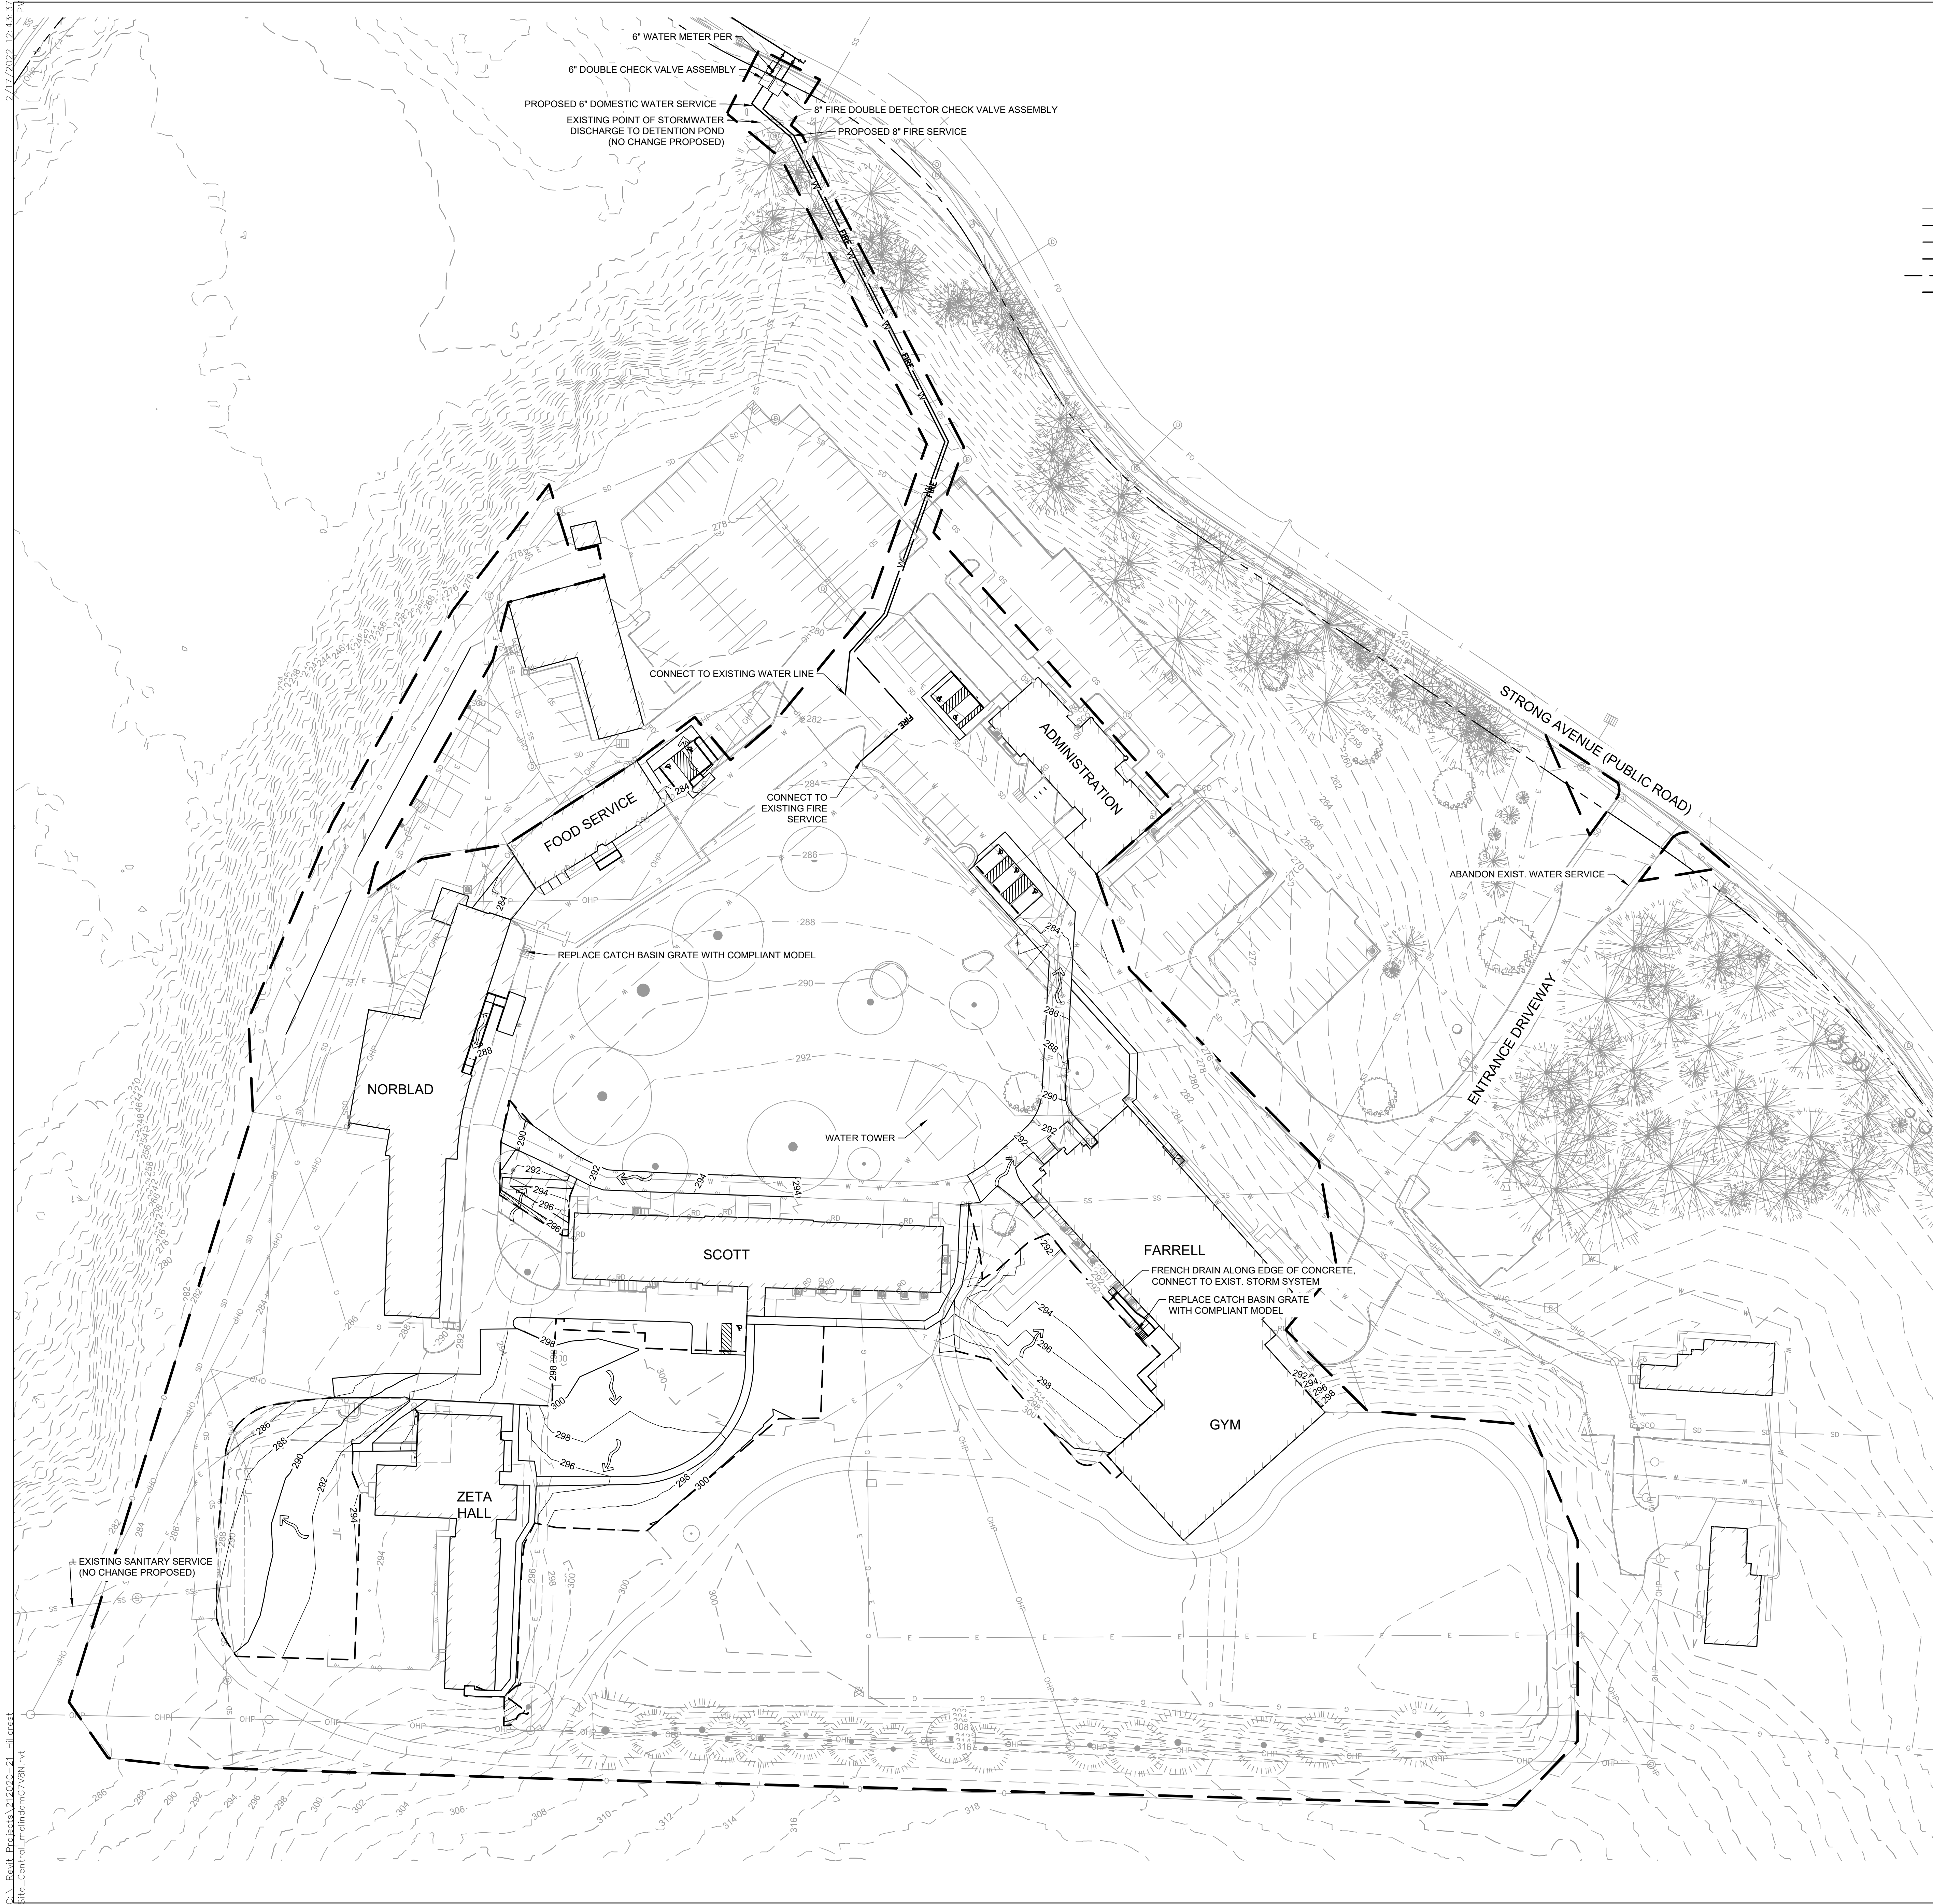

GENERAL NOTES:
1. THE MAXIMUM FIRE FLOW NEEDS ARE 3,875 GPM.
2. THE MAXIMUM WATER METER SIZE IS 6".

LEGEND
— 200 — EXISTING CONTOUR
— 200 — PROPOSED CONTOUR
— — — PROPERTY LINE
— W — PROPOSED 6" DOMESTIC WATER SERVICE
— FIRE — PROPOSED 8" FIRE SERVICE
— — — GRADING LIMITS

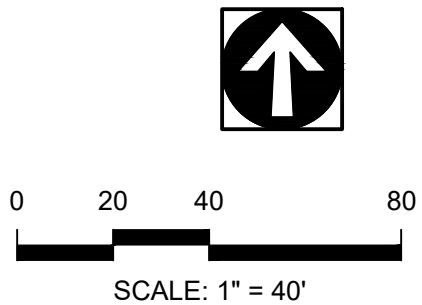

NOT FOR
CONSTRUCTION



38 NORTHWEST DAVIS, SUITE 300
PORTLAND, OR 97209
503.245.7100

1505 5TH AVE, SUITE
800 TITL, WA 98101
206.576.1600

1014 HOWARD STREET
SAN FRANCISCO, CA 94103
415.252.7063

ANKROM MOISAN ARCHITECTS, INC.



DAVID EVANS
AND ASSOCIATES INC.
2100 S River Parkway, Suite 100
Portland Oregon 97201
Phone: 503.223.6663

HILLCREST BEHAVIORAL HEALTH
2450 STRONG ROAD SE, SALEM, OR 97302
OREGON BEHAVIORAL HOSPITAL, LLC

REVISION	DATE	REASON FOR ISSUE

PRELIMINARY
GRADING AND
UTILITY PLAN

SITE PLAN REVIEW

DATE 03/01/22	PROJECT NUMBER 212020
SHEET NUMBER	C3.00