




LEGEND

- EXISTING SEWER LINE
- SD—SD—SD—SD— EXISTING STORM DRAIN
- W—W—W—W—W— EXISTING WATER LINE

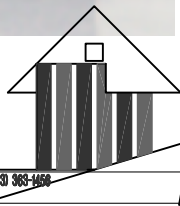

RONALD
JAMES
PED
ARCHITECT P.C.

 503.365.1600

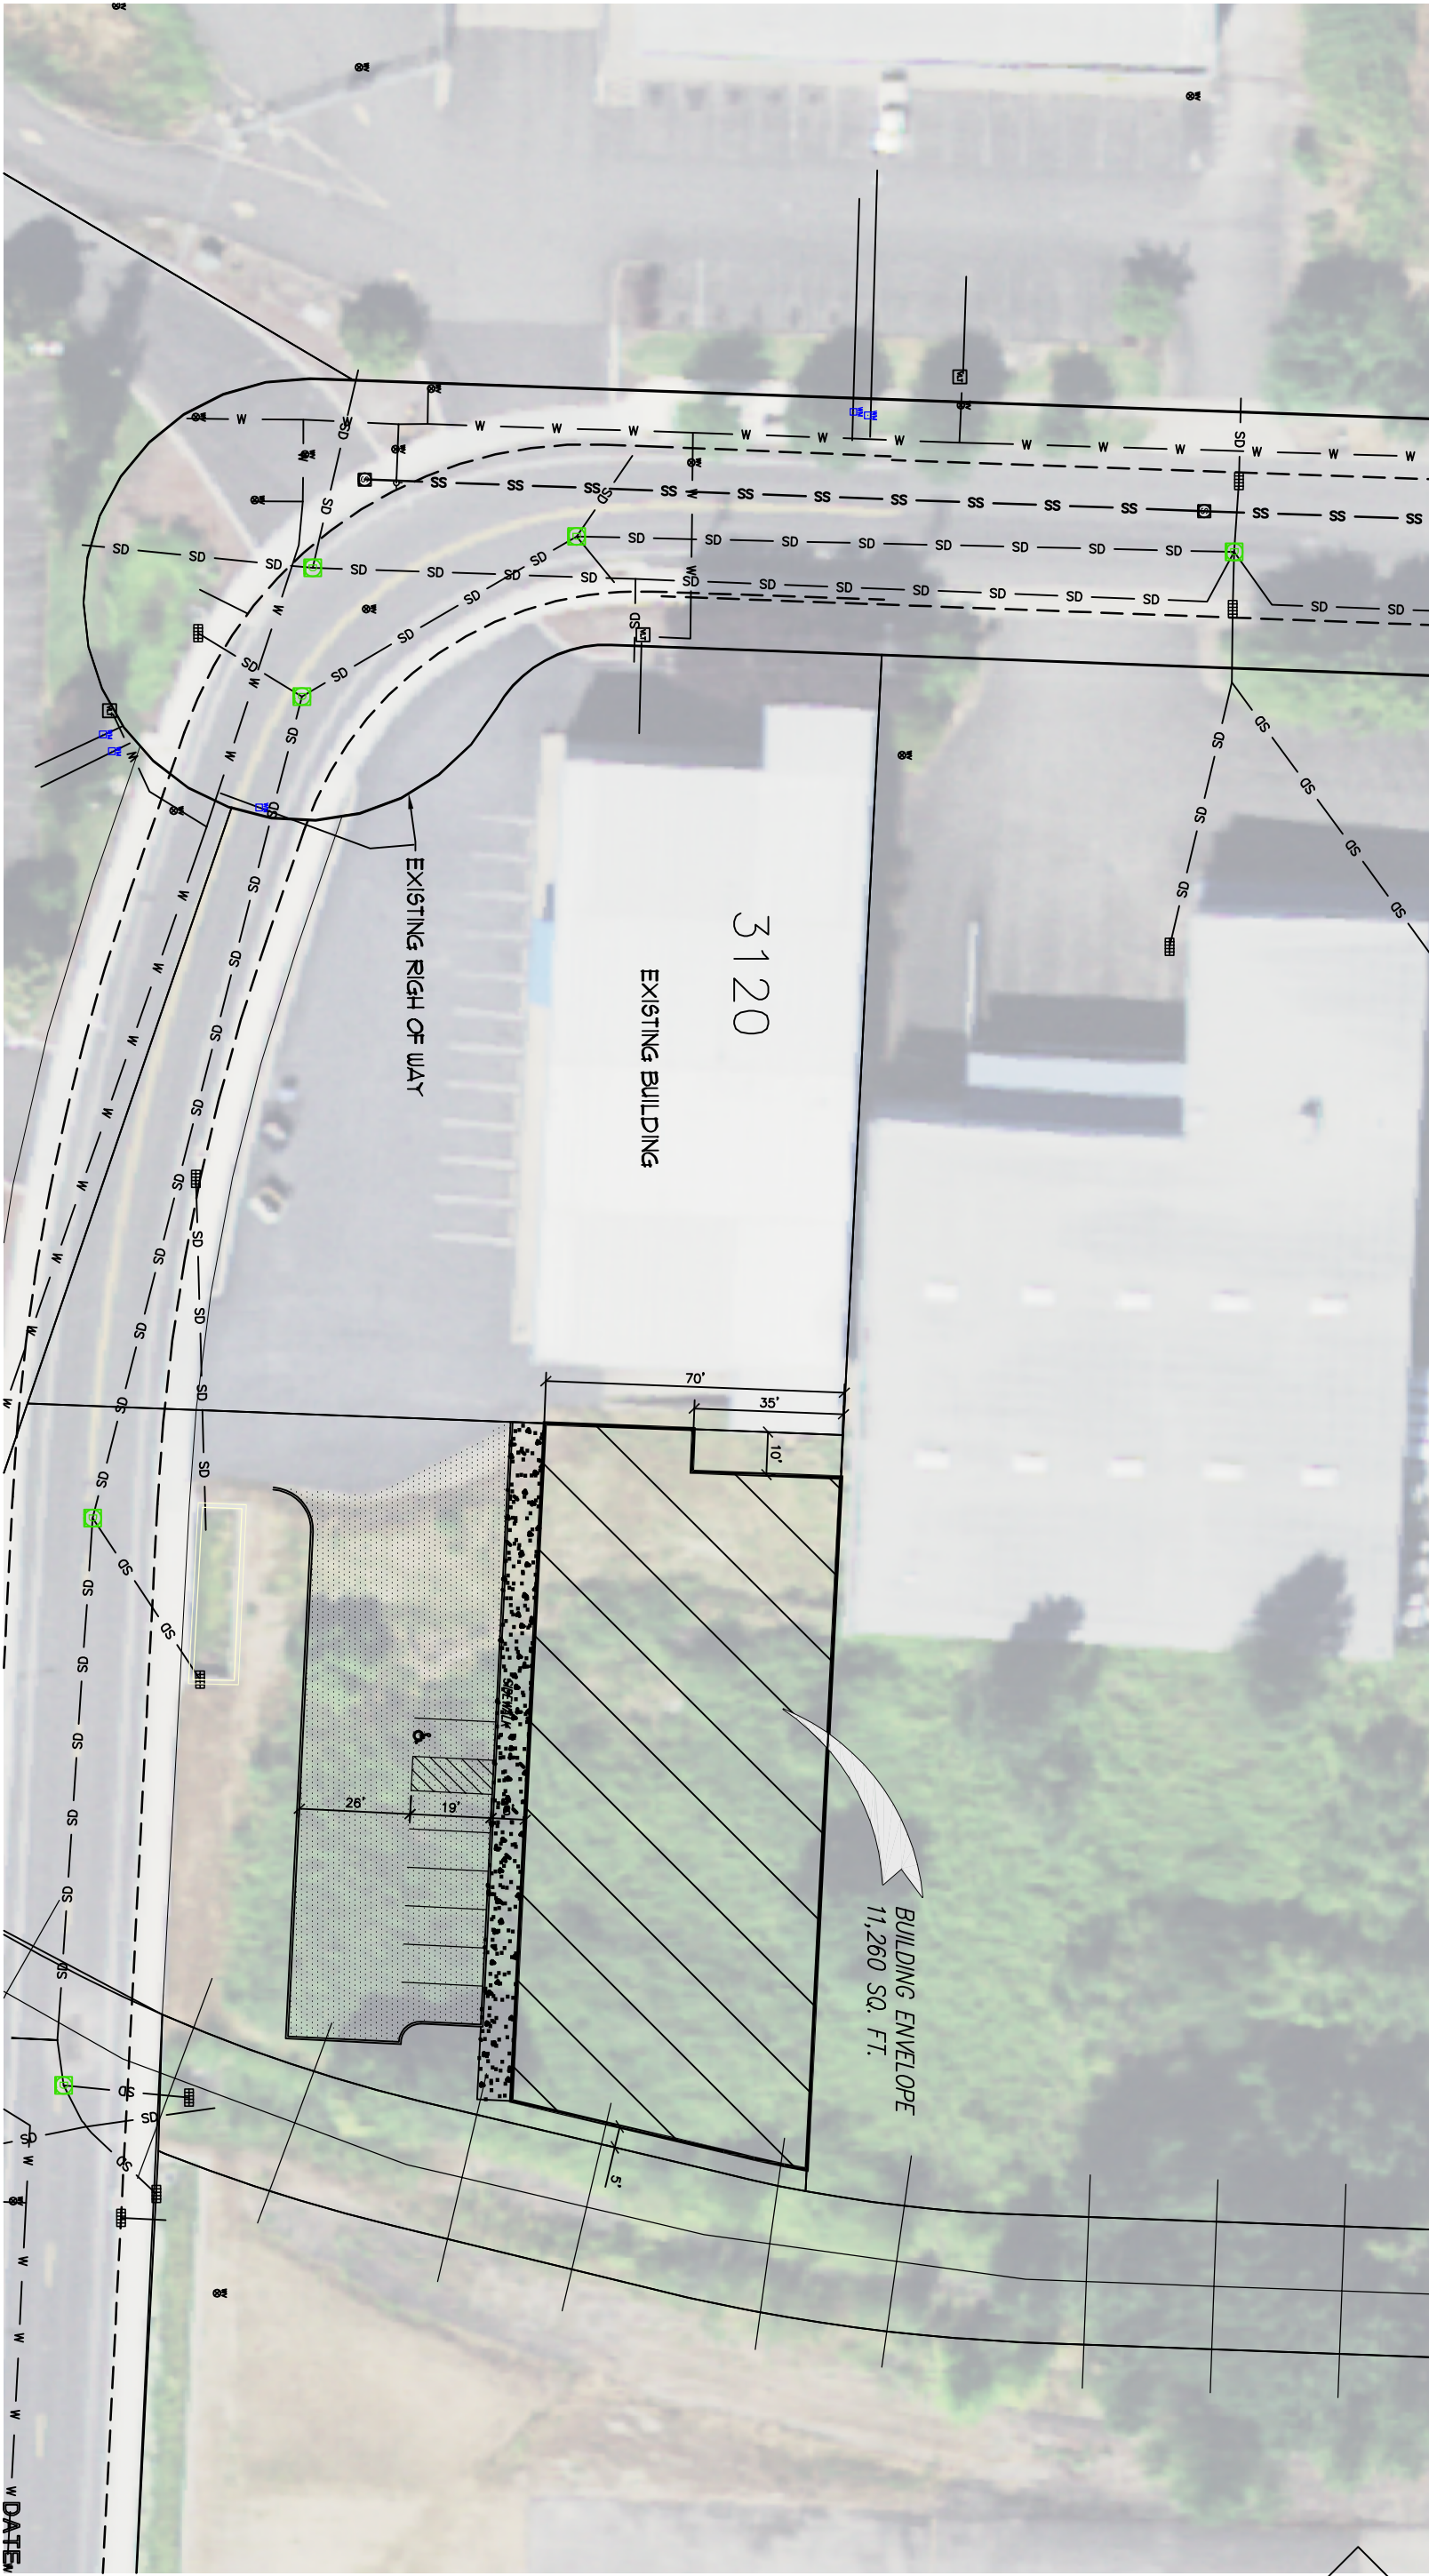

UTILITY PLAN

SCALE : 1" = 40'-0"



Site Plan Review Class 2

Thermal Supply

3120 22nd St SE, Salem, OR 97302

DATE: 04.22.2022

DRAWN: glm

JOB NO.: 2181

SPR 4