



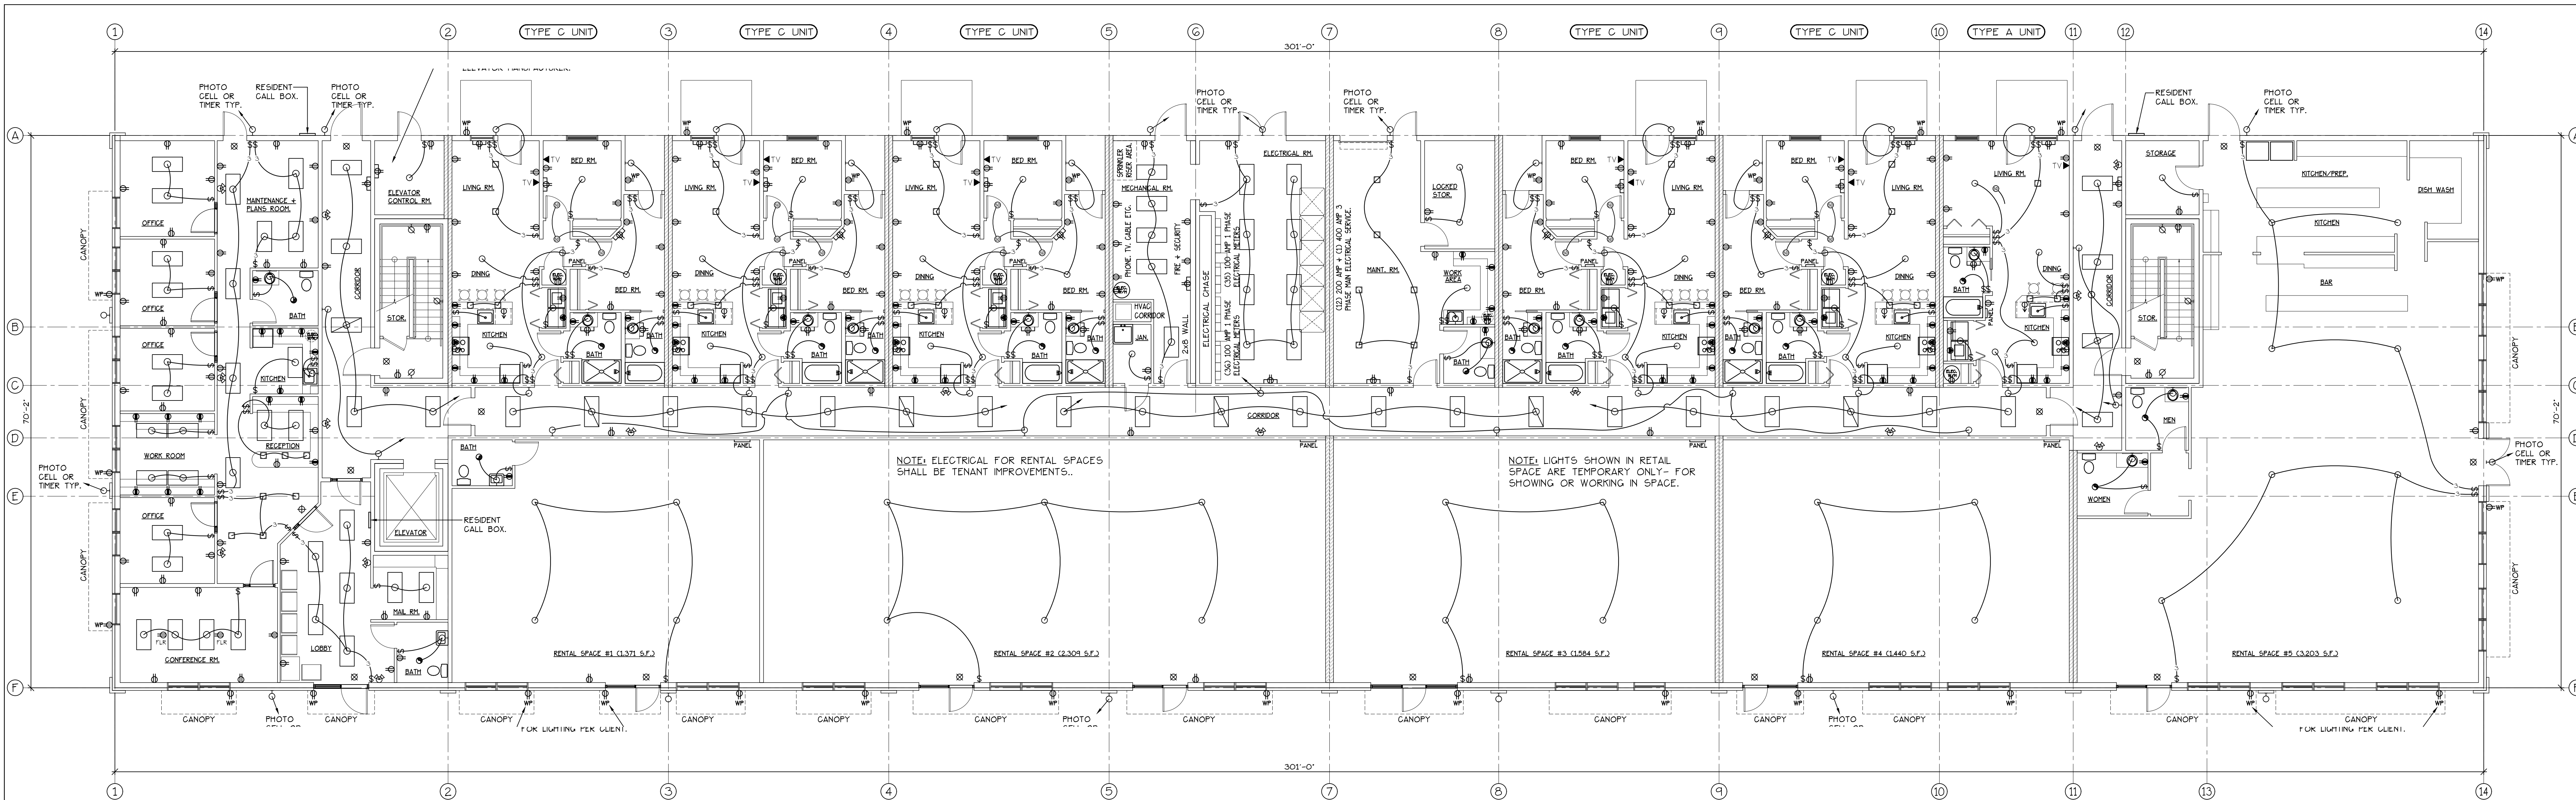

GROUND FLOOR ELECTRICAL PLAN

SCALE: 1/8" = 1'-0"

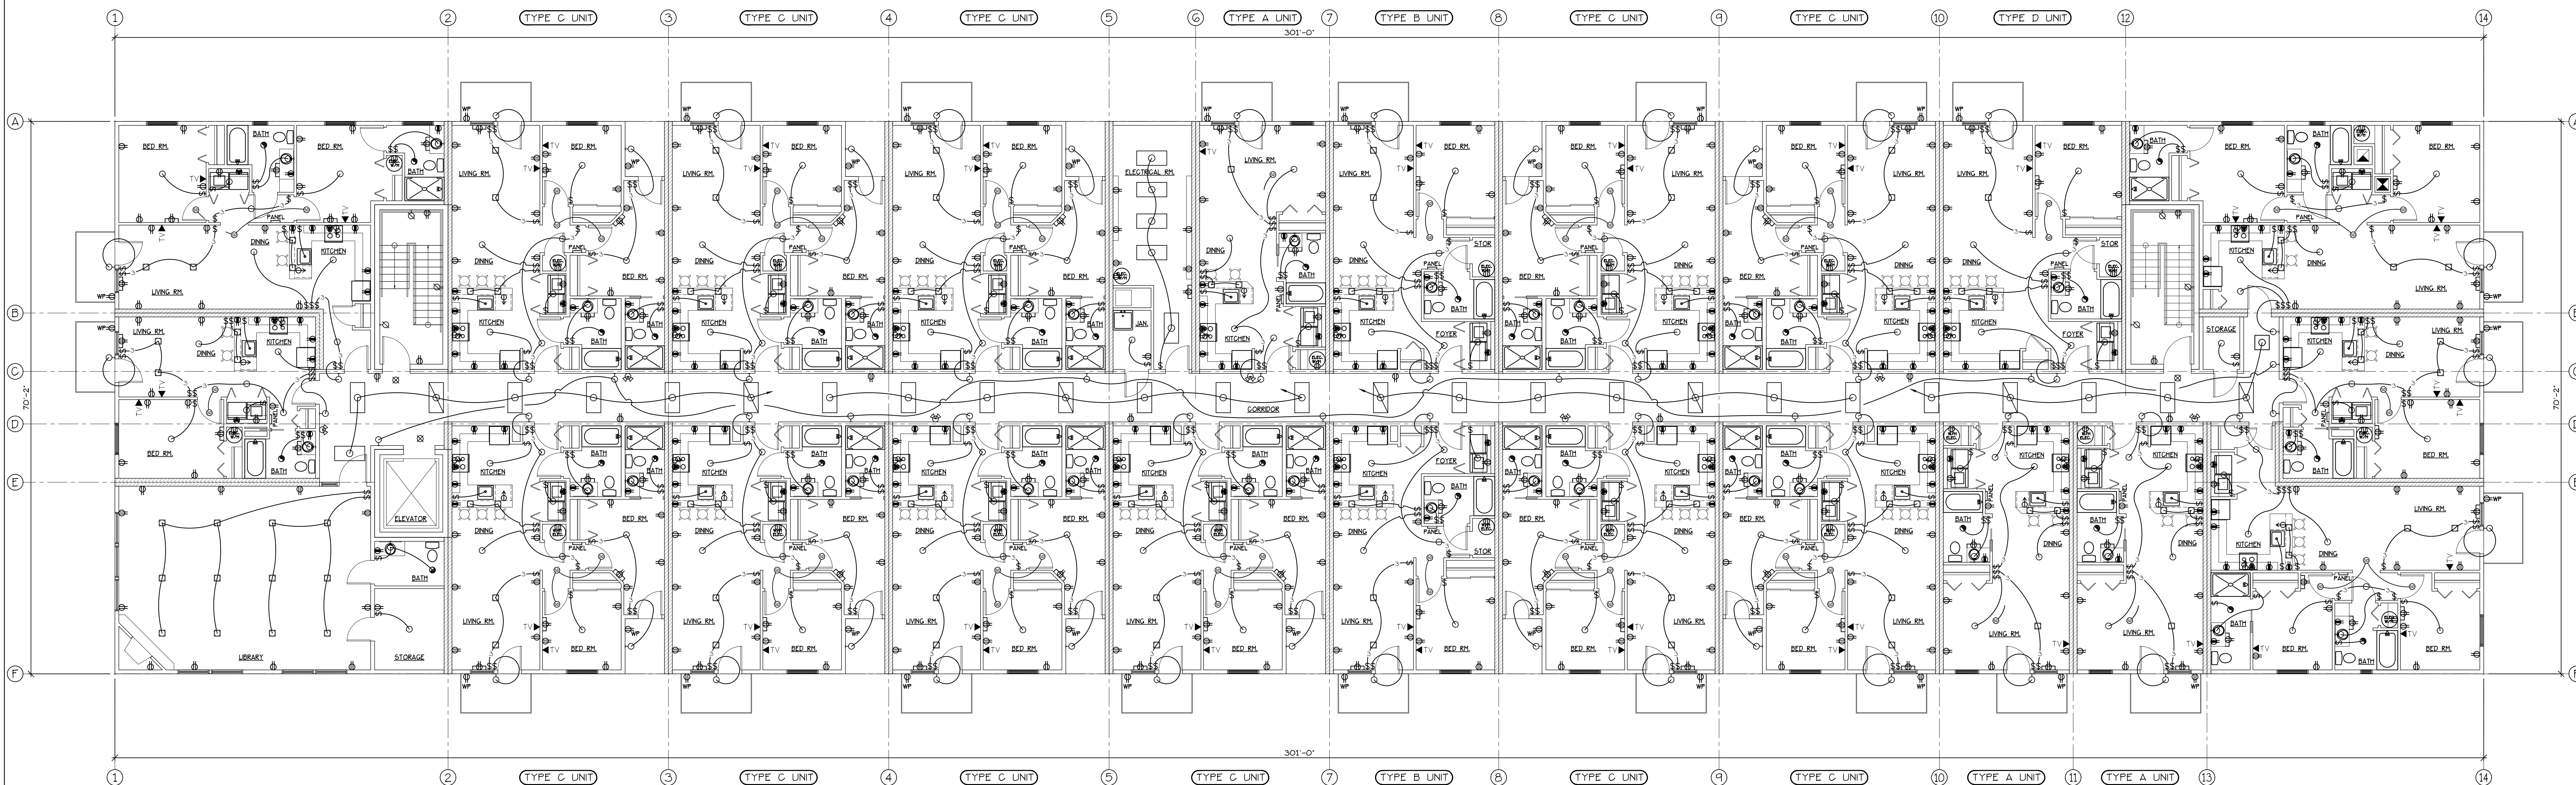

SECOND FLOOR ELECTRICAL PLAN

SCALE: 1/8" = 1'-0"

ELECTRICAL SYMBOL LEGEND			
110 V DUPLEX OUTLET.	TELEVISION.	24"x48" FLORESCENT LIGHT FIXTURE.	
WATER PROOF 110 V DUPLEX OUTLET.	ELECTRICAL PANEL.	24"x48" FLORESCENT LIGHT FIXTURE.	
110 V SUPPLY WALL/TOE KICK HEATER + MN-SPLIT.	SMOKE/CARBON MONOXIDE DETECTOR.	24"x48" FLORESCENT LIGHT FIXTURE ON EMERGENCY CIRCUIT.	
110 V DUPLEX OUTLET ABOVE COUNTER (44" MAX).	EXHAUST FAN W/ FIRE DAMPER.	FLOOD LIGHT FIXTURE ON EMERGENCY CIRCUIT.	
220 V OUTLET.	SURFACE MOUNTED LIGHT FIXTURE.	EXIT SIGN WITH EMERGENCY LIGHTING.	
220 V SERVICE (DISH WASHER + RANGE).	RECESSED CAN LIGHT FIXTURE.		
SINGLE POLE SWITCH.	WALL MOUNTED LIGHT FIXTURE.		
3 WAY SWITCH.	WALL MOUNTED LIGHT FIXTURE ON EMERGENCY CIRCUIT.		

- ELECTRICAL NOTES:
- MAXIMUM THERMOSTAT, SWITCH + RECEPTACLE OUTLET MOUNTING HT. = 48" ABOVE FINISH FLOOR.
 - MINIMUM RECEPTACLE OUTLET, PHONE, ETC. MOUNTING HT. = 15" ABOVE FINISH FLOOR.
 - MAXIMUM SWITCH, RECEPTACLE OUTLET ETC. MOUNTING HT. = 44" AT COUNTER TOPS.
 - GFCI PROTECTION SHALL BE IN ALL BATHROOM AND KITCHEN RECEPTACLE OUTLETS AT COUNTER TOPS. GFCI PROTECTION ALSO SHALL BE IN ANY AREA WHERE WATER USAGE IS PROPOSED AT COUNTER TOPS.
 - WITHIN EACH RESIDENT UNIT THE COMBINATION SMOKE/CARBON MONOXIDE DETECTORS TO BE WIRING FOR COLLECTIVE ALARM UPON THE ACTIVATION OF ANY ONE. DETECTORS TO BE WIRING TO 110V WITH BATTERY BACK-UP.


SMOKE DETECTORS:

(F) 107.2.10.3 SMOKE ALARMS, SINGLE AND MULTIPLE-STATION SMOKE ALARMS SHALL BE INSTALLED IN ACCORDANCE WITH SECTION 107.2.11.

(F) 107.2.11 SINGLE AND MULTIPLE-STATION SMOKE ALARMS, LISTED SINGLE AND MULTIPLE-STATION SMOKE ALARMS COMPLYING WITH UL 217 SHALL BE INSTALLED IN ACCORDANCE WITH SECTION 107.2.12.

ANTHONY'S PLACE
APARTMENTS

GROUND AND SECOND
FLOOR ELECTRICAL

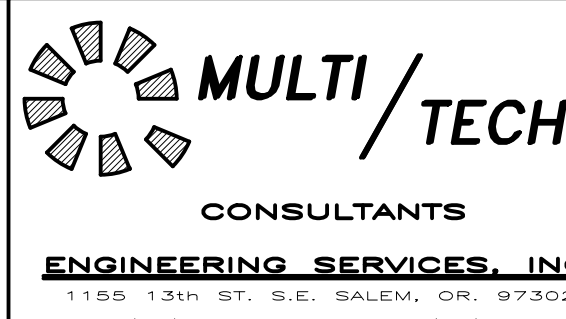

NO CHANGES, MODIFICATIONS OR REPRODUCTIONS TO BE MADE TO THESE DRAWINGS WITHOUT WRITTEN AUTHORIZATION FROM THE DESIGN ENGINEER.

DIMENSIONS & NOTES TAKE PRECEDENCE OVER GRAPHICAL REPRESENTATION.

Design: P.L.M.
Drawn: G.D./A.R.T.
Checked: M.D.G.
Date: Feb-22
Scale: AS SHOWN



A1.51