



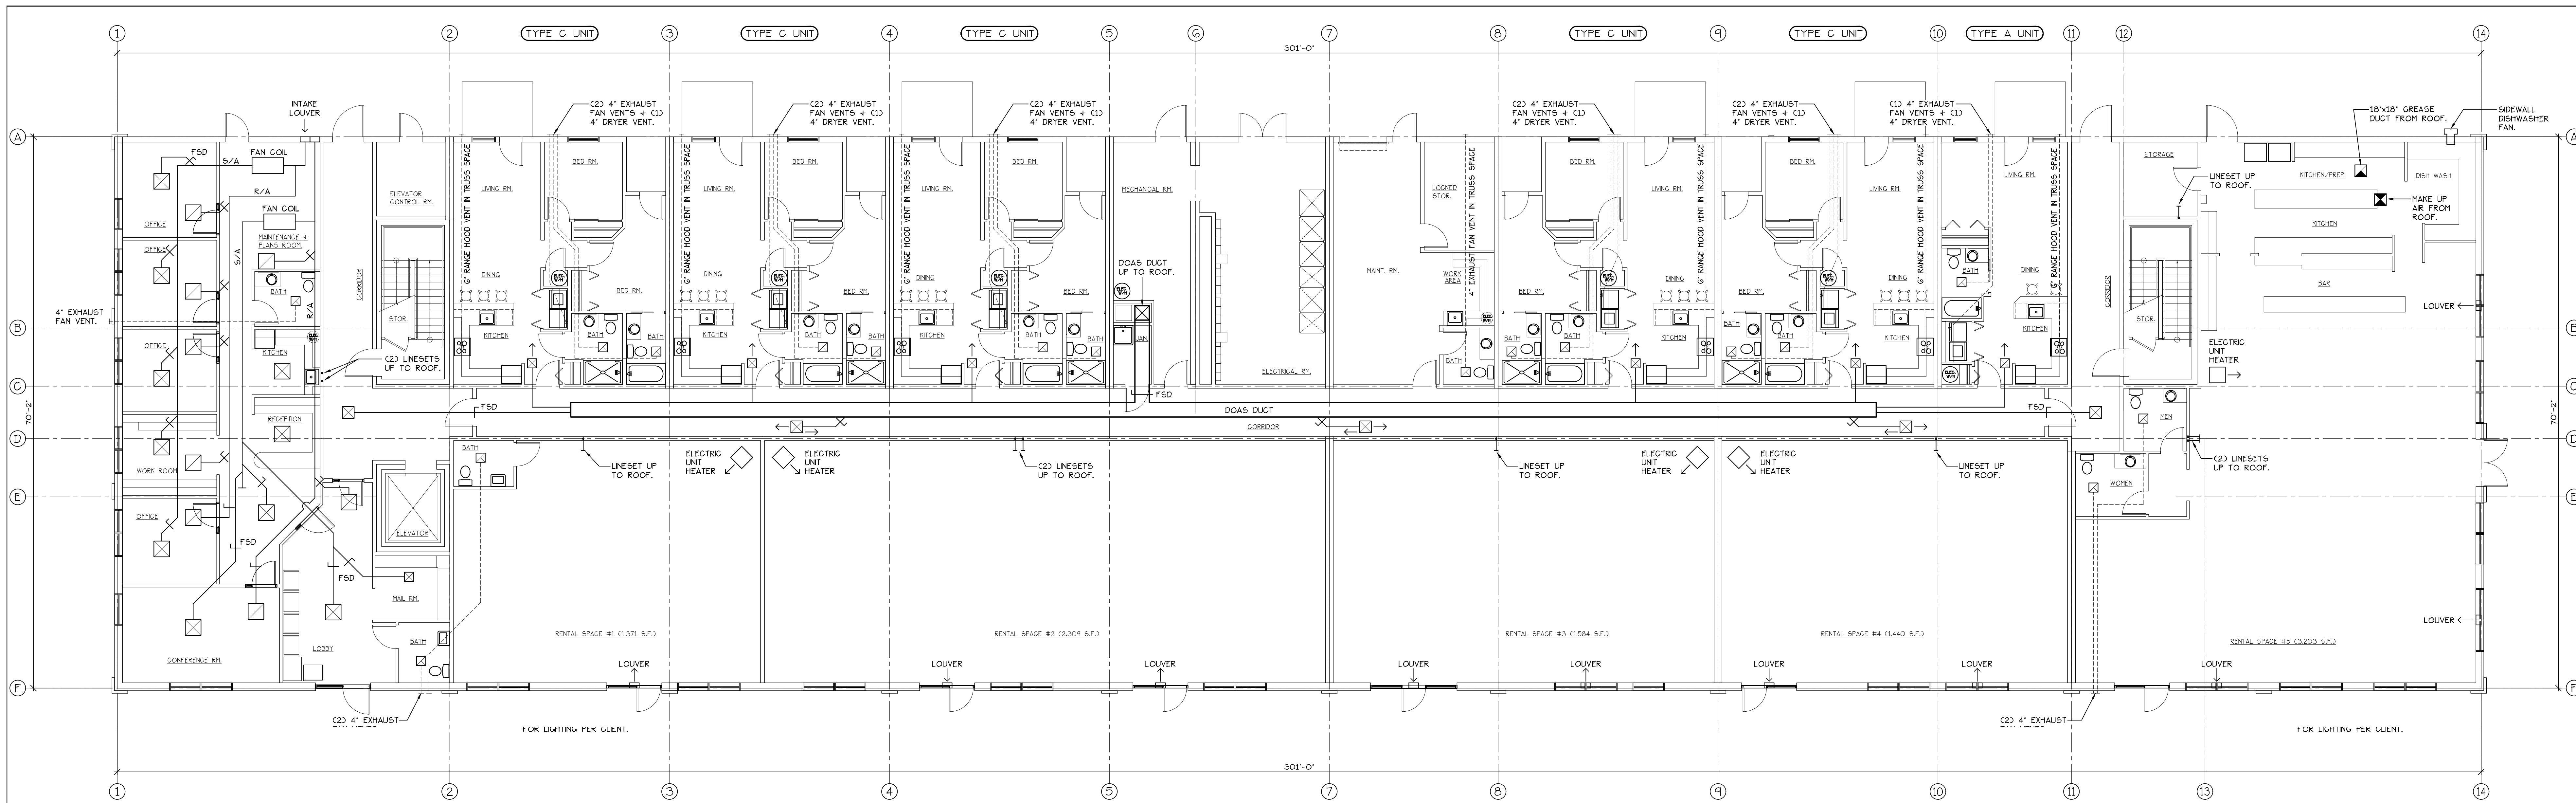

GROUND FLOOR ELECTRICAL PLAN

SCALE: 1/8" = 1'-0"

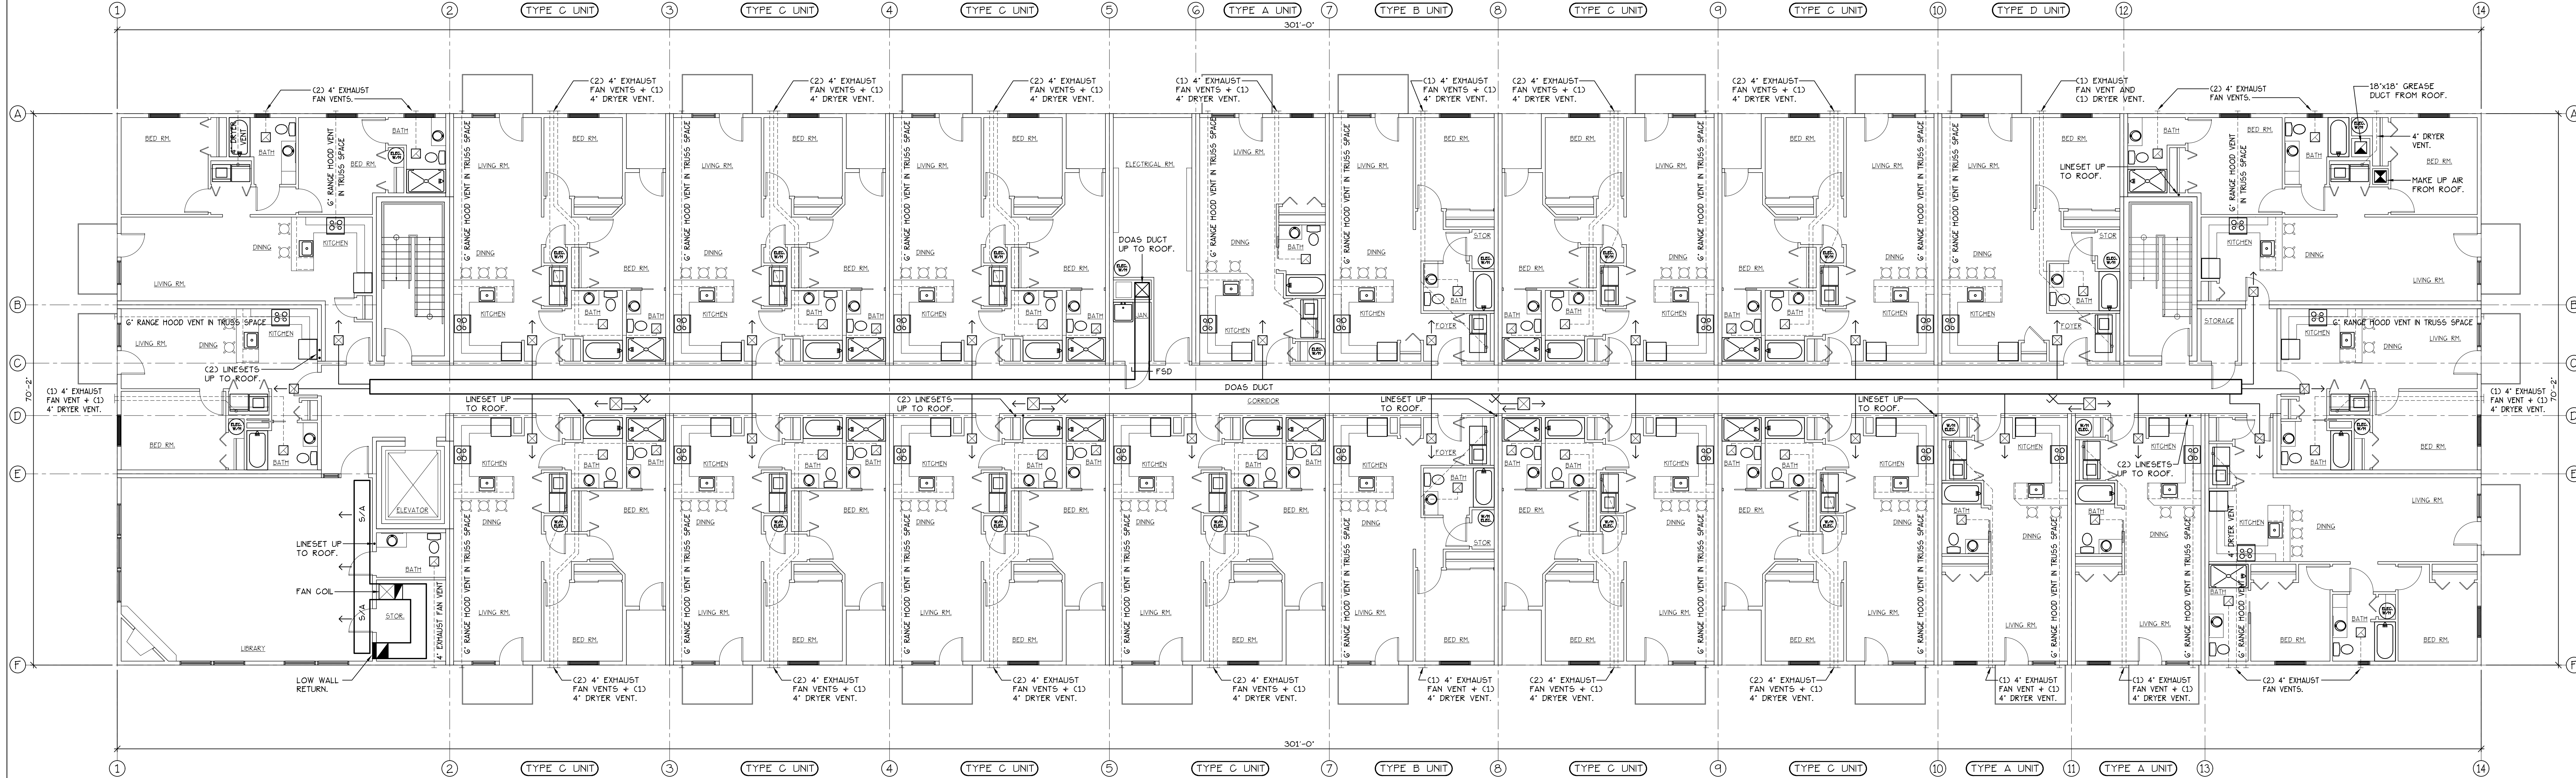

SECOND FLOOR HVAC SCHEMATIC

SCALE: 1/8" = 1'-0"

ALL EXHAUST VENTING THAT PENETRATES RATED FLOOR/CEILING ASSEMBLY TO HAVE APPROVED FIRE DAMPER AT POINT OF PENETRATION.

HVAC SYMBOL + ABBREVIATION LEGEND			
	SUPPLY AIR DUCT.		FIRE AND SMOKE DAMPER.
	RETURN AIR DUCT.		FIRE AND SMOKE DAMPER.
	EXHAUST AIR DUCT.		LINESET UP TO ROOF.
	MAKE UP AIR DUCT.		LOUVER PER PLAN.
	GREASE EXHAUST DUCT		SUPPLY AIR.
			DEDICATED OUTSIDE AIR SYSTEM.

ANTHONY'S PLACE
APARTMENTS

GROUND AND SECOND
FLOOR HVAC

CONSULTANTS
ENGINEERING SERVICES, INC.
1100 S. 33RD ST. SUITE 200
PHOENIX, AZ 85004
PHONE: (602) 363-1122 FAX: (602) 364-1200

NO CHANGES, MODIFICATIONS OR REPRODUCTIONS TO BE MADE TO THESE DRAWINGS WITHOUT WRITTEN AUTHORIZATION FROM THE DESIGN ENGINEER.

DIMENSIONS & NOTES TAKE PRECEDENCE OVER GRAPHICAL REPRESENTATION.

Design: P.I.M.
Drawn: G.L.B./A.R.T.
Checked: M.D.G.
Date: Feb-22
Scale: AS SHOWN

BUILDING/FLOOR: A1/THWAC

JOB # 6837

APPROVED FOR CONSTRUCTION
DATE: MAY 1, 2022
BY: MARK D. GORDON
RENEW DATE: JUN 30, 2023

A1.71