



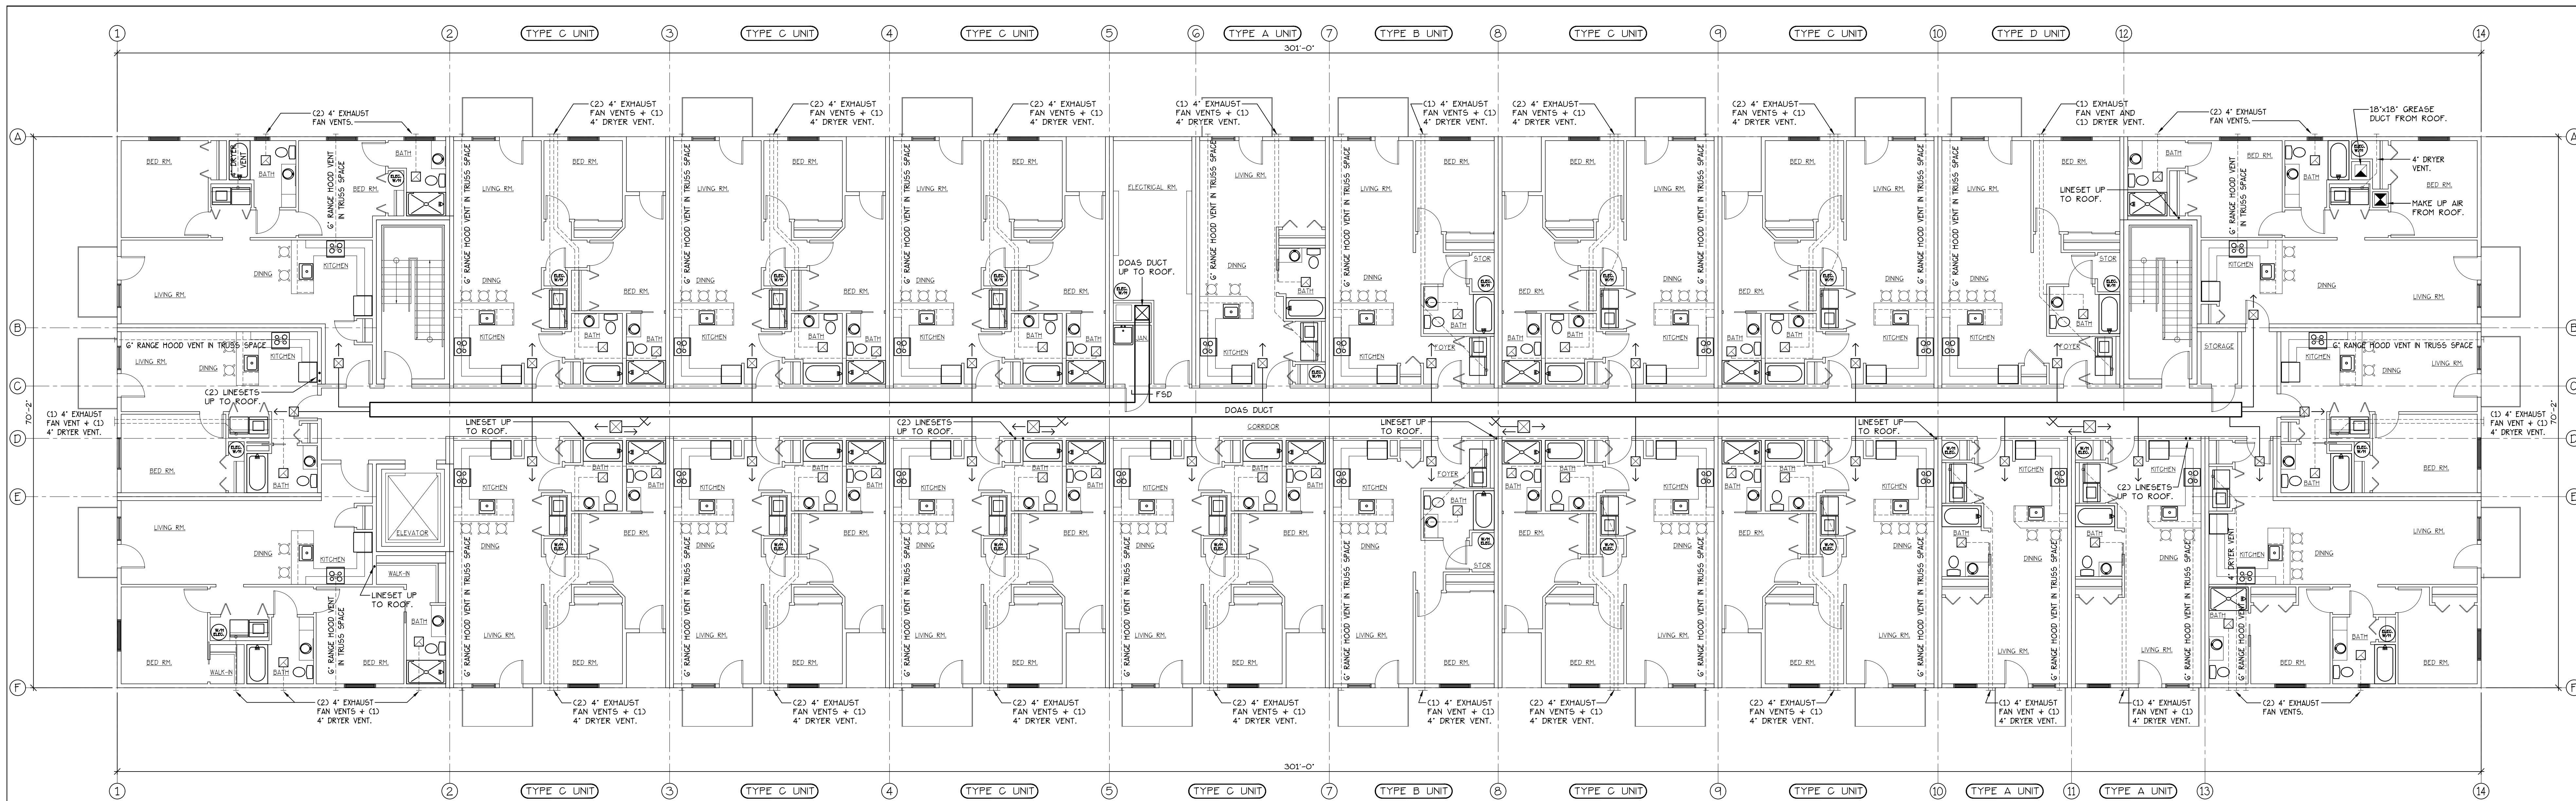

THIRD FLOOR ELECTRICAL PLAN

SCALE: 1/8" = 1'-0"

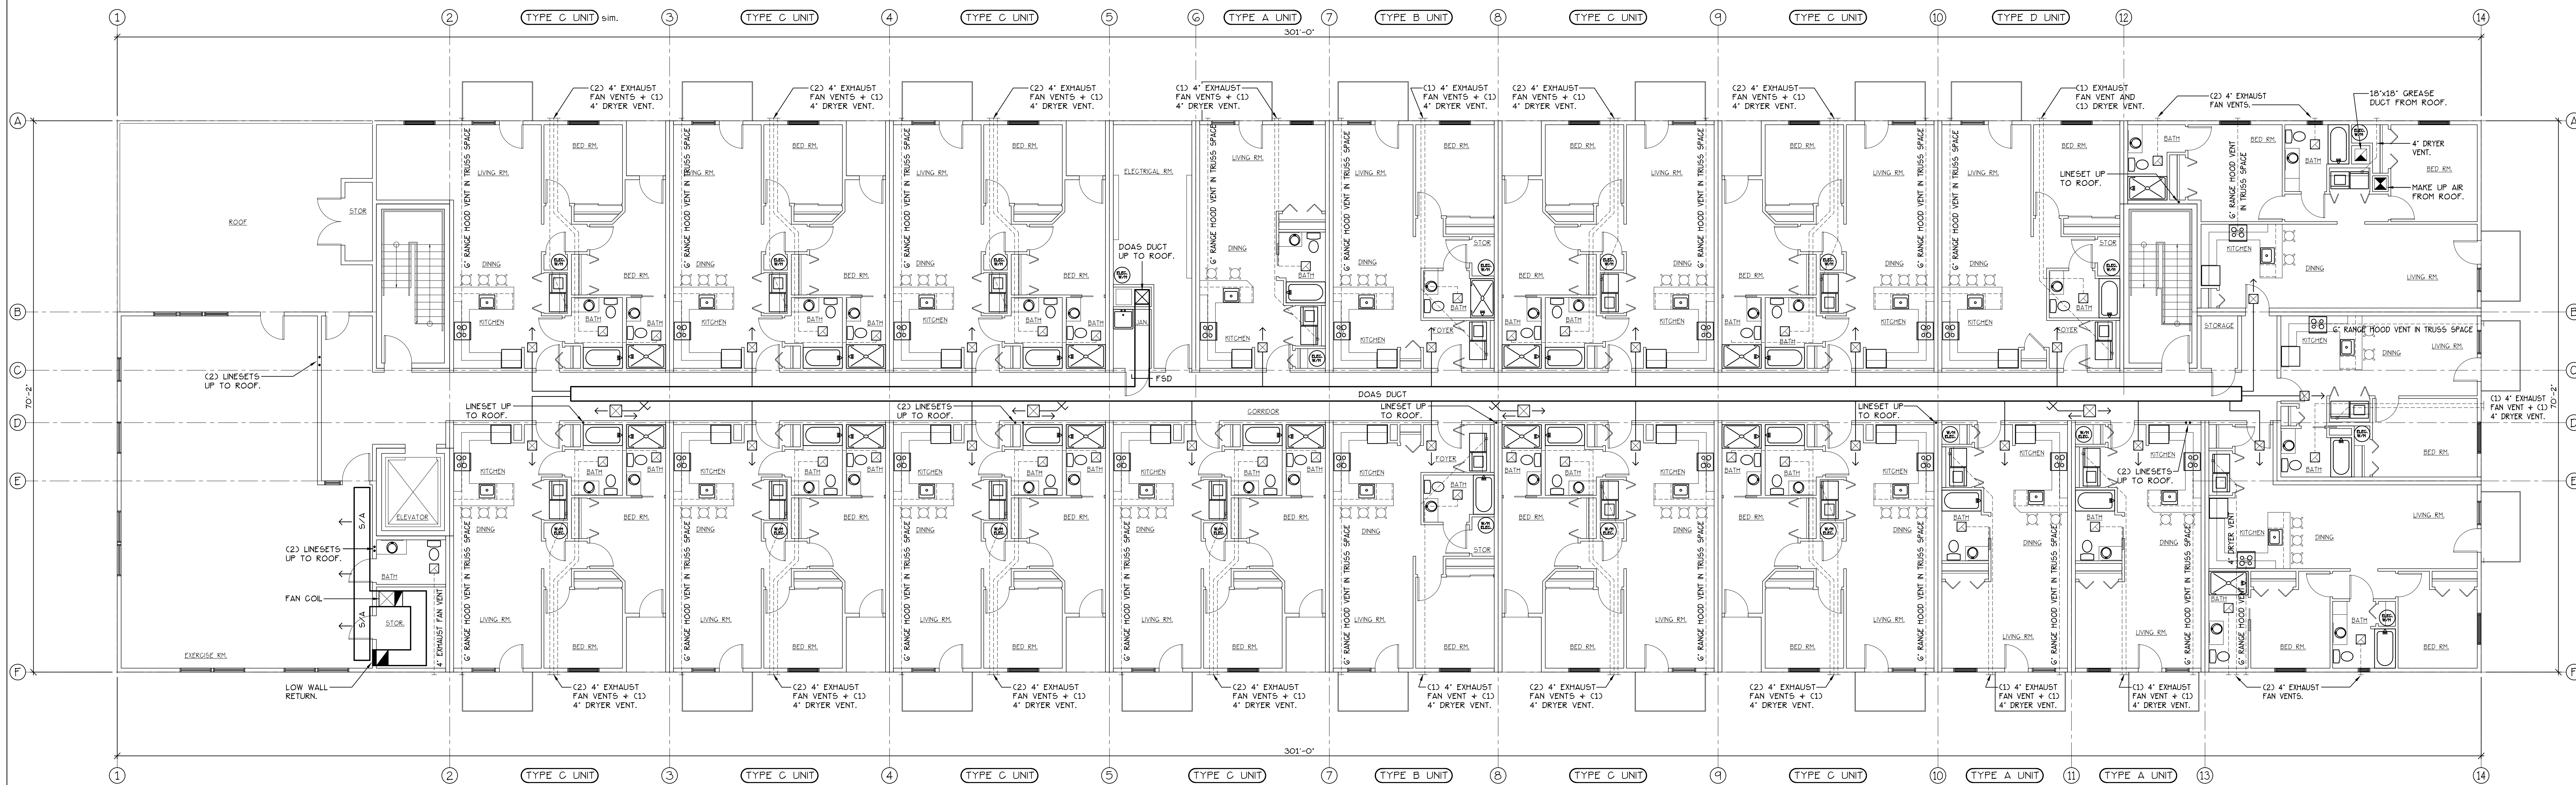


FOURTH FLOOR HVAC SCHEMATIC

SCALE: 1/8" = 1'-0"

HVAC SYMBOL + ABBREVIATION LEGEND					
	SUPPLY AIR DUCT.		FIRE AND SMOKE DAMPER.		EXHAUST OR VENT PIPE PER PLAN.
	RETURN AIR DUCT.		DIRECTION OF AIR FLOW.		FIRE AND SMOKE DAMPER.
	EXHAUST AIR DUCT.		LINESET UP TO ROOF.		RETURN AIR.
	MAKE UP AIR DUCT.		LOUVER PER PLAN.		SUPPLY AIR.
	GREASE EXHAUST DUCT.				DEDICATED OUTSIDE AIR SYSTEM.


ANTHONY'S PLACE
APARTMENTS

THIRD AND FOURTH
FLOOR HVAC

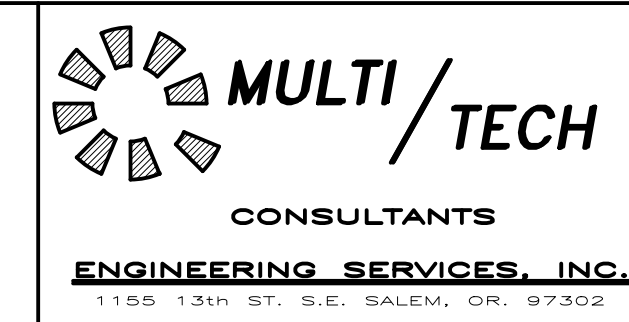

NO CHANGES, MODIFICATIONS OR REPRODUCTIONS TO BE MADE TO THESE DRAWINGS WITHOUT WRITTEN AUTHORIZATION FROM THE DESIGN ENGINEER.
DIMENSIONS & NOTES TAKE PRECEDENCE OVER GRAPHICAL REPRESENTATION.

Design: P.I.M.
Drawn: G.L.B./A.R.T.
Checked: M.D.G.
Date: Feb-22
Scale: AS SHOWN

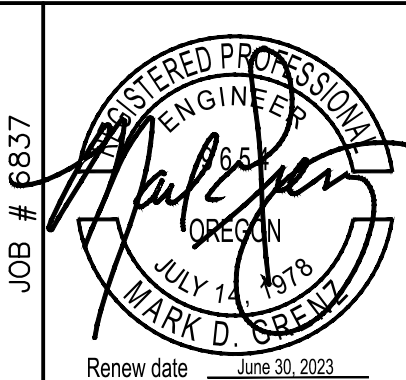

A1.72