

 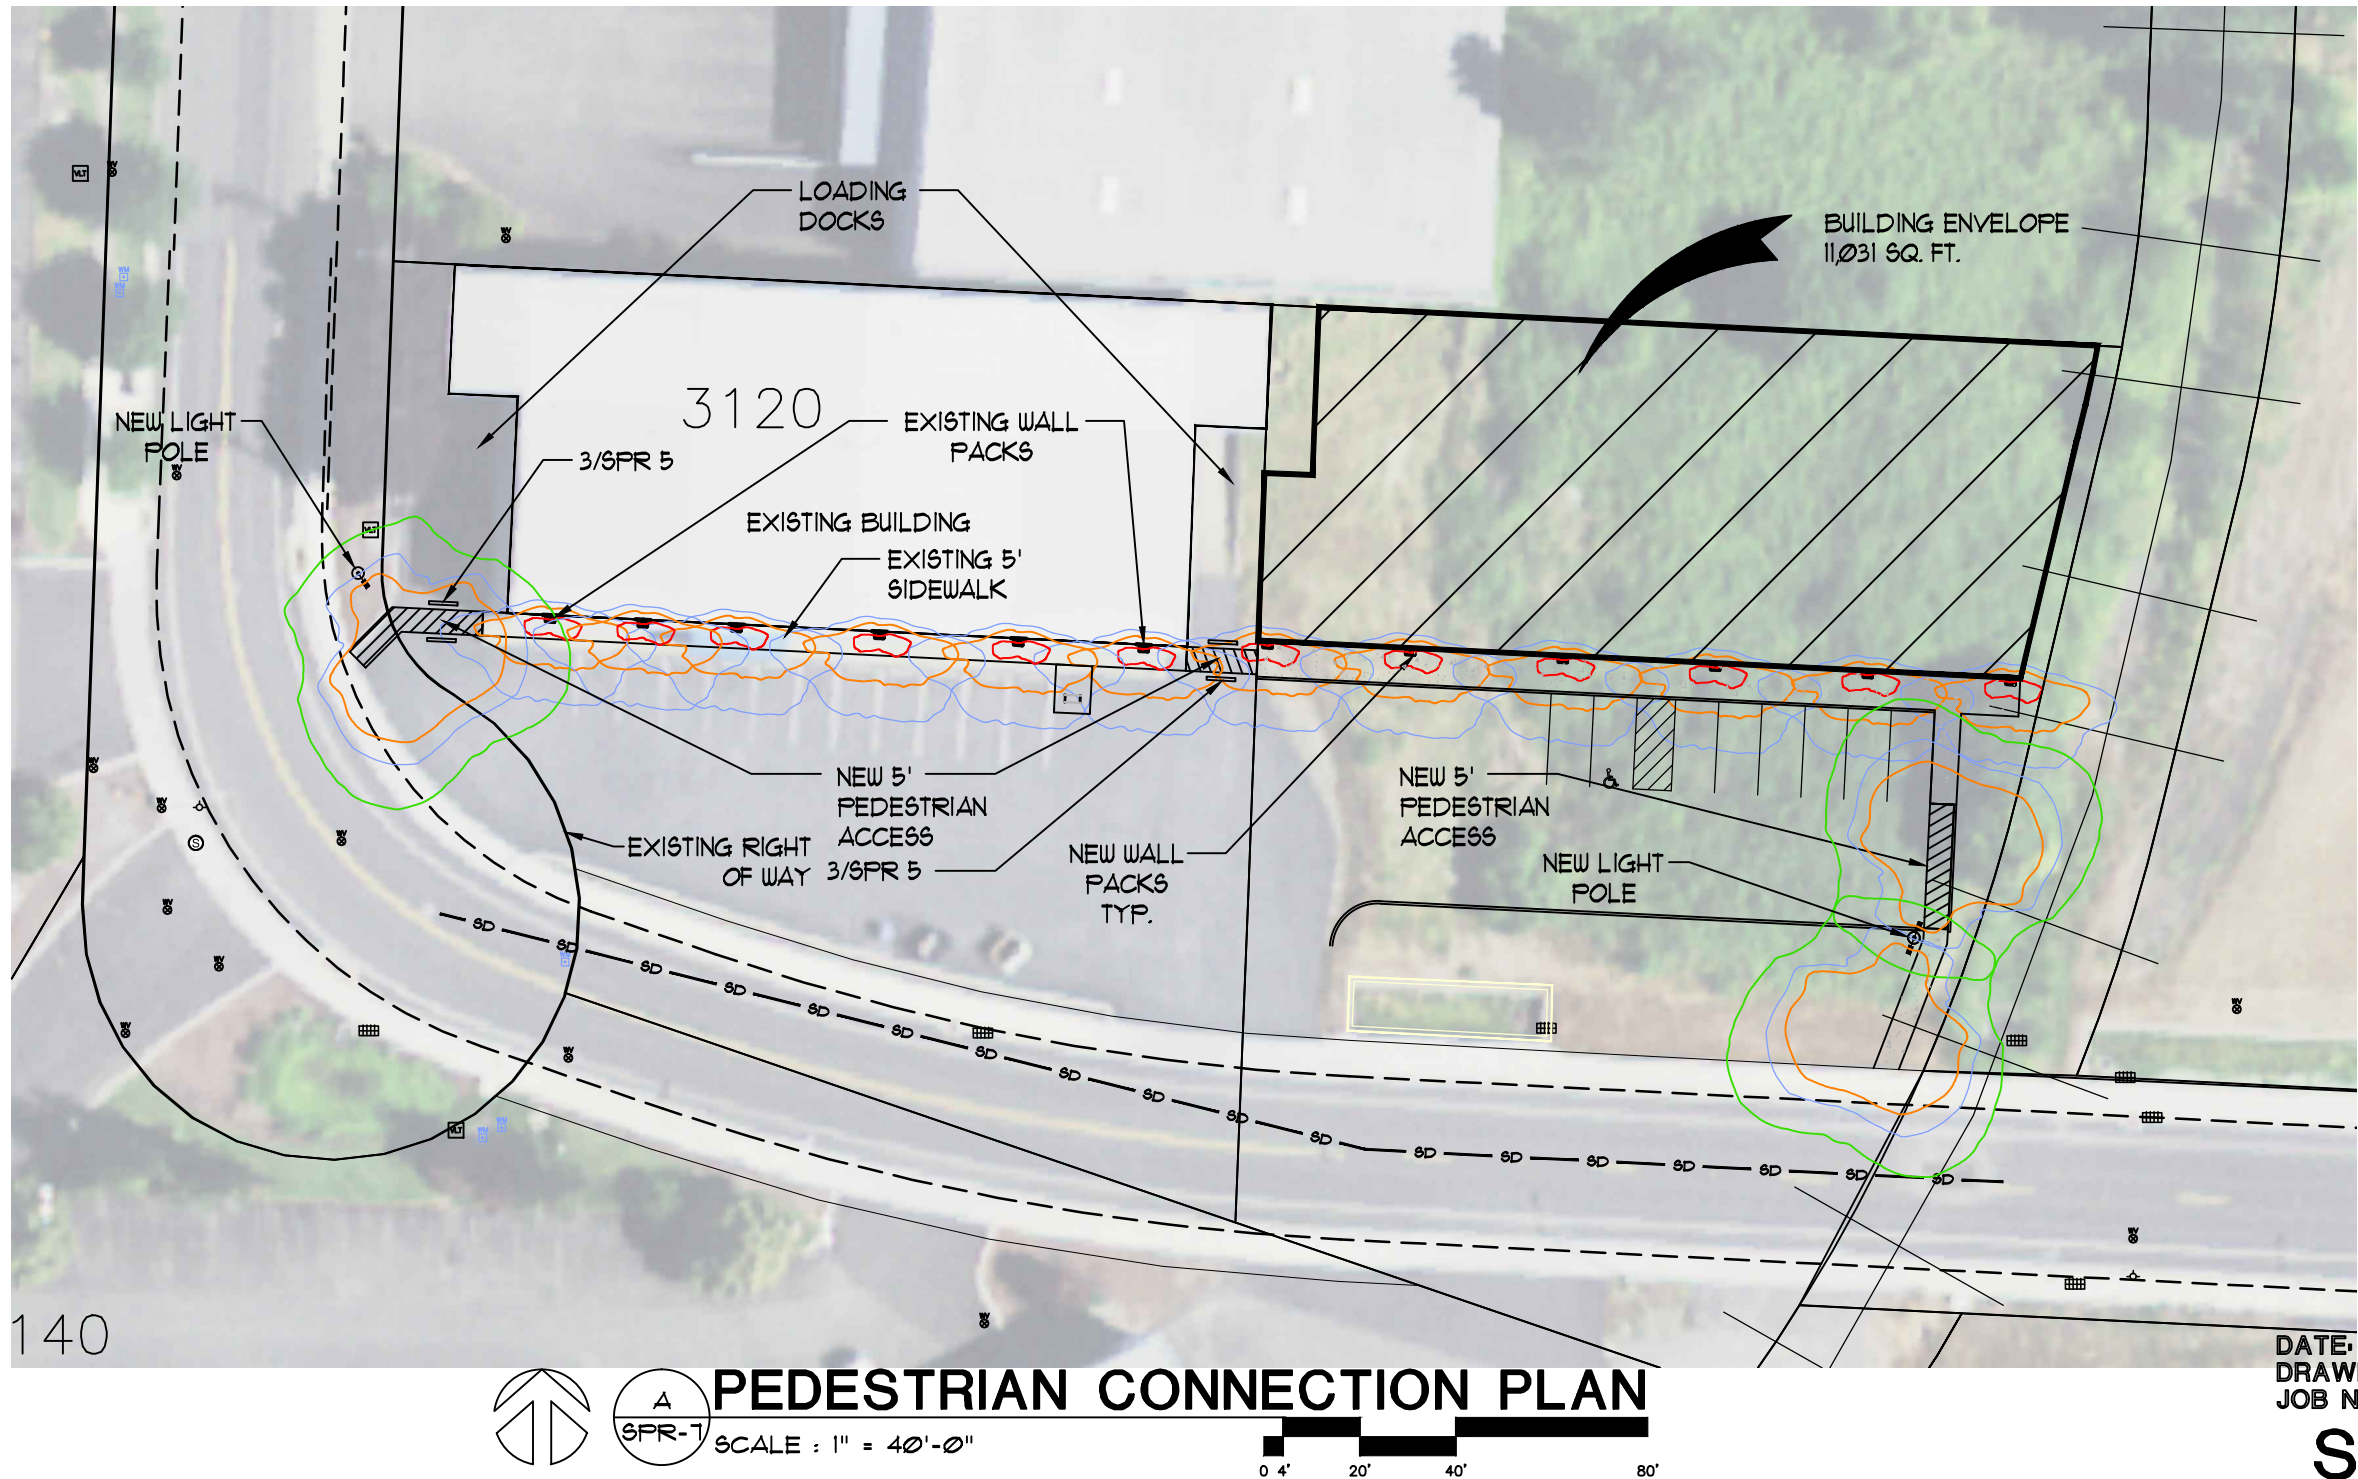


P:\2181 Thermal Supply 3130 22nd\SPR\SPR CLASS 3 04.21.2022.dwg, SPR-7 PED CONNECTION, 6/24/2022 12:30:31 PM, Andy, 1:1

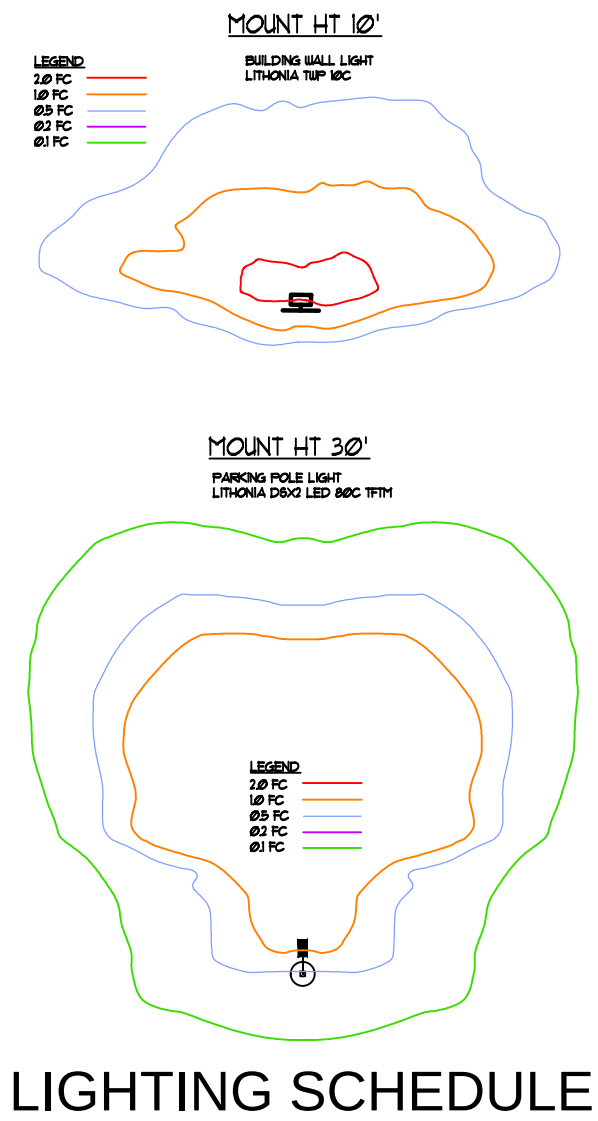



A

SPR-7

PEDESTRIAN CONNECTION PLAN

SCALE : 1" = 40'-0"

0

4'

20'

40'

80'


DATE: 04.22.2022
DRAWN: glm
JOB NO.: 2181

SPR 7

Site Plan Review Class 2

Thermal Supply

3120 22nd St SE, Salem, OR 97302

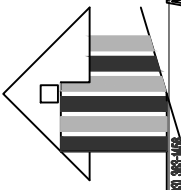

RONALD
JAMES
PED
ARCHITECT PC