


P:\2181 Thermal Supply 3130 22nd\SPR\SPR CLASS 3 04.21.2022.dwg, SPR 4 UTILITY PLAN, 6/24/2022 12:25:33 PM, Andy, 1:1

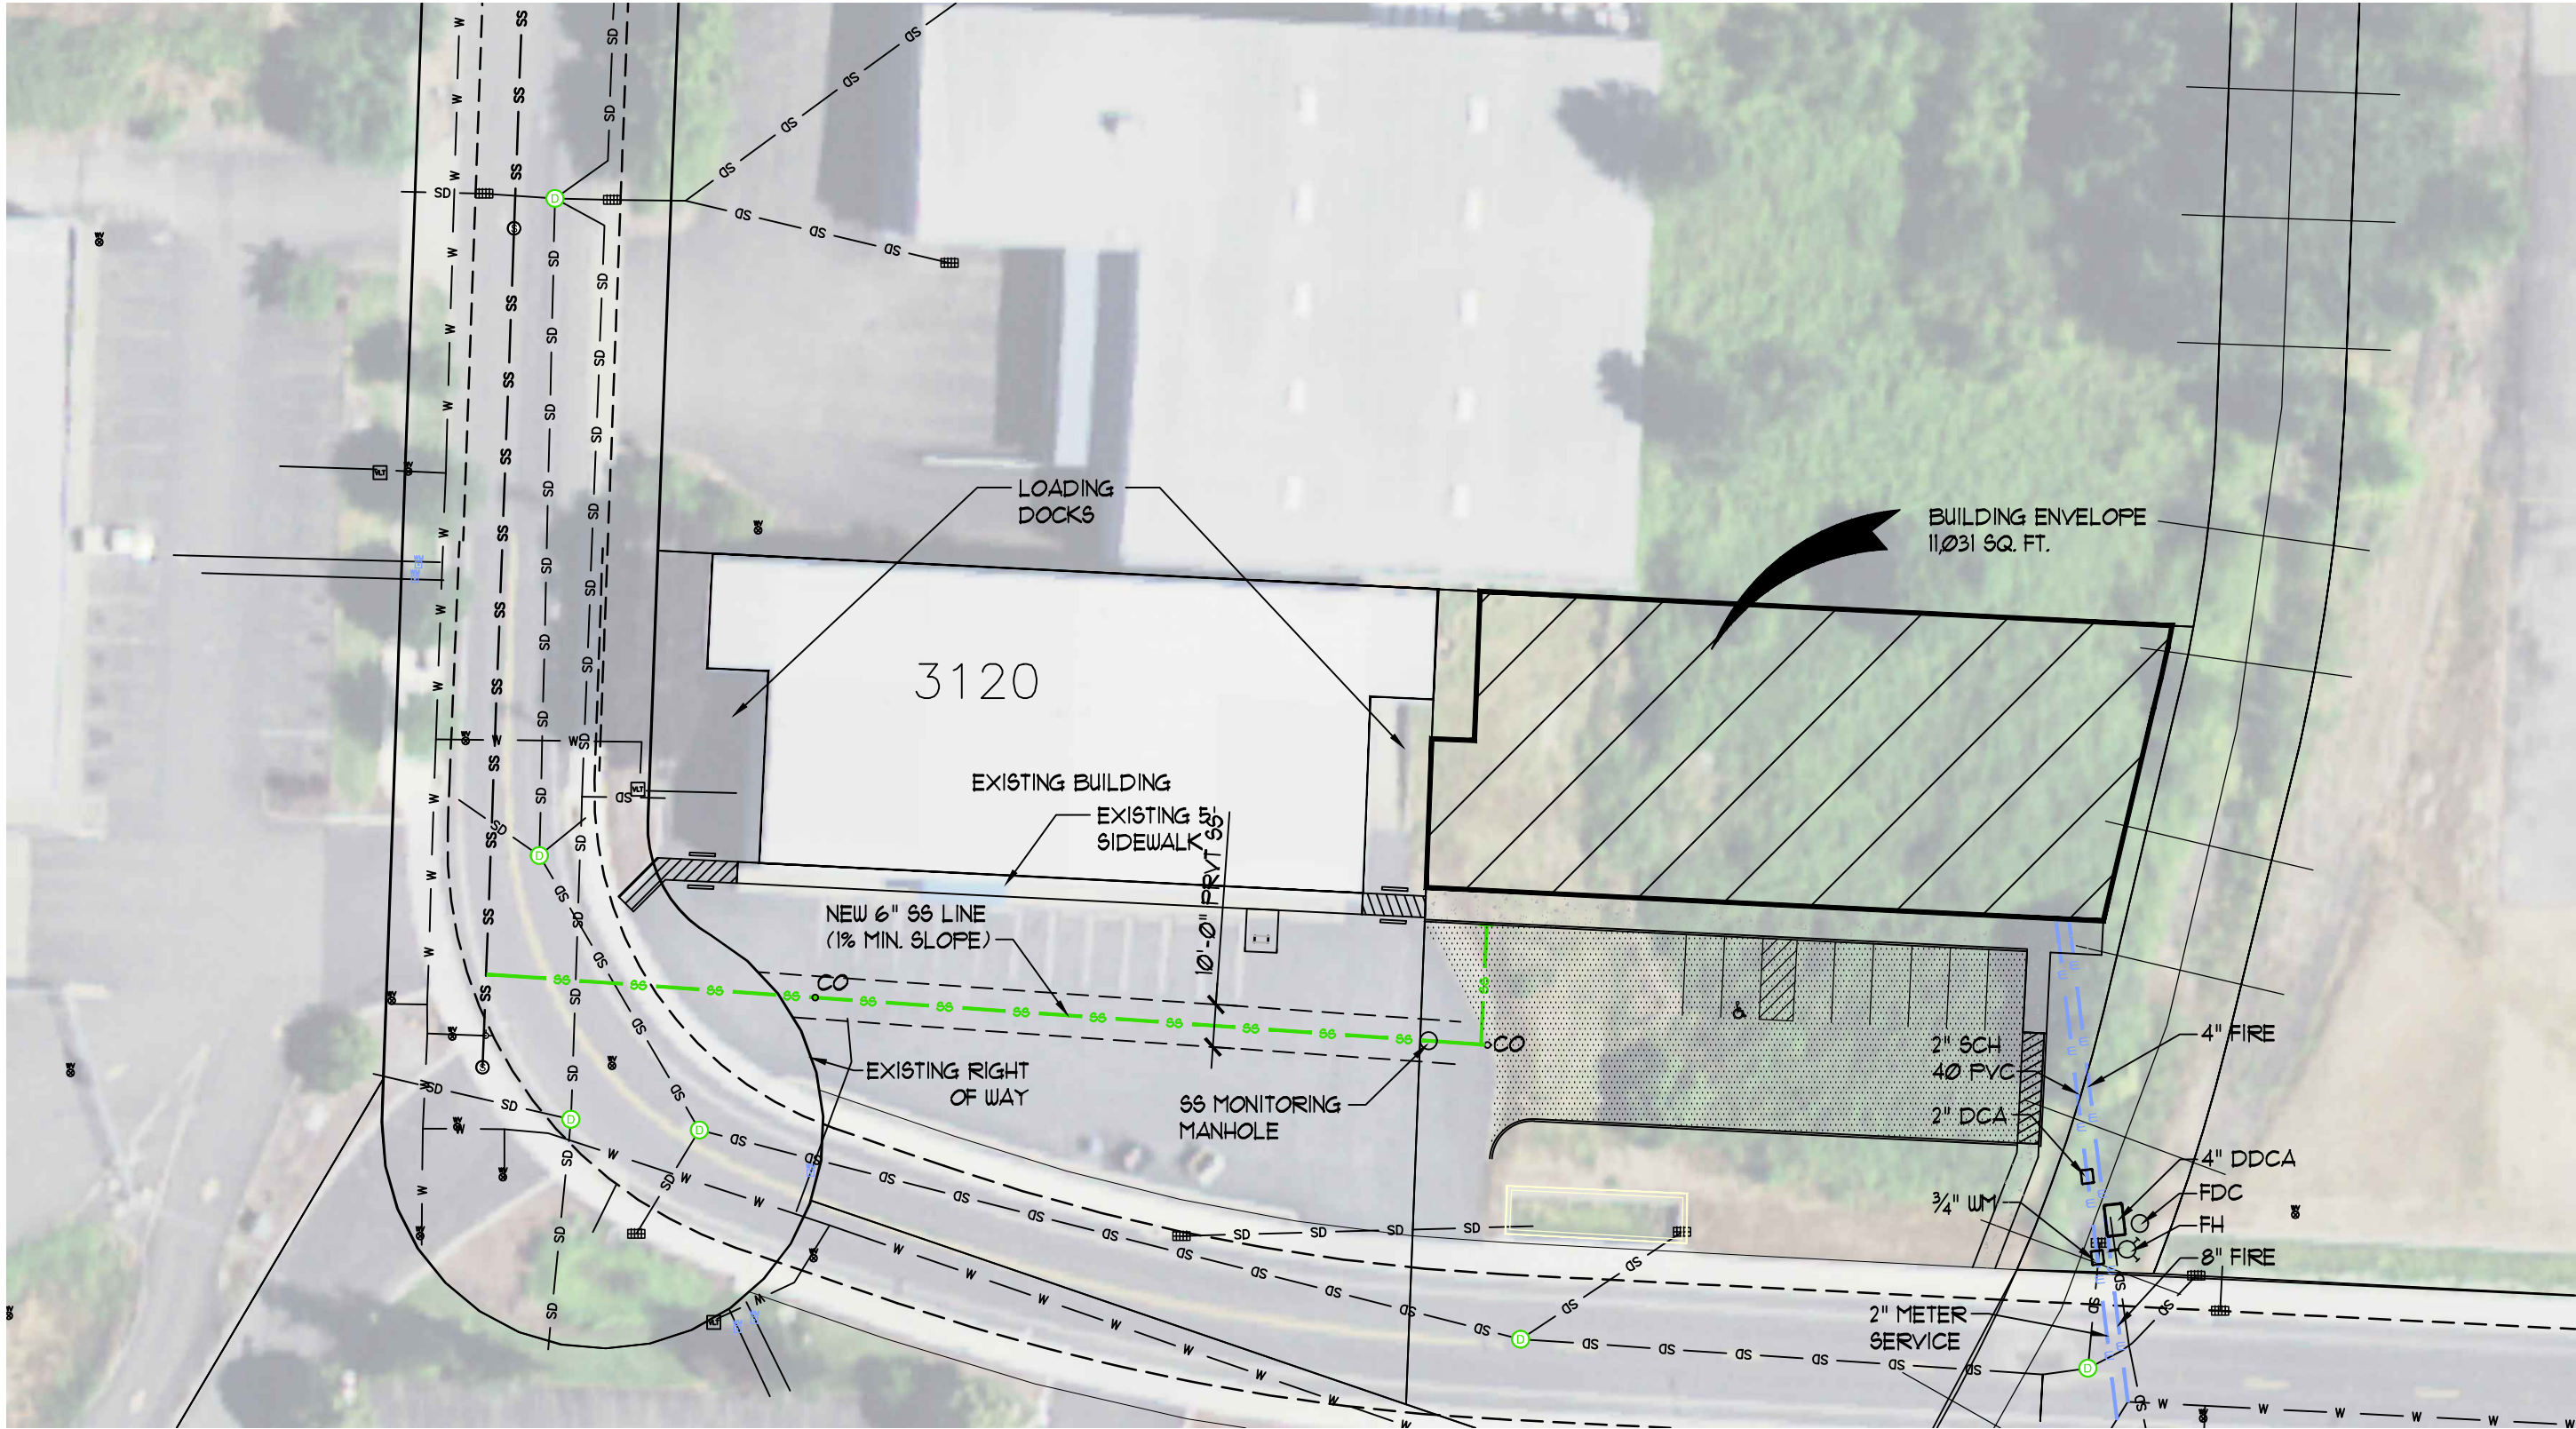

UTILITY PLAN

SCALE : 1" = 40'-0"




LEGEND

— SS — SS — SS — SS —
— SD — SD — SD — SD —
— W — W — W — W —

EXISTING SEWER LINE
EXISTING STORM DRAIN
EXISTING WATER LINE

— SS — SS — SS — SS —
— SD — SD — SD — SD —
— W — W — W — W —

NEW SEWER LINE
NEW STORM DRAIN
NEW WATER LINE

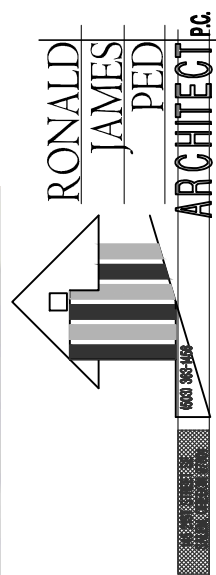

Site Plan Review Class 2
Thermal Supply
3120 22nd St SE, Salem, OR 97302

DATE: 04.22.2022
DRAWN: glm
JOB NO.: 2181

SPR 4