


FILE PATH:

THESE DRAWINGS ARE THE ORIGINAL UNPUBLISHED WORK OF THE ARCHITECT AND MAY NOT BE DUPLICATED OR USED WITHOUT THE WRITTEN CONSENT OF THE ARCHITECT.

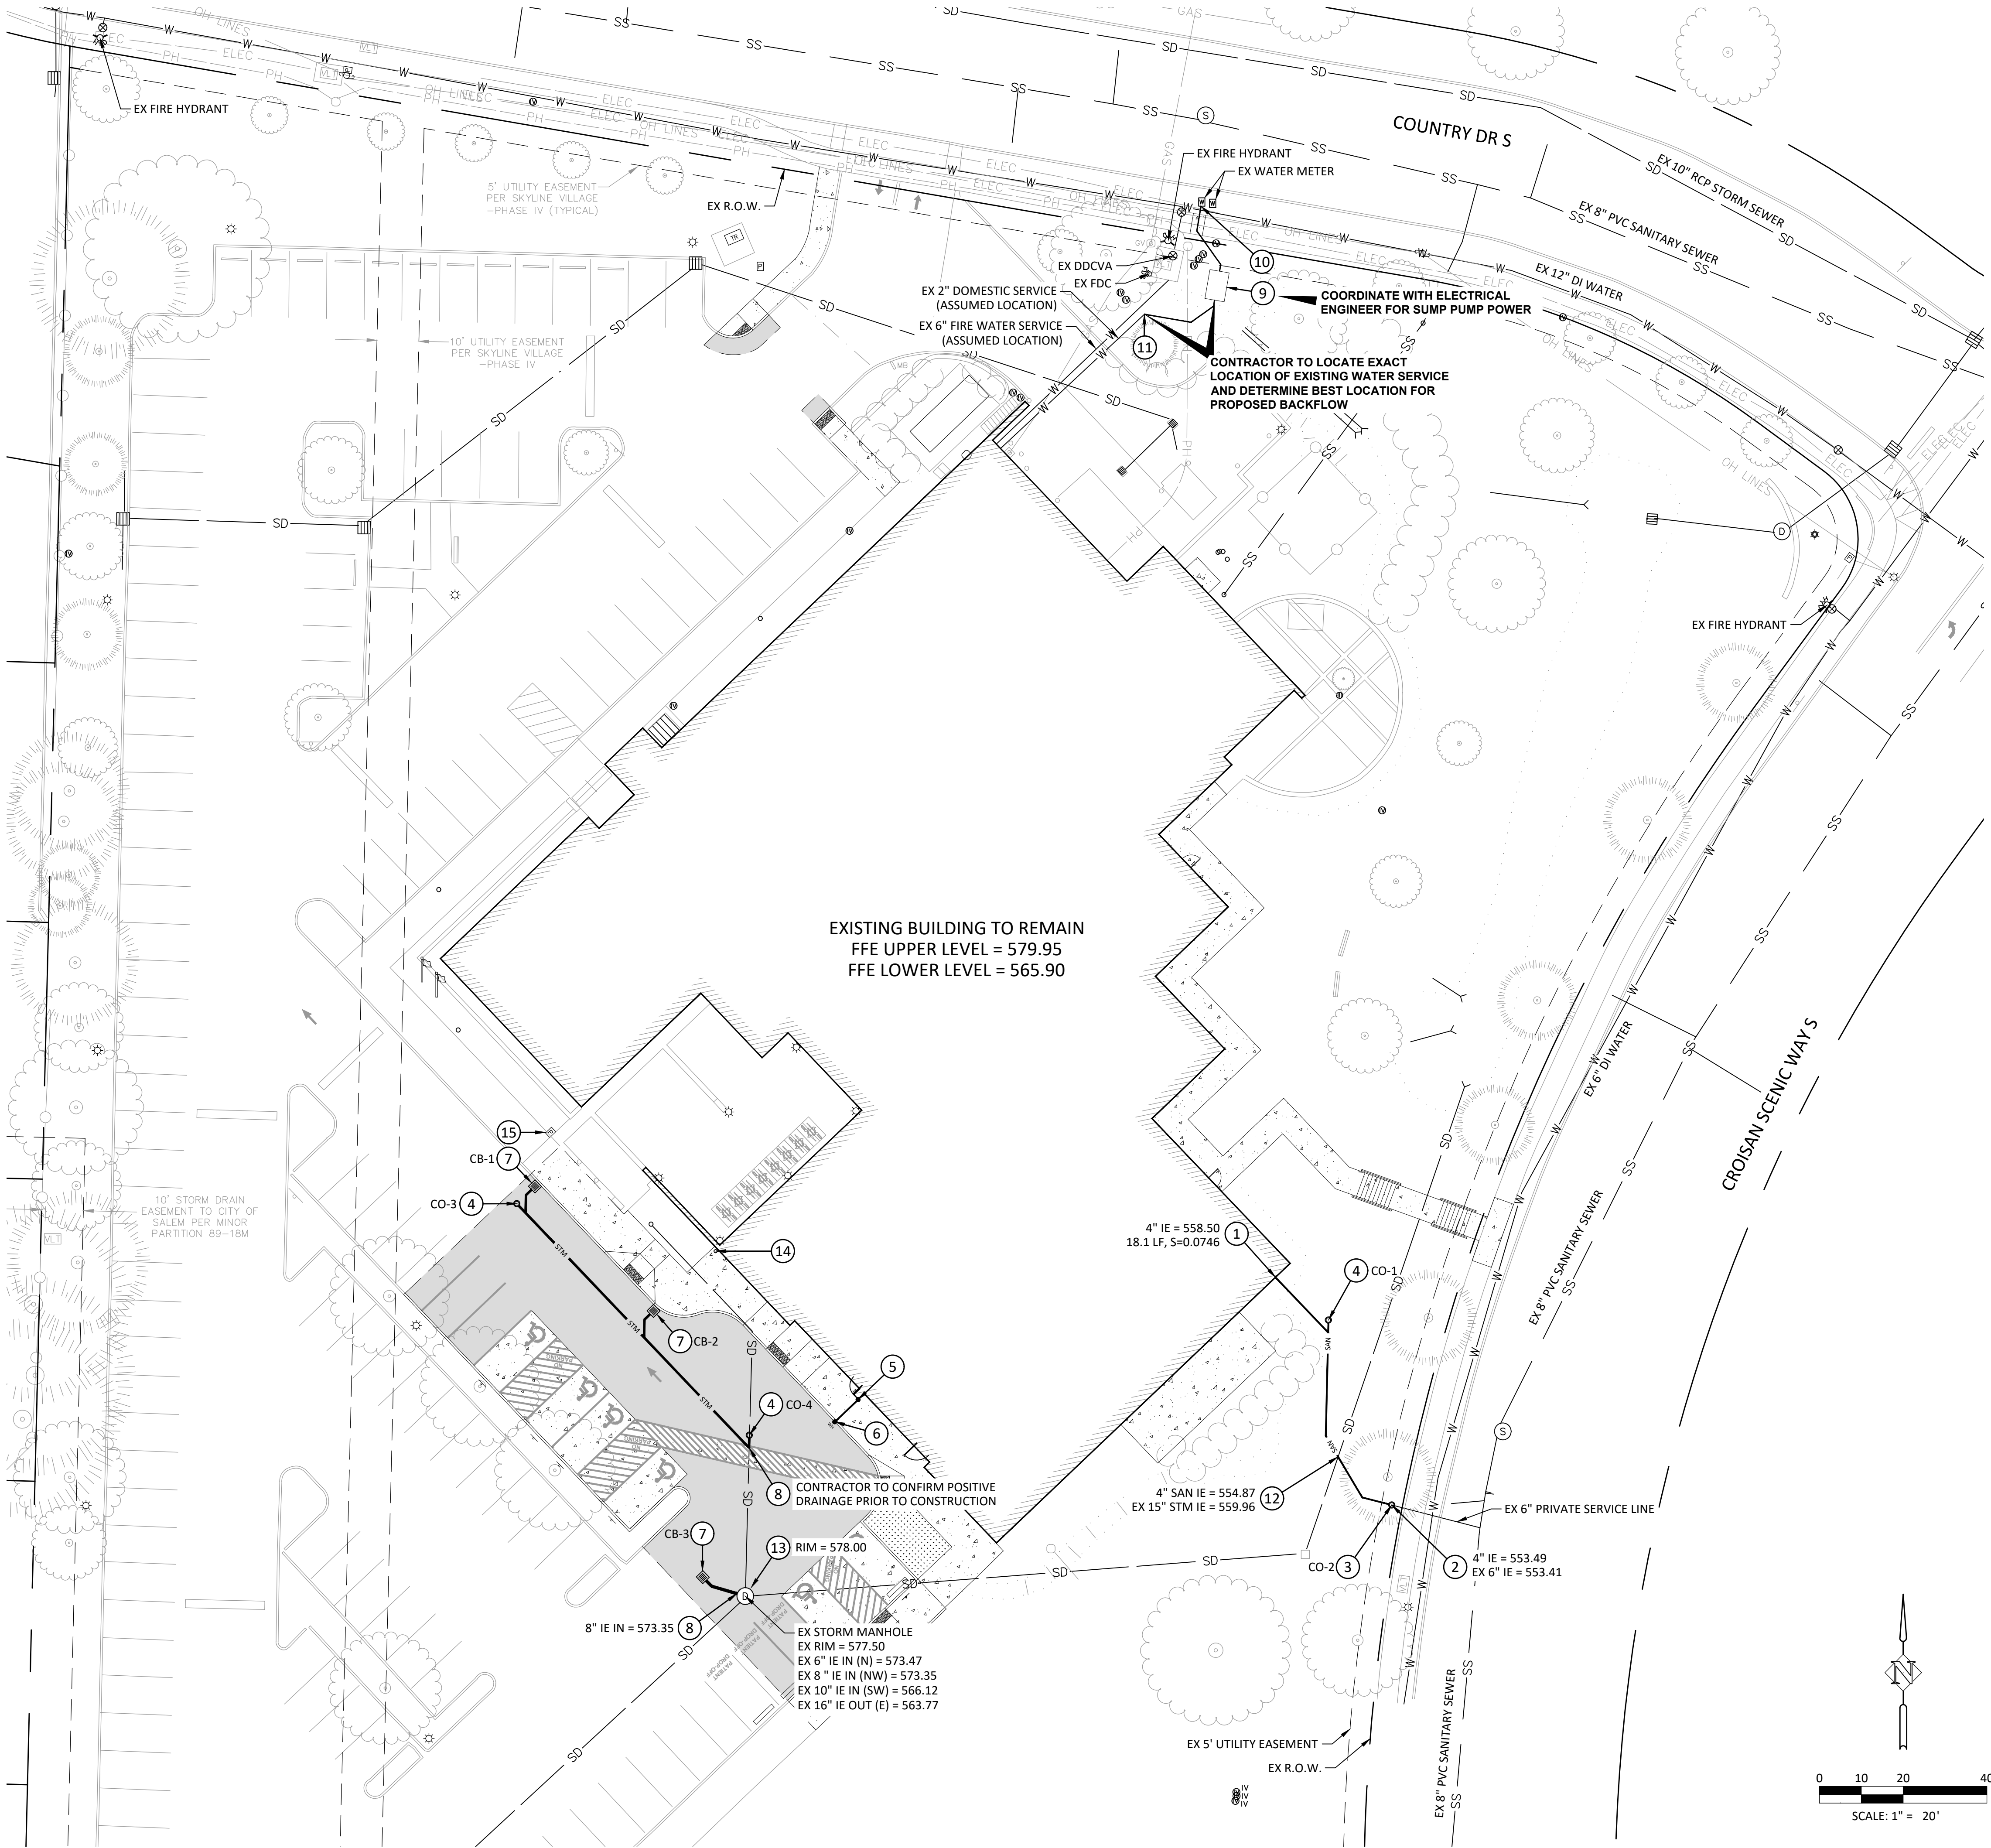

CONSTRUCTION NOTES:

- 1 BUILDING SANITARY SEWER CONNECTION LOCATION. SEE PLAN FOR DATA. SEE PLUMBING PLANS FOR CONNECTION DETAILS.
- 2 CONNECT TO EXISTING SANITARY SEWER LATERAL STUB. SEE PLAN FOR DATA. CONTRACTOR TO VERIFY ASSUMED CONNECTION ELEVATION AND LOCATION PRIOR TO CONSTRUCTION. NOTIFY ENGINEER OF ANY DISCREPANCIES.
- 3 INSTALL TWO WAY CLEANOUT PER CITY OF SALEM STANDARD PLAN NO. 106 ON SHEET C402. SEE THIS SHEET FOR DATA.
- 4 INSTALL STANDARD CLEANOUT PER DETAIL ON SHEET C401. SEE THIS SHEET FOR DATA.
- 5 BUILDING ROOF DRAIN CONNECTION LOCATION. SEE ARCHITECTURAL PLANS FOR DETAILS.
- 6 INSTALL WEEP HOLE PER CITY OF SALEM STANDARD PLAN NO. 257 ON SHEET C402.
- 7 INSTALL CATCH BASIN PER DETAIL ON SHEET C401. SEE THIS SHEET FOR DATA.
- 8 CONNECT TO EXISTING STORM MANHOLE PER DETAIL ON SHEET C401. SEE PLAN FOR DATA.
- 9 INSTALL 2 1/2" BACKFLOW DEVICE AND VAULT PER DETAIL ON SHEET C401.
- 10 CONNECT TO EXISTING 2" METER.
- 11 CONNECT TO EXISTING 2 1/2" DOMESTIC SERVICE.
- 12 PROTECT EXISTING STORM. SEE PLAN FOR ASSUMED CROSSING DATA. CONTRACTOR TO POTHOLE EXISTING UTILITY PRIOR TO CONSTRUCTION. NOTIFY ENGINEER OF ANY CROSSING CONFLICTS IMMEDIATELY.
- 13 PROTECT STORM MANHOLE. ADJUST RIM TO FINISH GRADE PER DETAIL ON SHEET C401. SEE PLAN FOR ELEVATION.
- 14 PROTECT EXISTING ROOF DOWNSPOUT AND ASSOCIATED STORM PIPING.
- 15 PROTECT EXISTING POWER.

SANITARY SEWER DATA:

CO-1
CLEANOUT
RIM = 564.26
4" IE OUT (S) = 557.37
52.1 LF, S=0.0746

CO-2
CLEANOUT
RIM = 560.66
4" IE IN (W) = 553.49
EX 6" IE OUT (E) = 553.41

STORM SEWER DATA:

CB-1
CATCH BASIN
RIM = 578.91
6" IE OUT (SW) = 575.41
7.2 LF, S=0.0050 MIN.

CB-2
CATCH BASIN
RIM = 578.70
6" IE OUT (SW) = 575.20
7.2 LF, S=0.0050 MIN.

CB-3
CATCH BASIN
RIM = 577.15
8" IE OUT (SE) = 573.48
11.4 LF, S=0.0114

CO-3
CLEANOUT
RIM = 579.20
6" IE OUT (SE) = 575.39
80.5 LF, S=0.0050 MIN.

CO-4
CLEANOUT
RIM = 578.93
CONTRACTOR TO CONFIRM
POSITIVE DRAINAGE



WILLAMETTE
SURGERY
CENTER - CORE
& SHELL

Job Number: 21190

2150 COUNTRY DR. S
SALEM, OR 97302



100% DESIGN DEV. 07.25.22

Issue Date

Drawing:

UTILITY PLAN

Sheet No:

C300