
 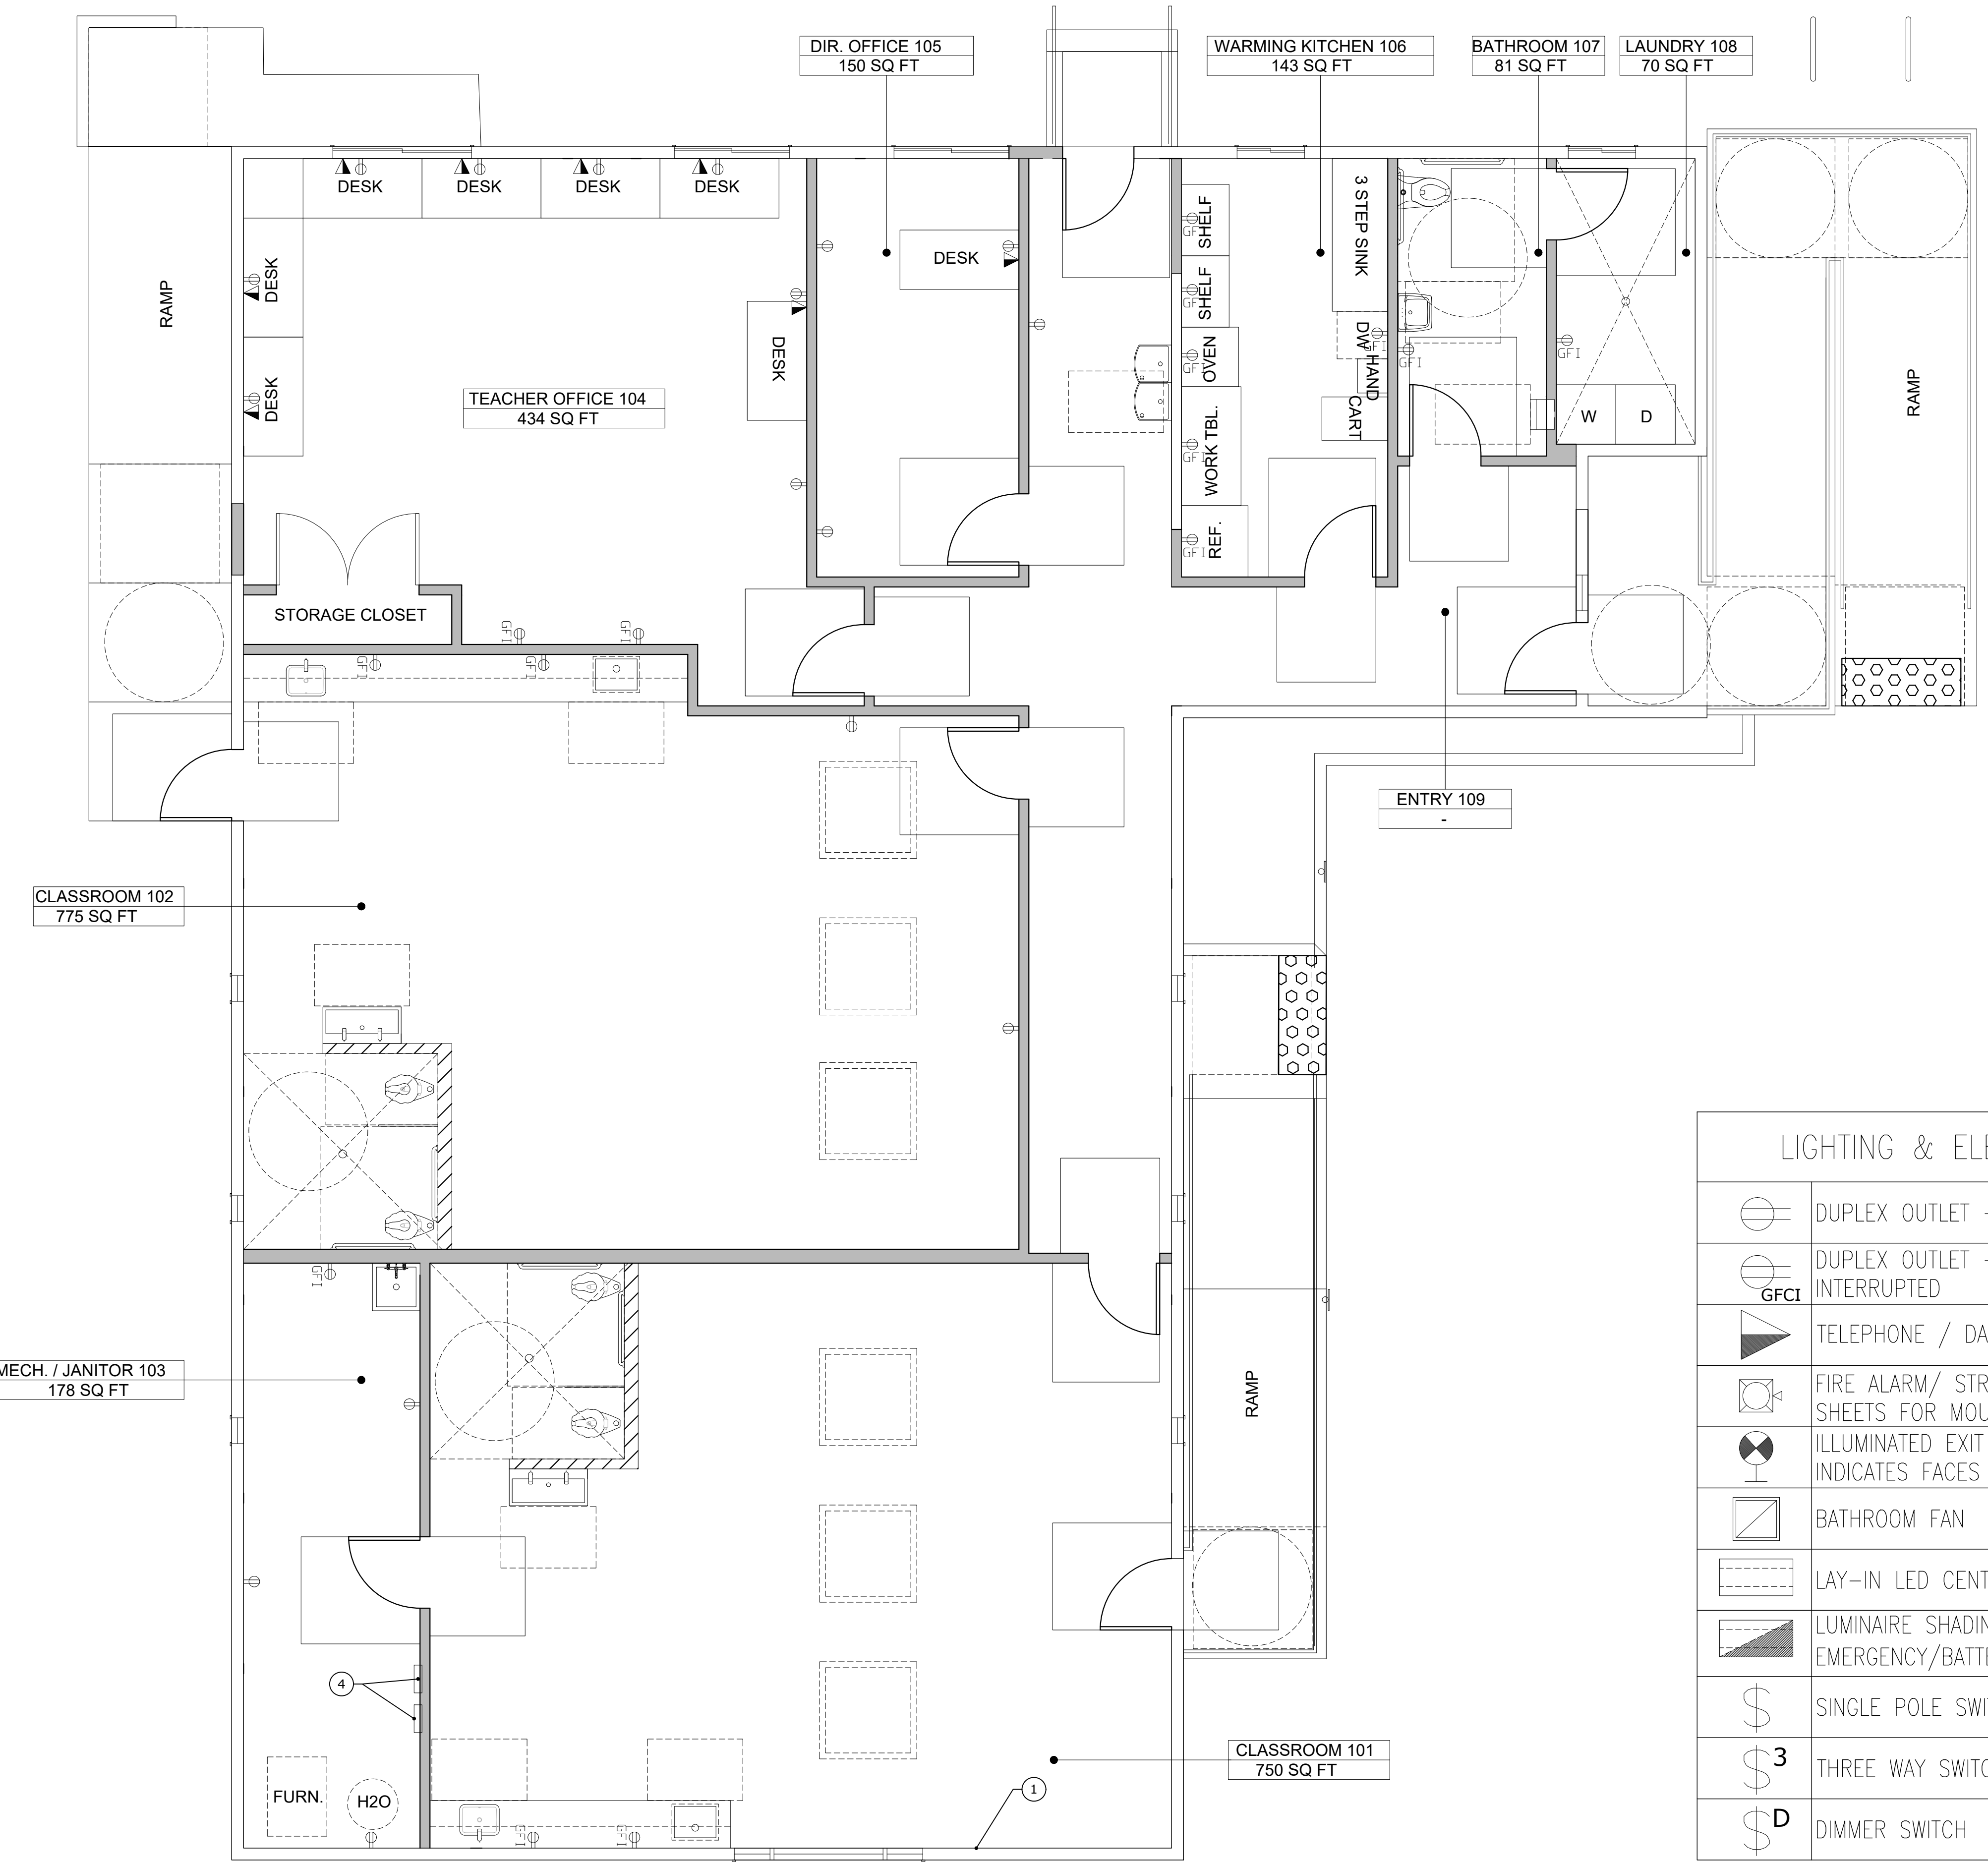




LIGHTING & ELECTRICAL LEGEND	
	DUPLEX OUTLET – WALL MOUNTED
	DUPLEX OUTLET – GROUND FAULT CURRENT INTERRUPTED
	TELEPHONE / DATA OUTLET
	FIRE ALARM/ STROBE – SEE ACCESSIBILITY SHEETS FOR MOUNTING HEIGHT
	ILLUMINATED EXIT SIGN – SHADED QUADRANT INDICATES FACES
	BATHROOM FAN
	LAY-IN LED CENTER BASKET LUMINAIRE
	LUMINAIRE SHADING INDICATES EMERGENCY/BATTERY BACKUP
	SINGLE POLE SWITCH
	THREE WAY SWITCH
	DIMMER SWITCH

- NOTES
- (E) OUTLETS ON PERIMETER WALLS TO REMAIN. PROVIDE CHILD SAFE OUTLET COVERS ON CLASSROOM AND HALLWAY OUTLETS.
 - PROVIDE (N) MANUAL FIRE ALARM PER OSSC 907.2.3 - CONNECT TO SMOKE DETECTORS.
 - PROVIDE (N) SECURITY SYSTEM INCLUDING CAMERAS AT ENTRANCES AND CLASSROOMS.
 - RELOCATE (E) ELECTRICAL PANELS IN MECH/JANITOR 103.

Wallace Rd Head Start
1205 Wallace Rd NW
Salem, OR 97304

CONSULTANTS

CD	03/20/2023	REV. DRAFT CDS
Mark	Date	Description



DATE: 03/23/2023

ISSUE TITLE: PERMIT SET

SCALE: As Noted