

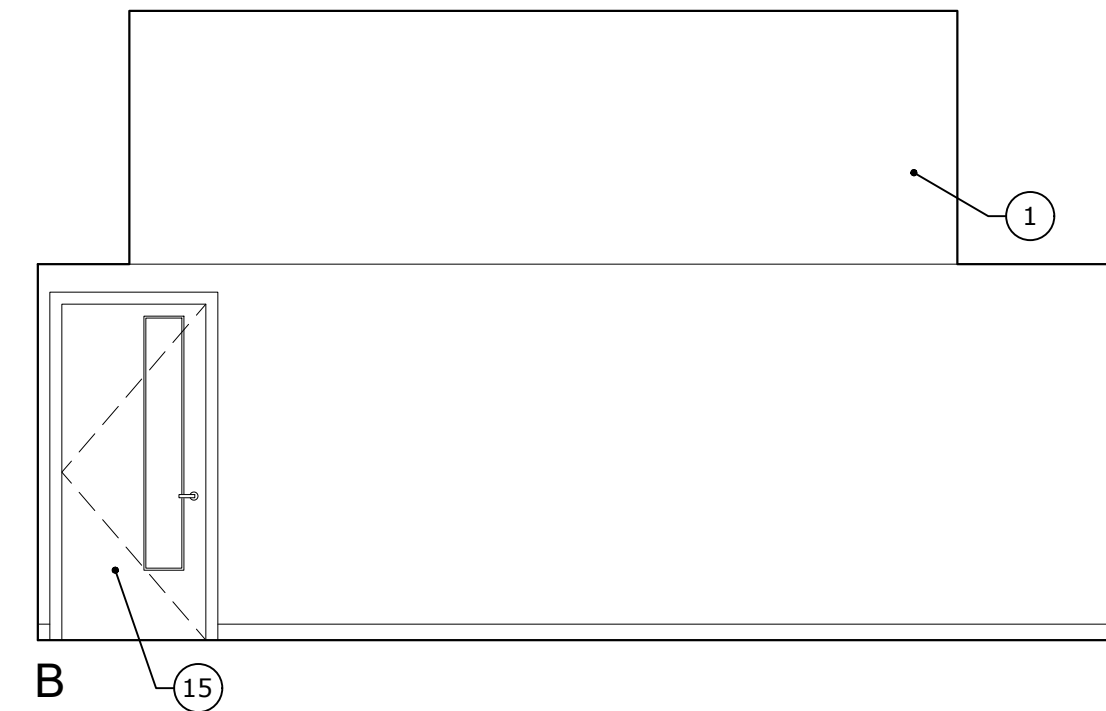
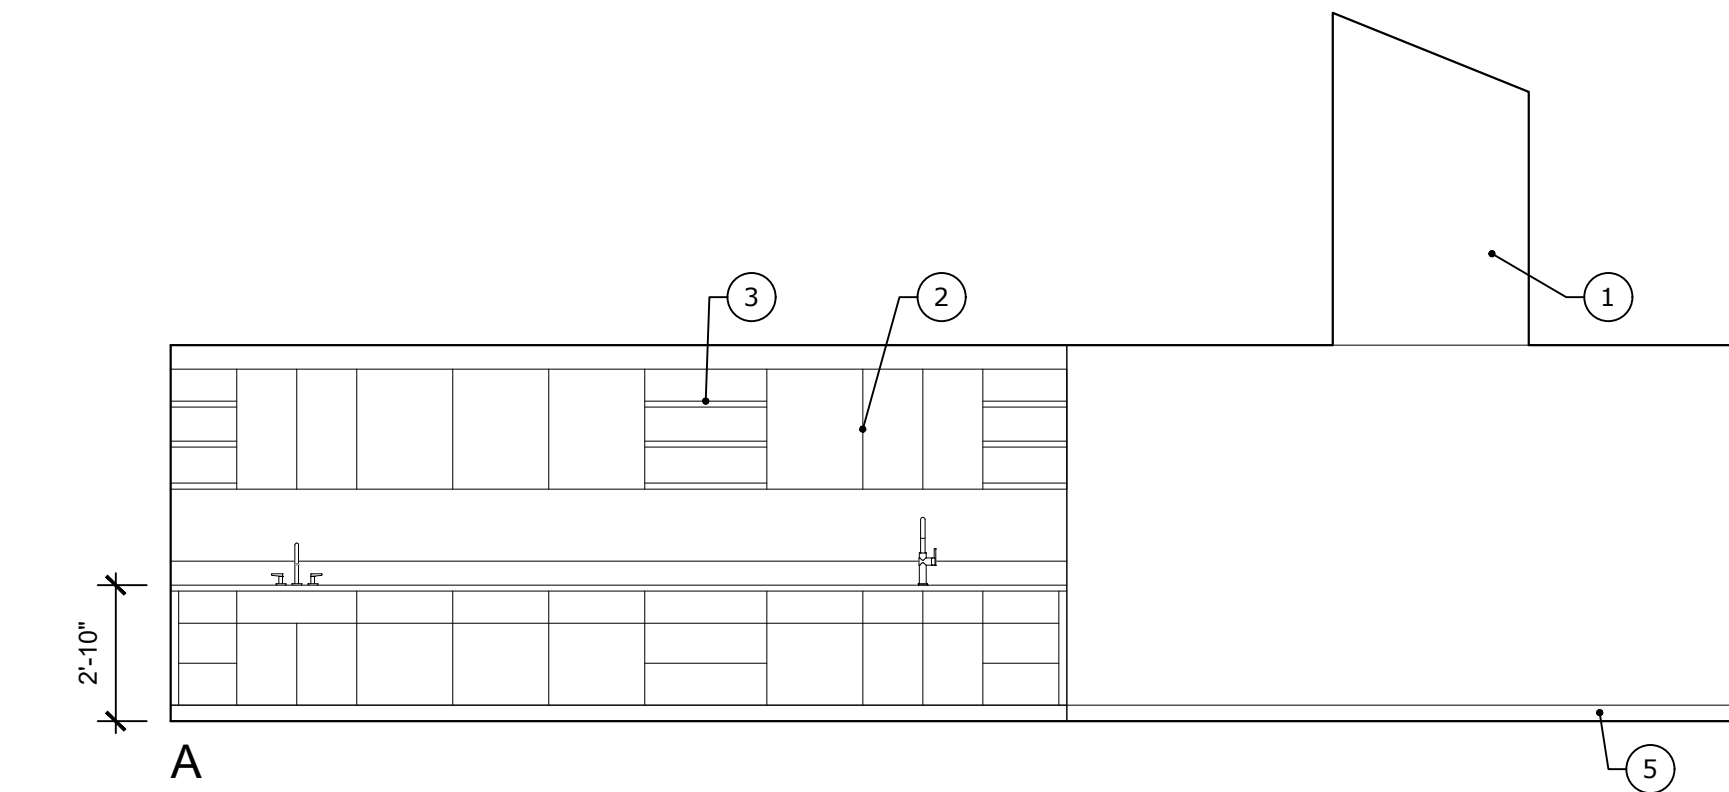
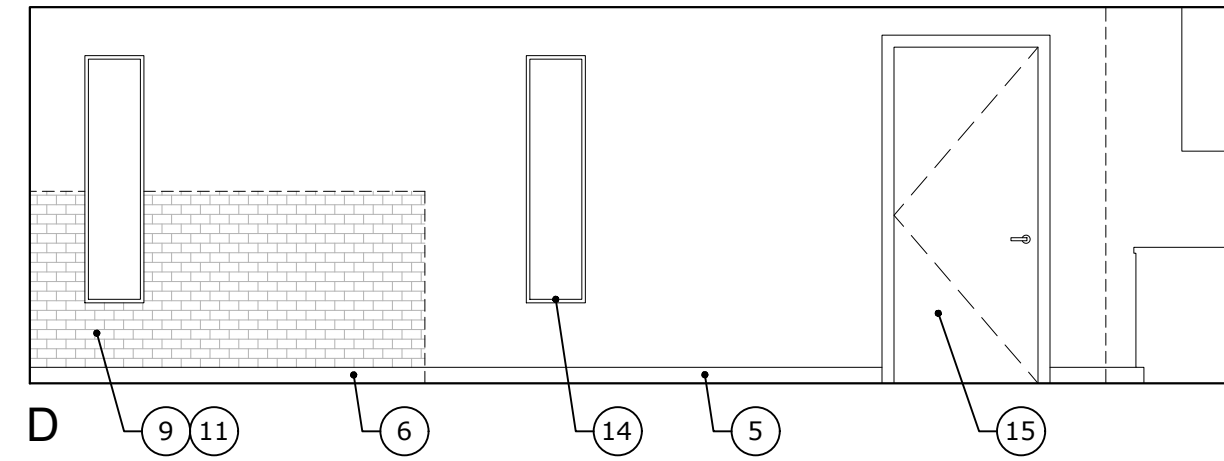
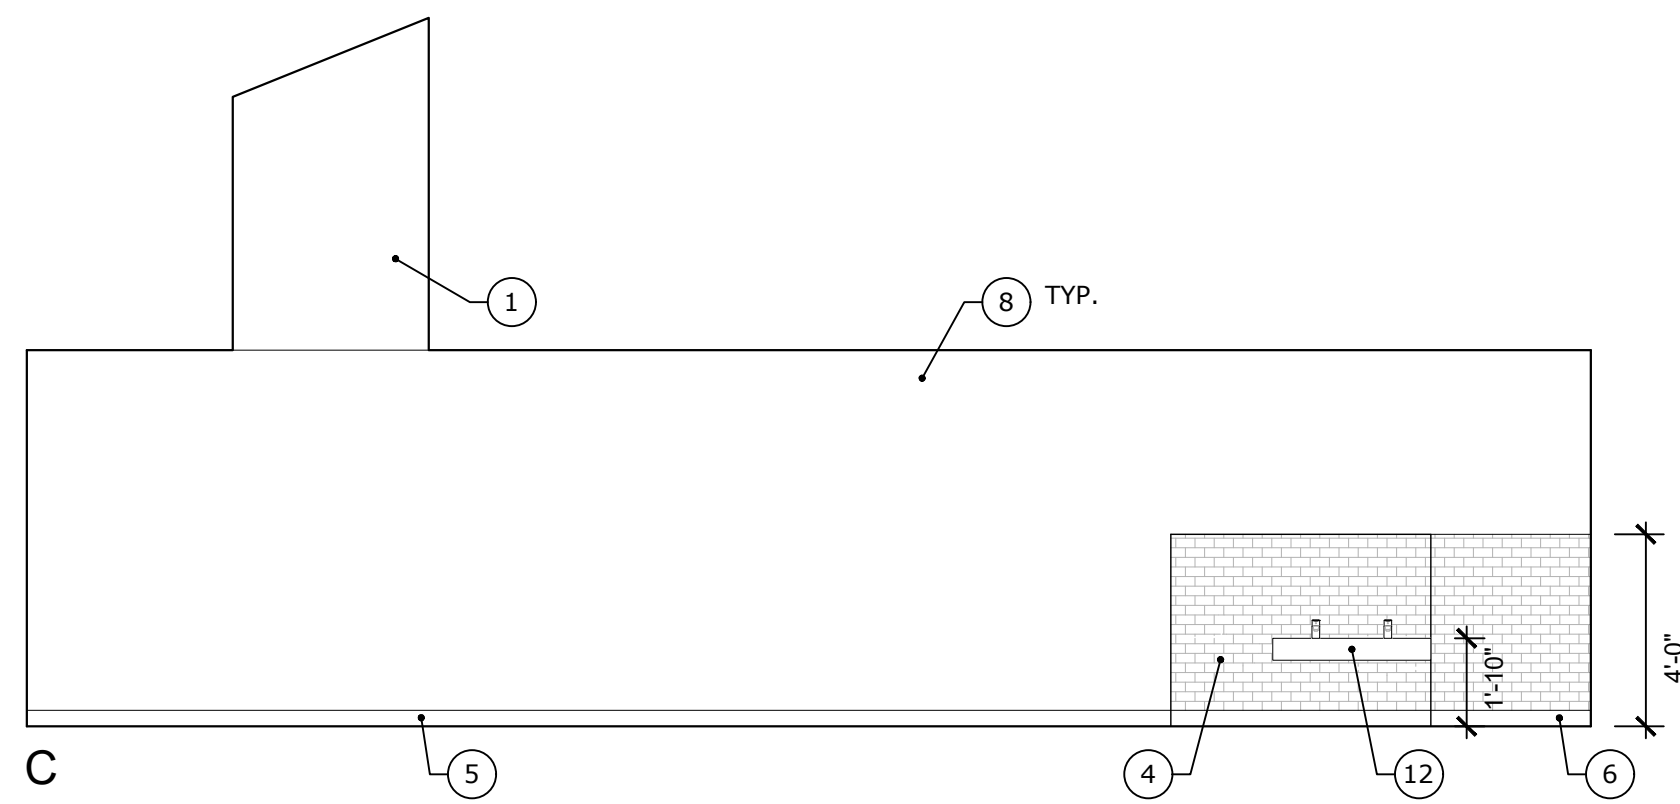
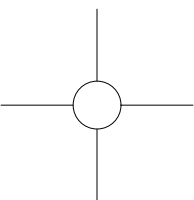
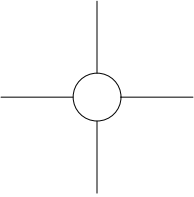
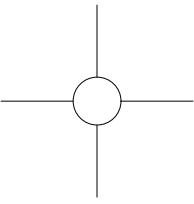
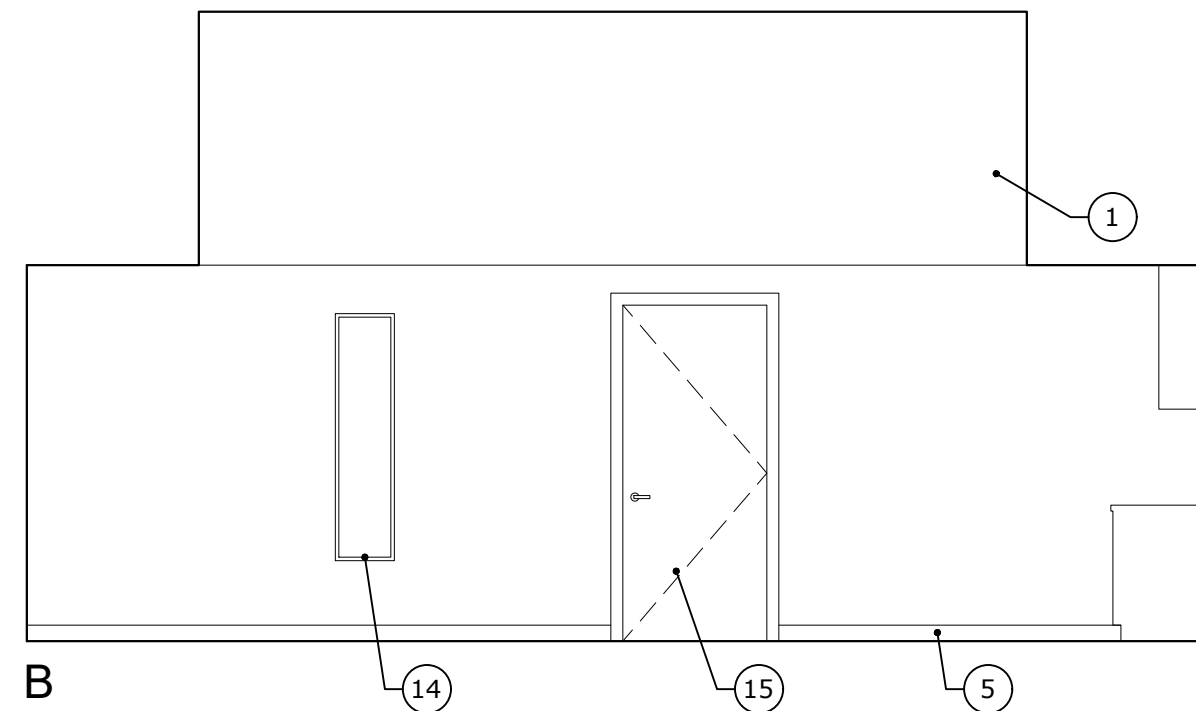
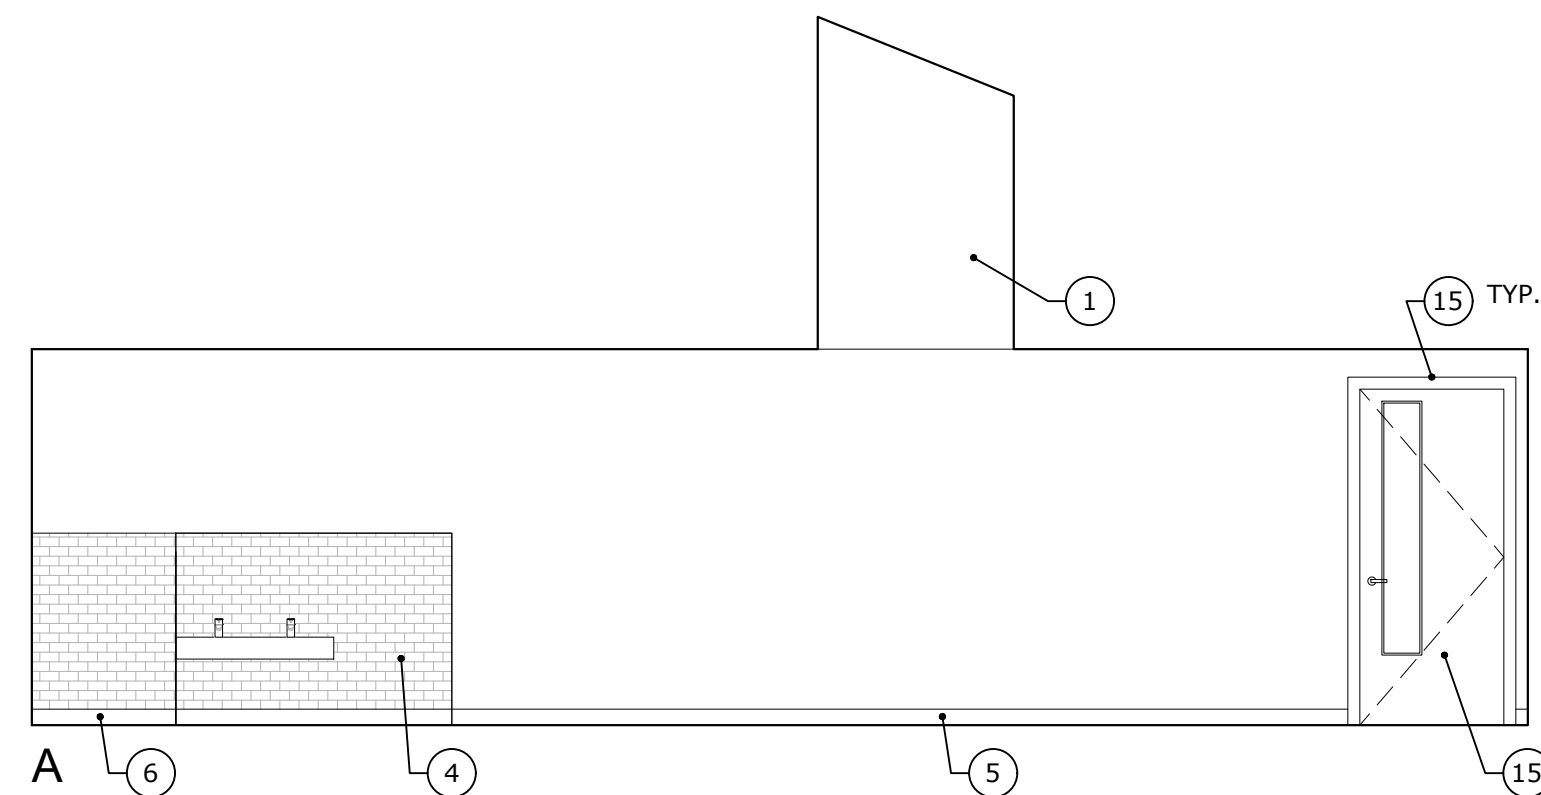


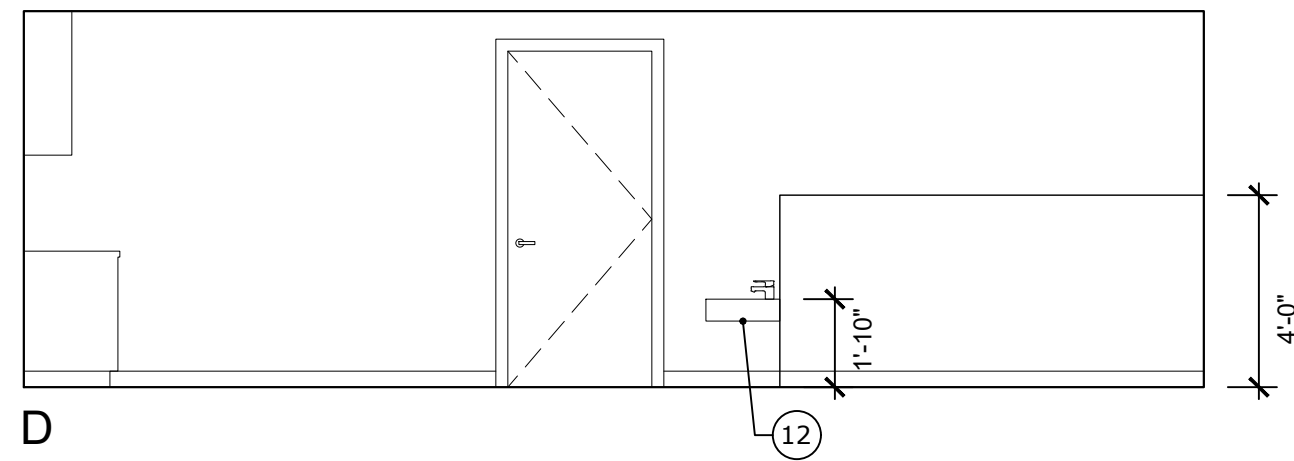

2 CLASSROOM 102 - INTERIOR ELEVATIONS
SCALE: 1/4" = 1'-0"

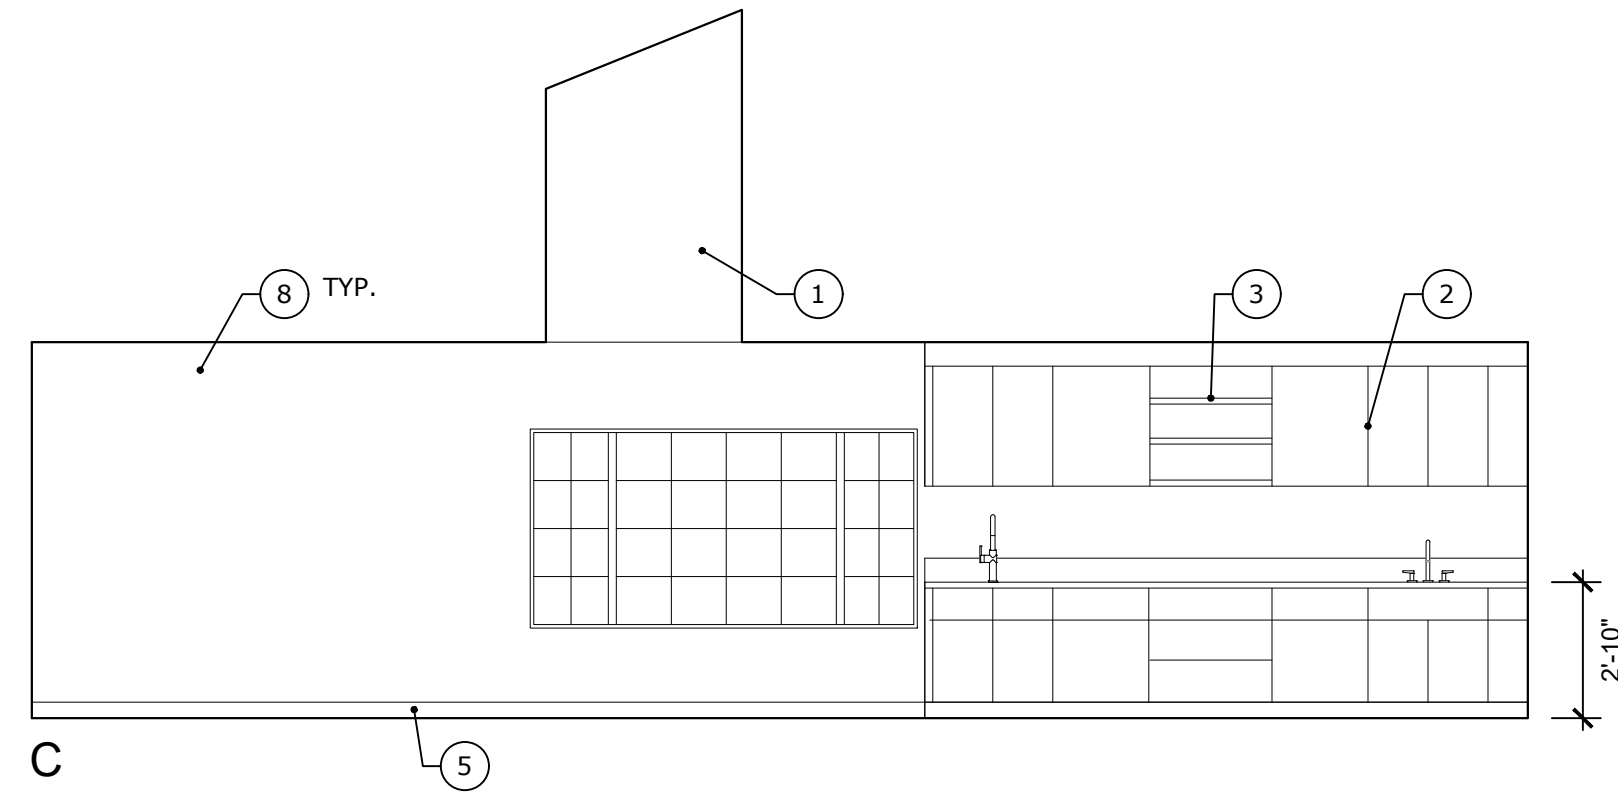

1 CLASSROOM 101 - INTERIOR ELEVATIONS
SCALE: 1/4" = 1'-0"

NOTES

1. (N) SKYLIGHT WELL - LEVEL 4 GYP. BD. FINISH.
2. (N) P-LAM CASEWORK & SOLID SURFACE COUNTERTOP & 6" SPLASH - SEE FINISH SHEETS.
3. (N) P-PLAM SHELVES - FINISH TO MATCH CABINET DOOR FACES.
4. (N) WALL TILE TO DIM SHOWN - SEE DETAILS.
5. (N) RESILIENT BASE.
6. (N) INTEGRAL EPOXY BASE.
7. NOT USED
8. PAINTED GYP BD WALL - TEXTURE TO MATCH (E).
9. SEE ACCESSIBILITY SHEETS FOR PLUMBING FIXTURE AND BATHROOM ACCESSORY MOUNTING HEIGHTS - TYP.
10. SOAP DISPENSER - SEE ACCESSIBILITY SHEETS FOR MOUNTING HEIGHTS.
11. CHILD HEIGHT TOILET PER OSSC 1109.2 EXCEPTION 7 - SEE PLUMBING SCHEDULE.
12. (N) CHILD HEIGHT LAVATORY - SEE PLUMBING SCHEDULE.
13. NOT USED
14. (E) AMBER GLASS WINDOW.
15. (N) DOOR - SEE DOOR SCHEDULE.

lla

Linea Lab Architecture

1801 NE 61ST AVE
PORTLAND, OR 97213
TEL. 971.930.0110
linealabarchitecture.com

Wallace Rd Head Start
1205 Wallace Rd NW
Salem, OR 97304

CONSULTANTS

CD	03/20/2023	REV. DRAFT CDS
Mark	Date	Description



DATE: 03/23/2023

ISSUE TITLE:

PERMIT SET

SCALE: As Noted

Interior Elevations

A4.01