

NOTES

1. (N) KITCHEN EQUIPMENT - SEE SPECS.
2. (N) RESIDENTIAL RANGE & HOOD - VENT TO EXTERIOR.
3. (N) RESIDENTIAL REFRIGERATOR.
4. (N) FULL-HEIGHT FRP.
5. (N) RESILIENT BASE.
6. (N) INTEGRAL EPOXY BASE.
7. PAINTED GYP BD WALL - TEXTURE TO MATCH (E).
8. (N) WALL TILE TO DIMENSION SHOWN.
9. REINSTALL (E) WASHER & DRYER, VENT DRYER TO EXTERIOR - SEE DEMO SHEETS.
10. SEE ACCESSIBILITY SHEETS FOR PLUMBING FIXTURE AND BATHROOM ACCESSORY MOUNTING HEIGHTS - TYP.
11. SOAP DISPENSER - SEE ACCESSIBILITY SHEETS FOR MOUNTING HEIGHTS.
12. SEMI-RECESSED COMBINATION PAPER TOWEL/TRASH - SEE SPECS
13. SHIM @ GAPS BETWEEN WALL & BATHROOM ACCESSORIES - TYP.
14. PROVIDE COMBINATION TOILET PAPER DISPENSER - SEE ACCESSIBILITY SHEET FOR MOUNTING HEIGHTS.
15. (N) WALL-MOUNTED MIRROR, TEMPERED GLASS 18" X 36".


lla

Linea Lab Architecture


1801 NE 61ST AVE  
PORTLAND, OR 97213  
TEL. 971.930.0110  
linealabarchitecture.com

Wallace Rd Head Start  
1205 Wallace Rd NW  
Salem, OR 97304


CONSULTANTS

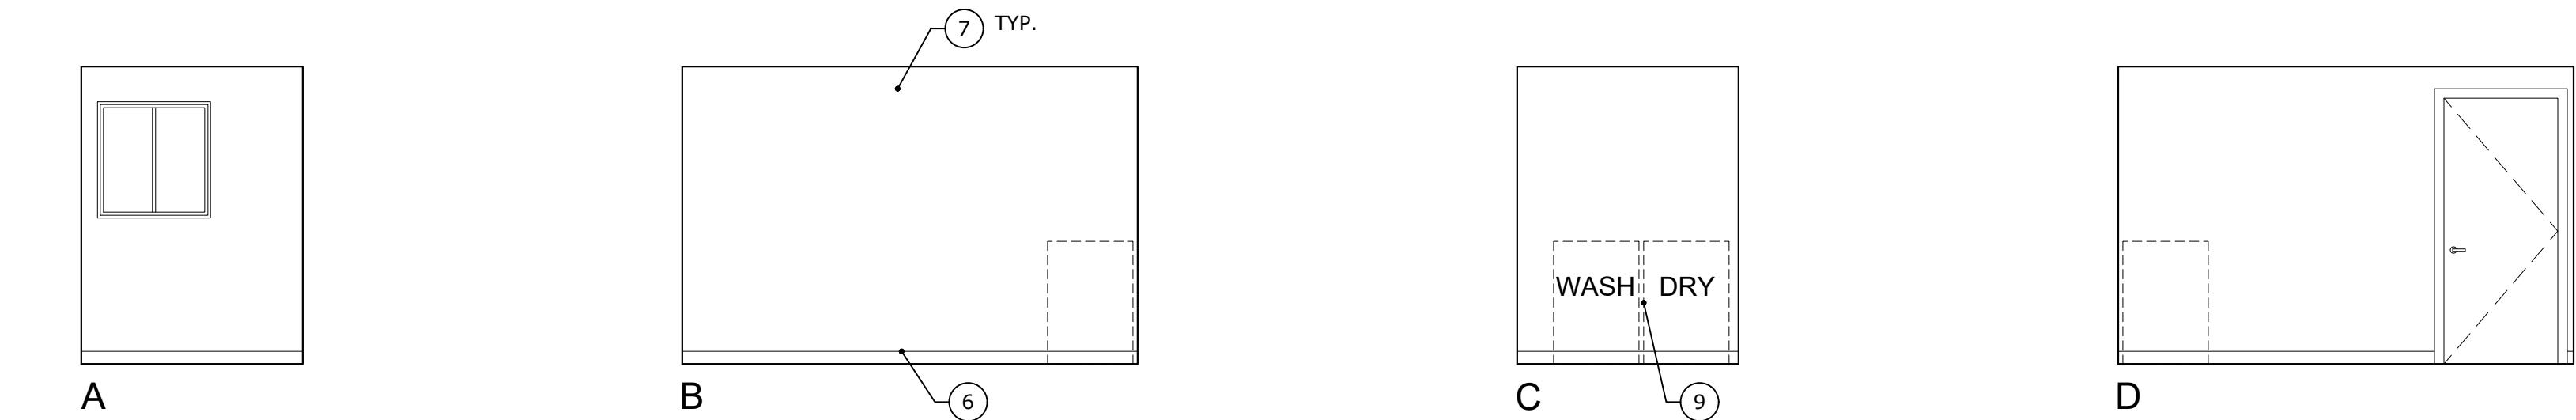

3 LAUNDRY 108 - INTERIOR ELEVATIONS  
SCALE: 1/4" = 1'-0"

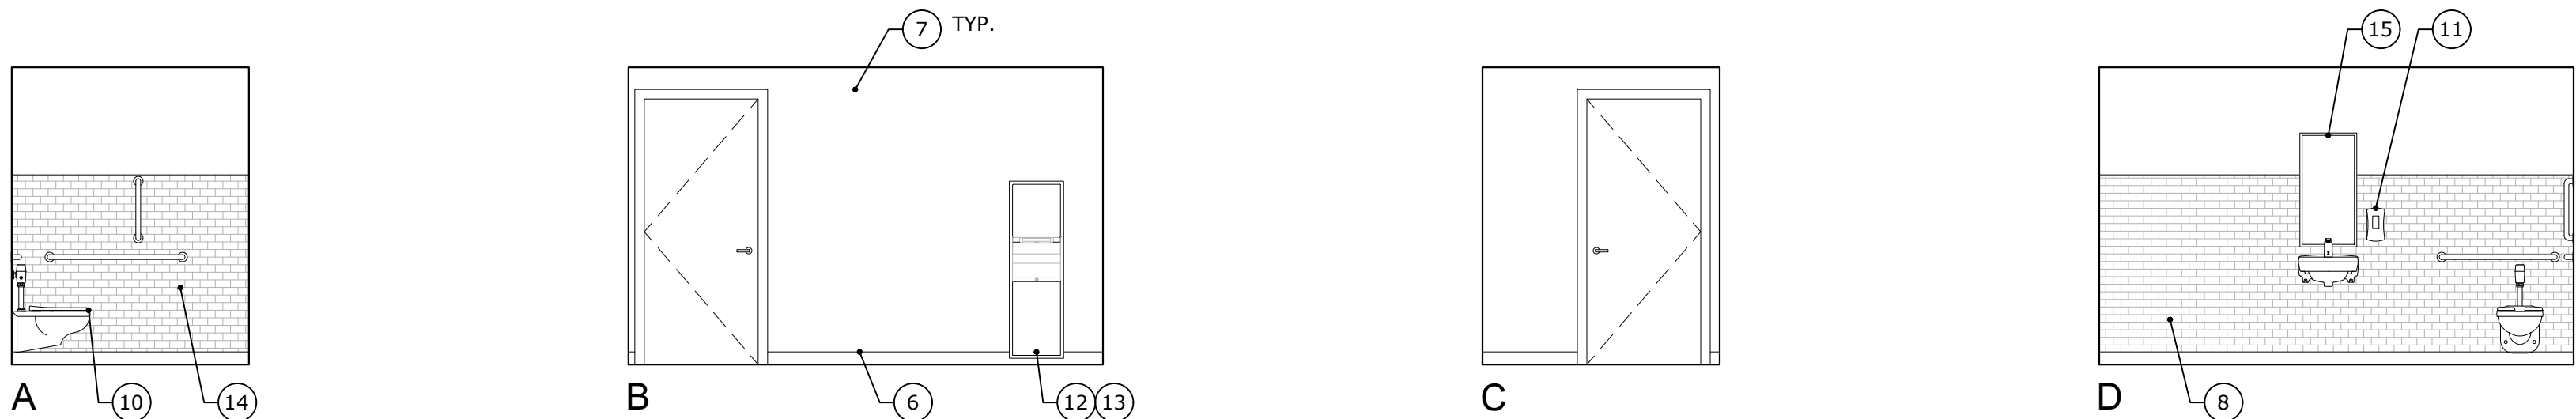

2 BATHROOM 107 - INTERIOR ELEVATIONS  
SCALE: 1/4" = 1'-0"

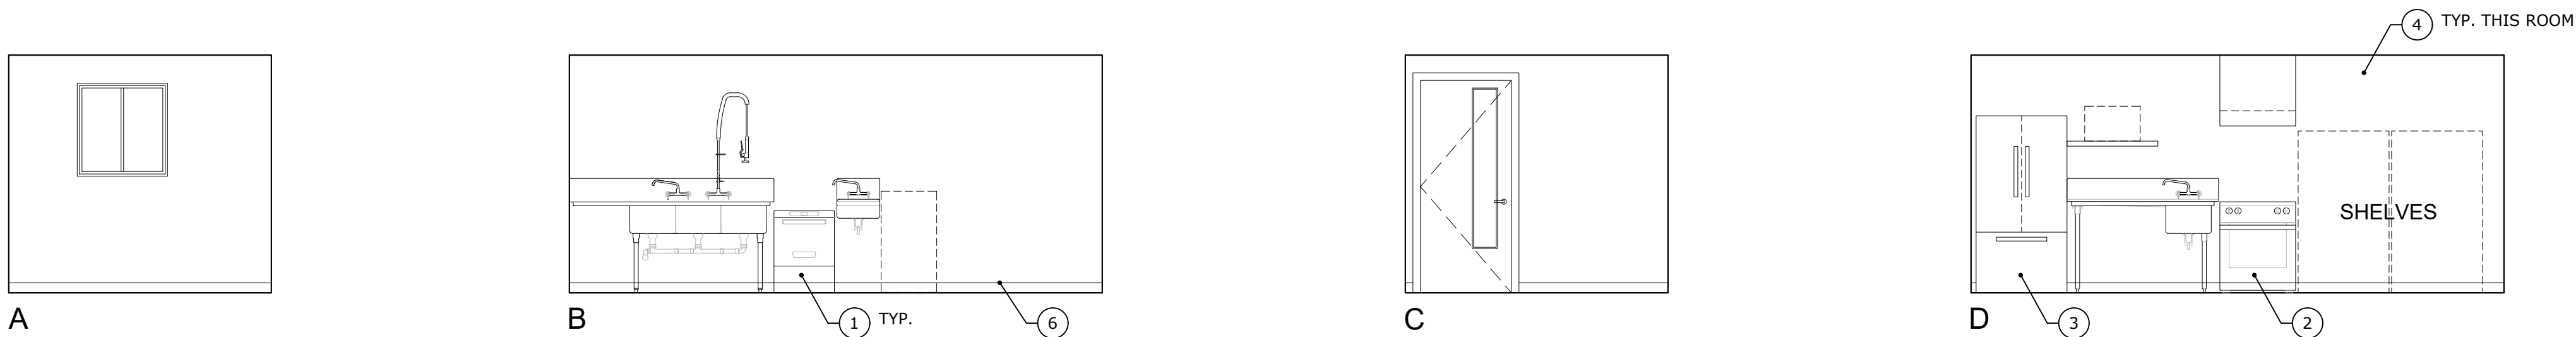

1 WARMING KITCHEN 106 - INTERIOR ELEVATIONS  
SCALE: 1/4" = 1'-0"

CD	03/20/2023	REV. DRAFT CDS
Mark	Date	Description



DATE: 03/23/2023

ISSUE TITLE:

PERMIT SET

SCALE: As Noted

Interior Elevations

A4.03