




LAST SAVED: Wed, 07 Feb 2024 - 02:26 pm LOCATION: P:\2159 Servando Garcia 17th and Oak apts\SPR-3\SPR-3_02.07.2024.dwg SPR-10-LIGHTING PLAN-DR
PRINTED: Wed, 07 Feb 2024 - 02:29 pm PRINTED BY: trevo

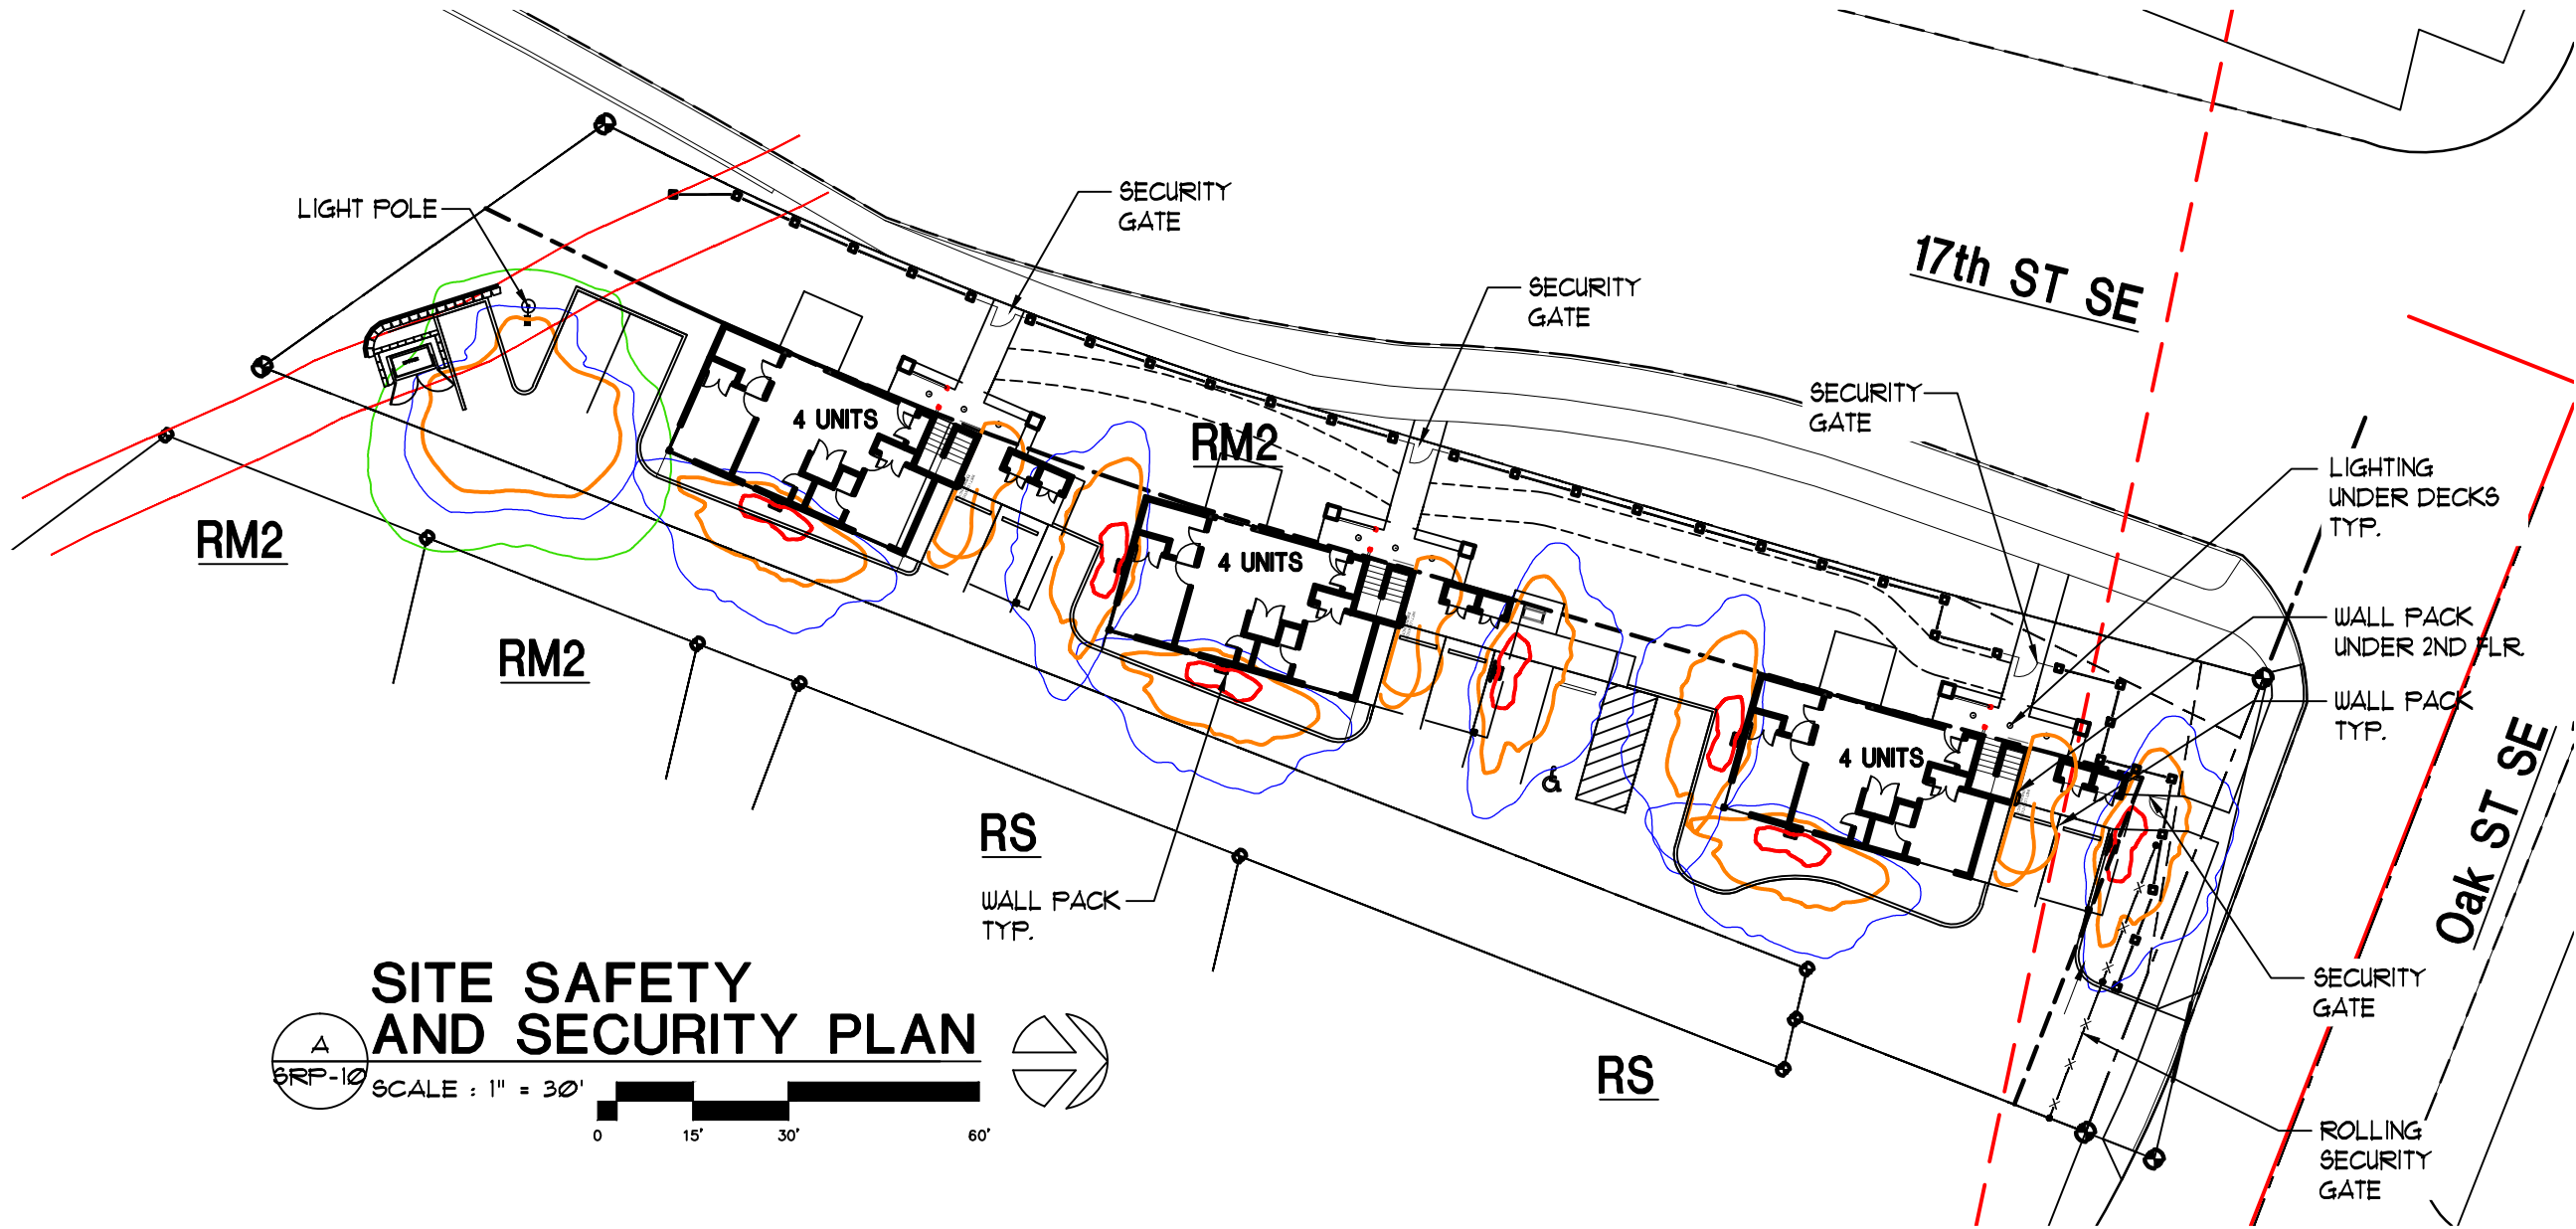

**SITE SAFETY
AND SECURITY PLAN**

SCALE : 1" = 30'

0 15' 30' 60'

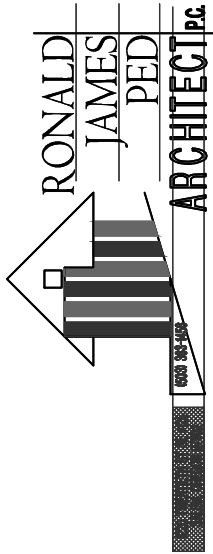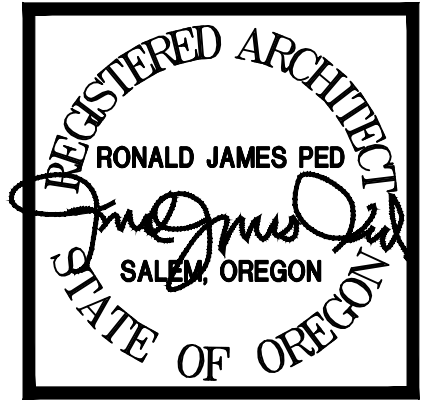

NEW APARTMENTS FOR:
SERVANDO GARCIA
17th and OAK, SALEM OR 97301

DATE: 02-07-2024
DRAWN: AK
JOB NO.: 2159

SPR-10